


Key Plan

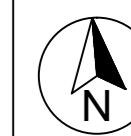

General Notes:

1. All dimensions are in meters, if otherwise specified.
2. Dimensions are to be read and not to be scaled.
3. The contractors must verify all dimensions on site and refer the relevant structural and other MEP drawings before commencing any work, and in case any discrepancy is noticed the same shall be brought to the notice of the Consultant and shall be clarified before execution of work.
4. All survey carried out through visual study of the building and no destructive analysis has been carried out.
5. Refer this drawing along with the other relevant architectural, structural and MEP services drawings.

Legends

Type	Opening Size	Frame and Panel	Additional
D1	1000x2100	Wood	Mortise with levers on both sides, dead lock with key entry from outside, tower bolts on inside
W1	1200x1800	Aluminium	2 panel Sliding window
W2	900x1200	Aluminium	Toilet window with exhaust fan with louvers
V1	1500x750	Aluminium	Ventilator at Parking area

Client

Jabalpur Smart City Limited



Submitted by

IFE GLOBAL
CONSTRUCTION CONSULTING PRIVATE LIMITED
 IFE GLOBAL LIMITED
 B-84, Defence Colony, New Delhi - 110024

Project

**COMMUNITY MARRIAGE HALL,
 GARHA, JABALPUR**

Sub-project

Rev.	Date	Description	Approved

Revision Index


Drawing Title

Ground Floor Plan

<input checked="" type="checkbox"/> For Tender <input type="checkbox"/> For Information <input type="checkbox"/> For Execution	Date	Drawn
	August 13, 2019	PB
Scale	Sheet Size	Checked
	A1	SRK
		Approved
		SRK

Dwg. No.	Revision
IFE/JSCL/CMH/01	


GROUND FLOOR PLAN

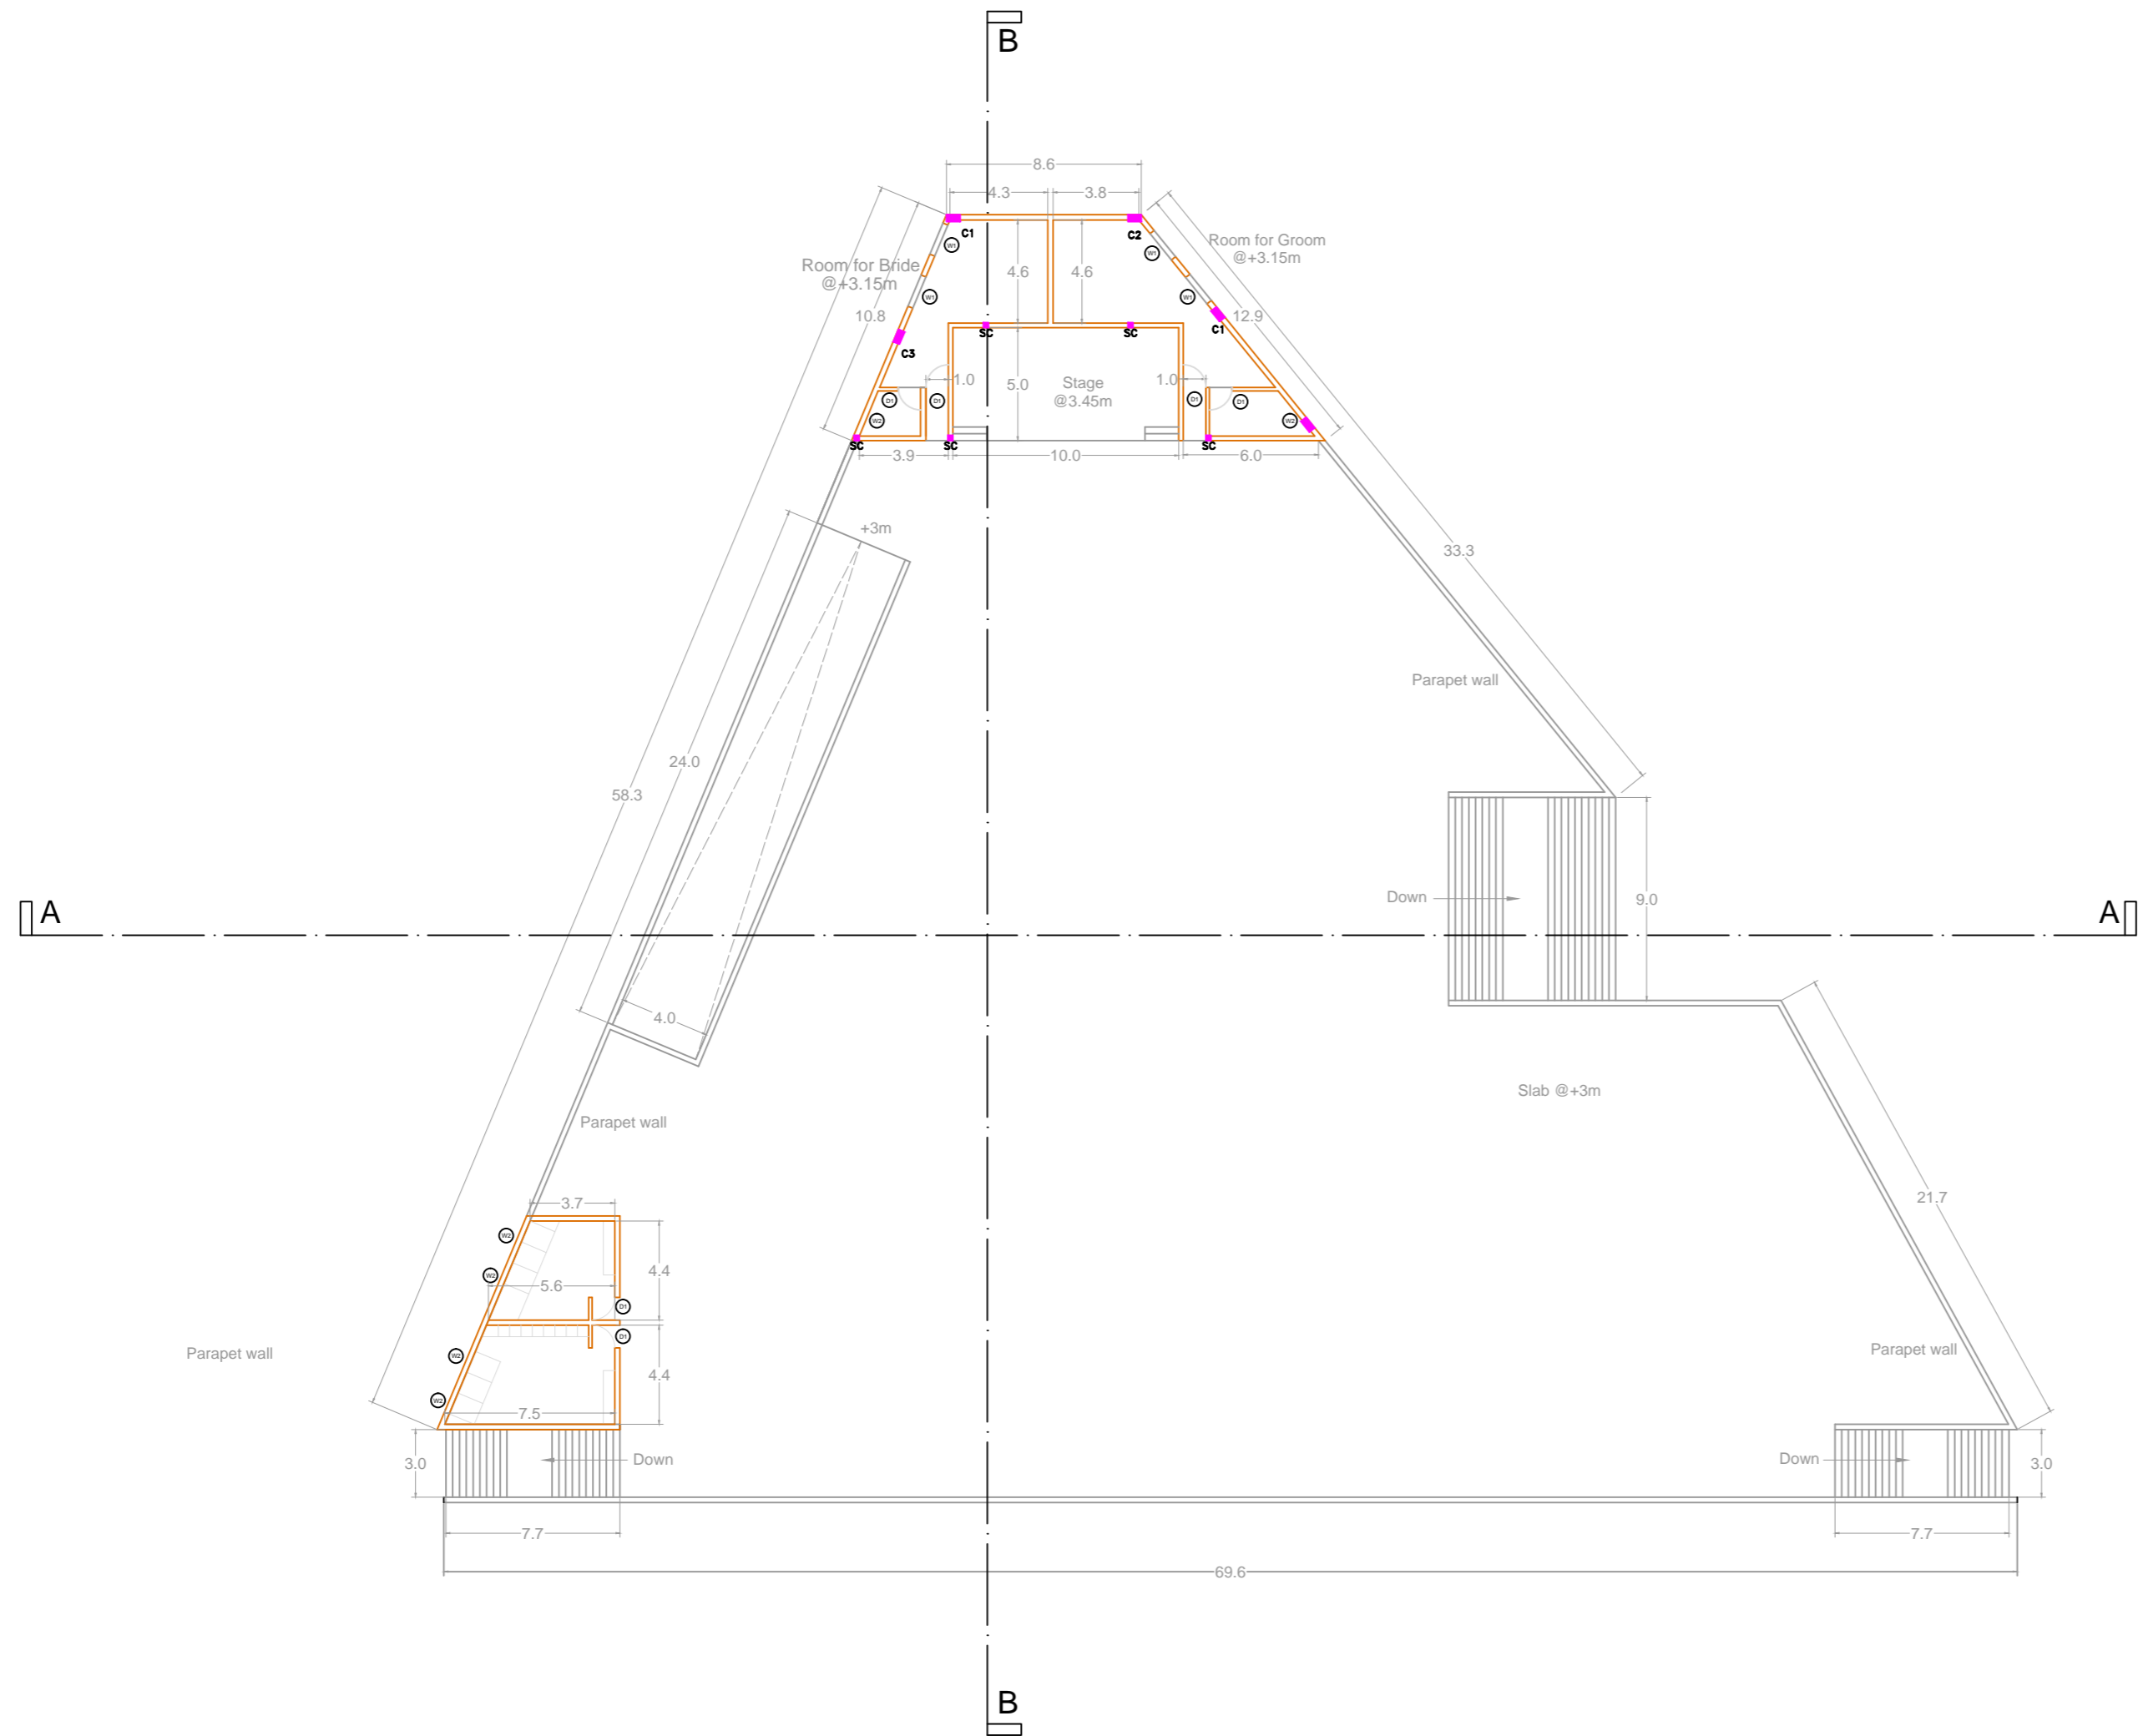

**1ST FLOOR PLAN
@ +3.0M**

FIRST FLOOR PLAN

Key Plan

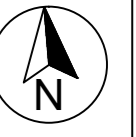

General Notes:

1. All dimensions are in meters, if otherwise specified.
2. Dimensions are to be read and not to be scaled.
3. The contractors must verify all dimensions on site and refer the relevant structural and other MEP drawings before commencing any work, and in case any discrepancy is noticed the same shall be brought to the notice of the Consultant and shall be clarified before execution of work.
4. All survey carried out through visual study of the building and no destructive analysis has been carried out.
5. Refer this drawing along with the other relevant architectural, structural and MEP services drawings.

Legends

Type	Opening Size	Frame and Panel	Additional
D1	1000x2100	Wood	Mortise with levers on both sides, dead lock with key entry from outside, tower bolts on inside
W1	1200x1800	Aluminium	2 panel Sliding window
W2	900x1200	Aluminium	Toilet window with exhaust fan with louvers
V1	1500x750	Aluminium	Ventilator at Parking area

Client

Jabalpur Smart City Limited



Submitted by

IPE GLOBAL
CORPORATE BUILDING DESIGNS
IPE GLOBAL LIMITED
B-84, Defence Colony, New Delhi - 110024

Project

**COMMUNITY MARRIAGE HALL,
GARHA, JABALPUR**

Sub-project

Rev.	Date	Description	Approved



Revision Index

Drawing Title

First Floor Plan


<input checked="" type="checkbox"/> For Tender <input type="checkbox"/> For Information <input type="checkbox"/> For Execution	Date	August 13, 2019	Drawn PB
	Scale		Checked SRK
	Sheet Size	A1	Approved SRK

Dwg. No.	Revision
IPE/JSCL/CMH/02	

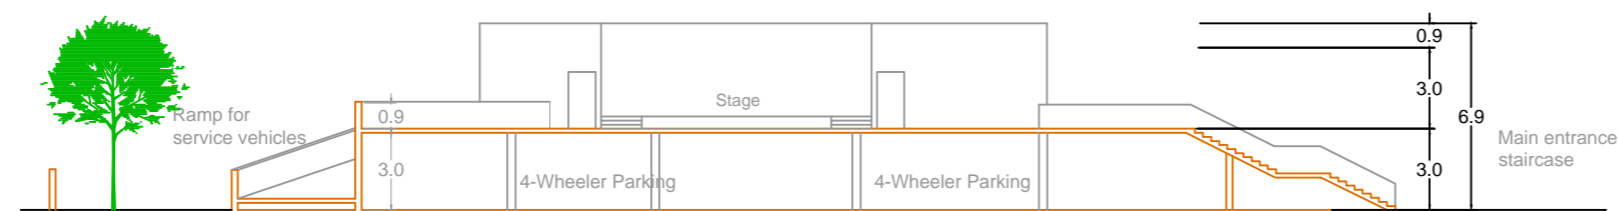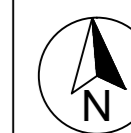

SECTION AA



SECTION AA

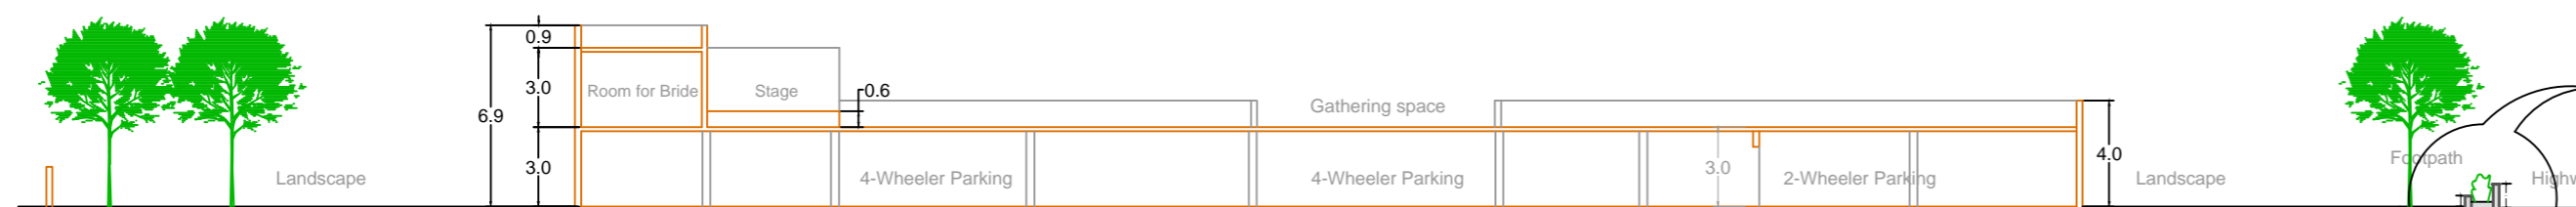

SECTION BB

SECTION BB

Detail X

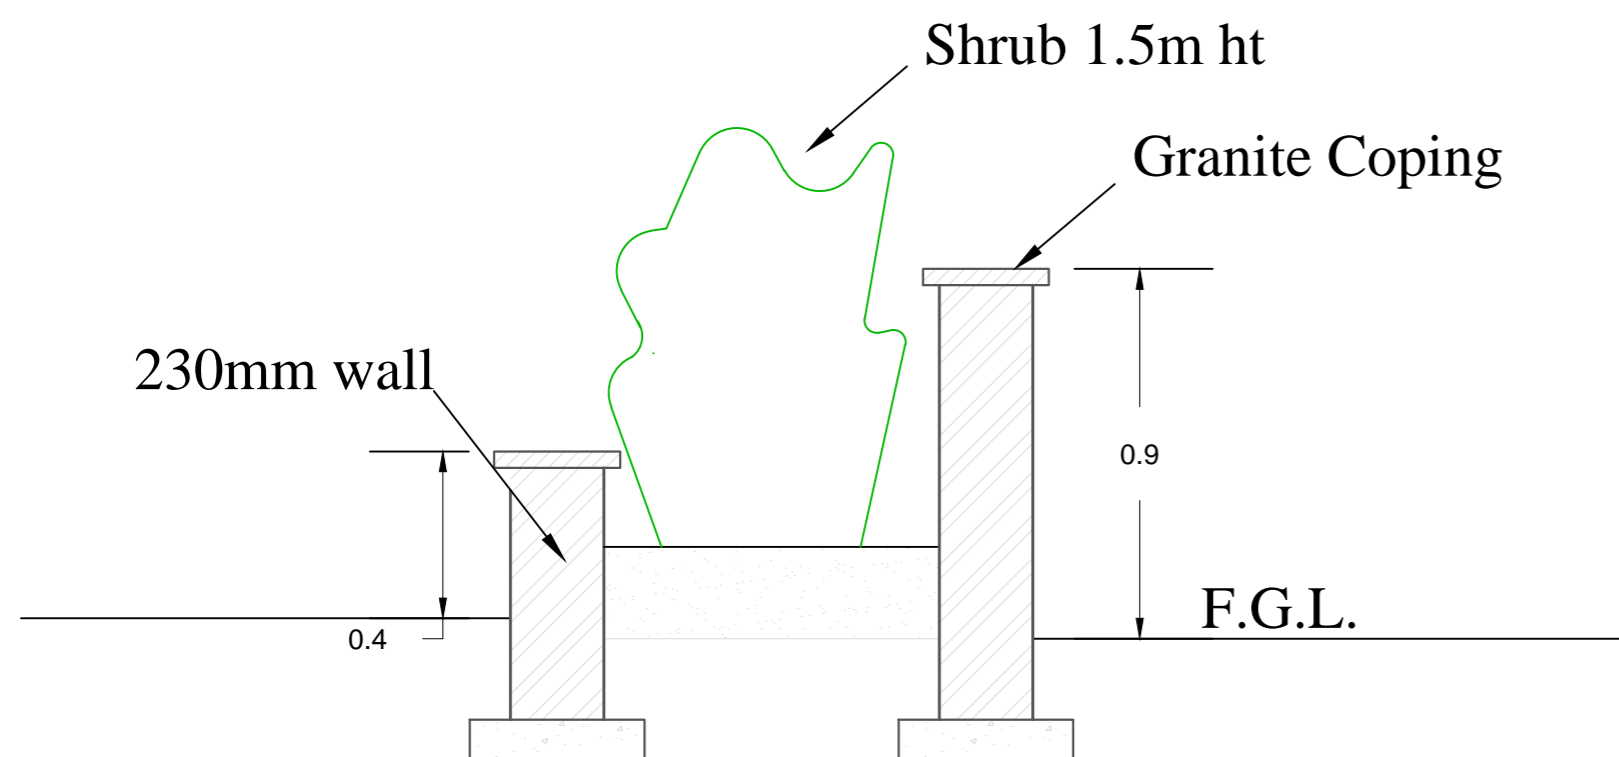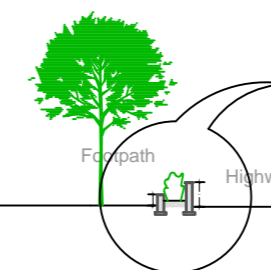

DETAIL X

General Notes:

1. All dimensions are in meters, if otherwise specified.
2. Dimensions are to be read and not to be scaled.
3. The contractors must verify all dimensions on site and refer the relevant structural and other MEP drawings before commencing any work, and in case any discrepancy is noticed the same shall be brought to the notice of the Consultant and shall be clarified before execution of work.
4. All survey carried out through visual study of the building and no destructive analysis has been carried out.
5. Refer this drawing along with the other relevant architectural, structural and MEP services drawings.

Legends

Client

Jabalpur Smart City Limited



Submitted by

IPE GLOBAL
Leading Interior Building Firm
 IPE GLOBAL LIMITED
 B-84, Defence Colony, New Delhi - 110024

Project

**COMMUNITY MARRIAGE HALL,
 GARHA, JABALPUR**

Sub-project

Rev.	Date	Description	Approved


Revision Index

Drawing Title

Section Detail

<input checked="" type="checkbox"/> For Tender <input type="checkbox"/> For Information <input type="checkbox"/> For Execution	Date	Drawn
	August 13, 2019	PB
	Scale	Checked
	Sheet Size	SRK
	A3	Approved
		SRK

Dwg. No.	Revision
IPJ/JSCL/CMH/03	

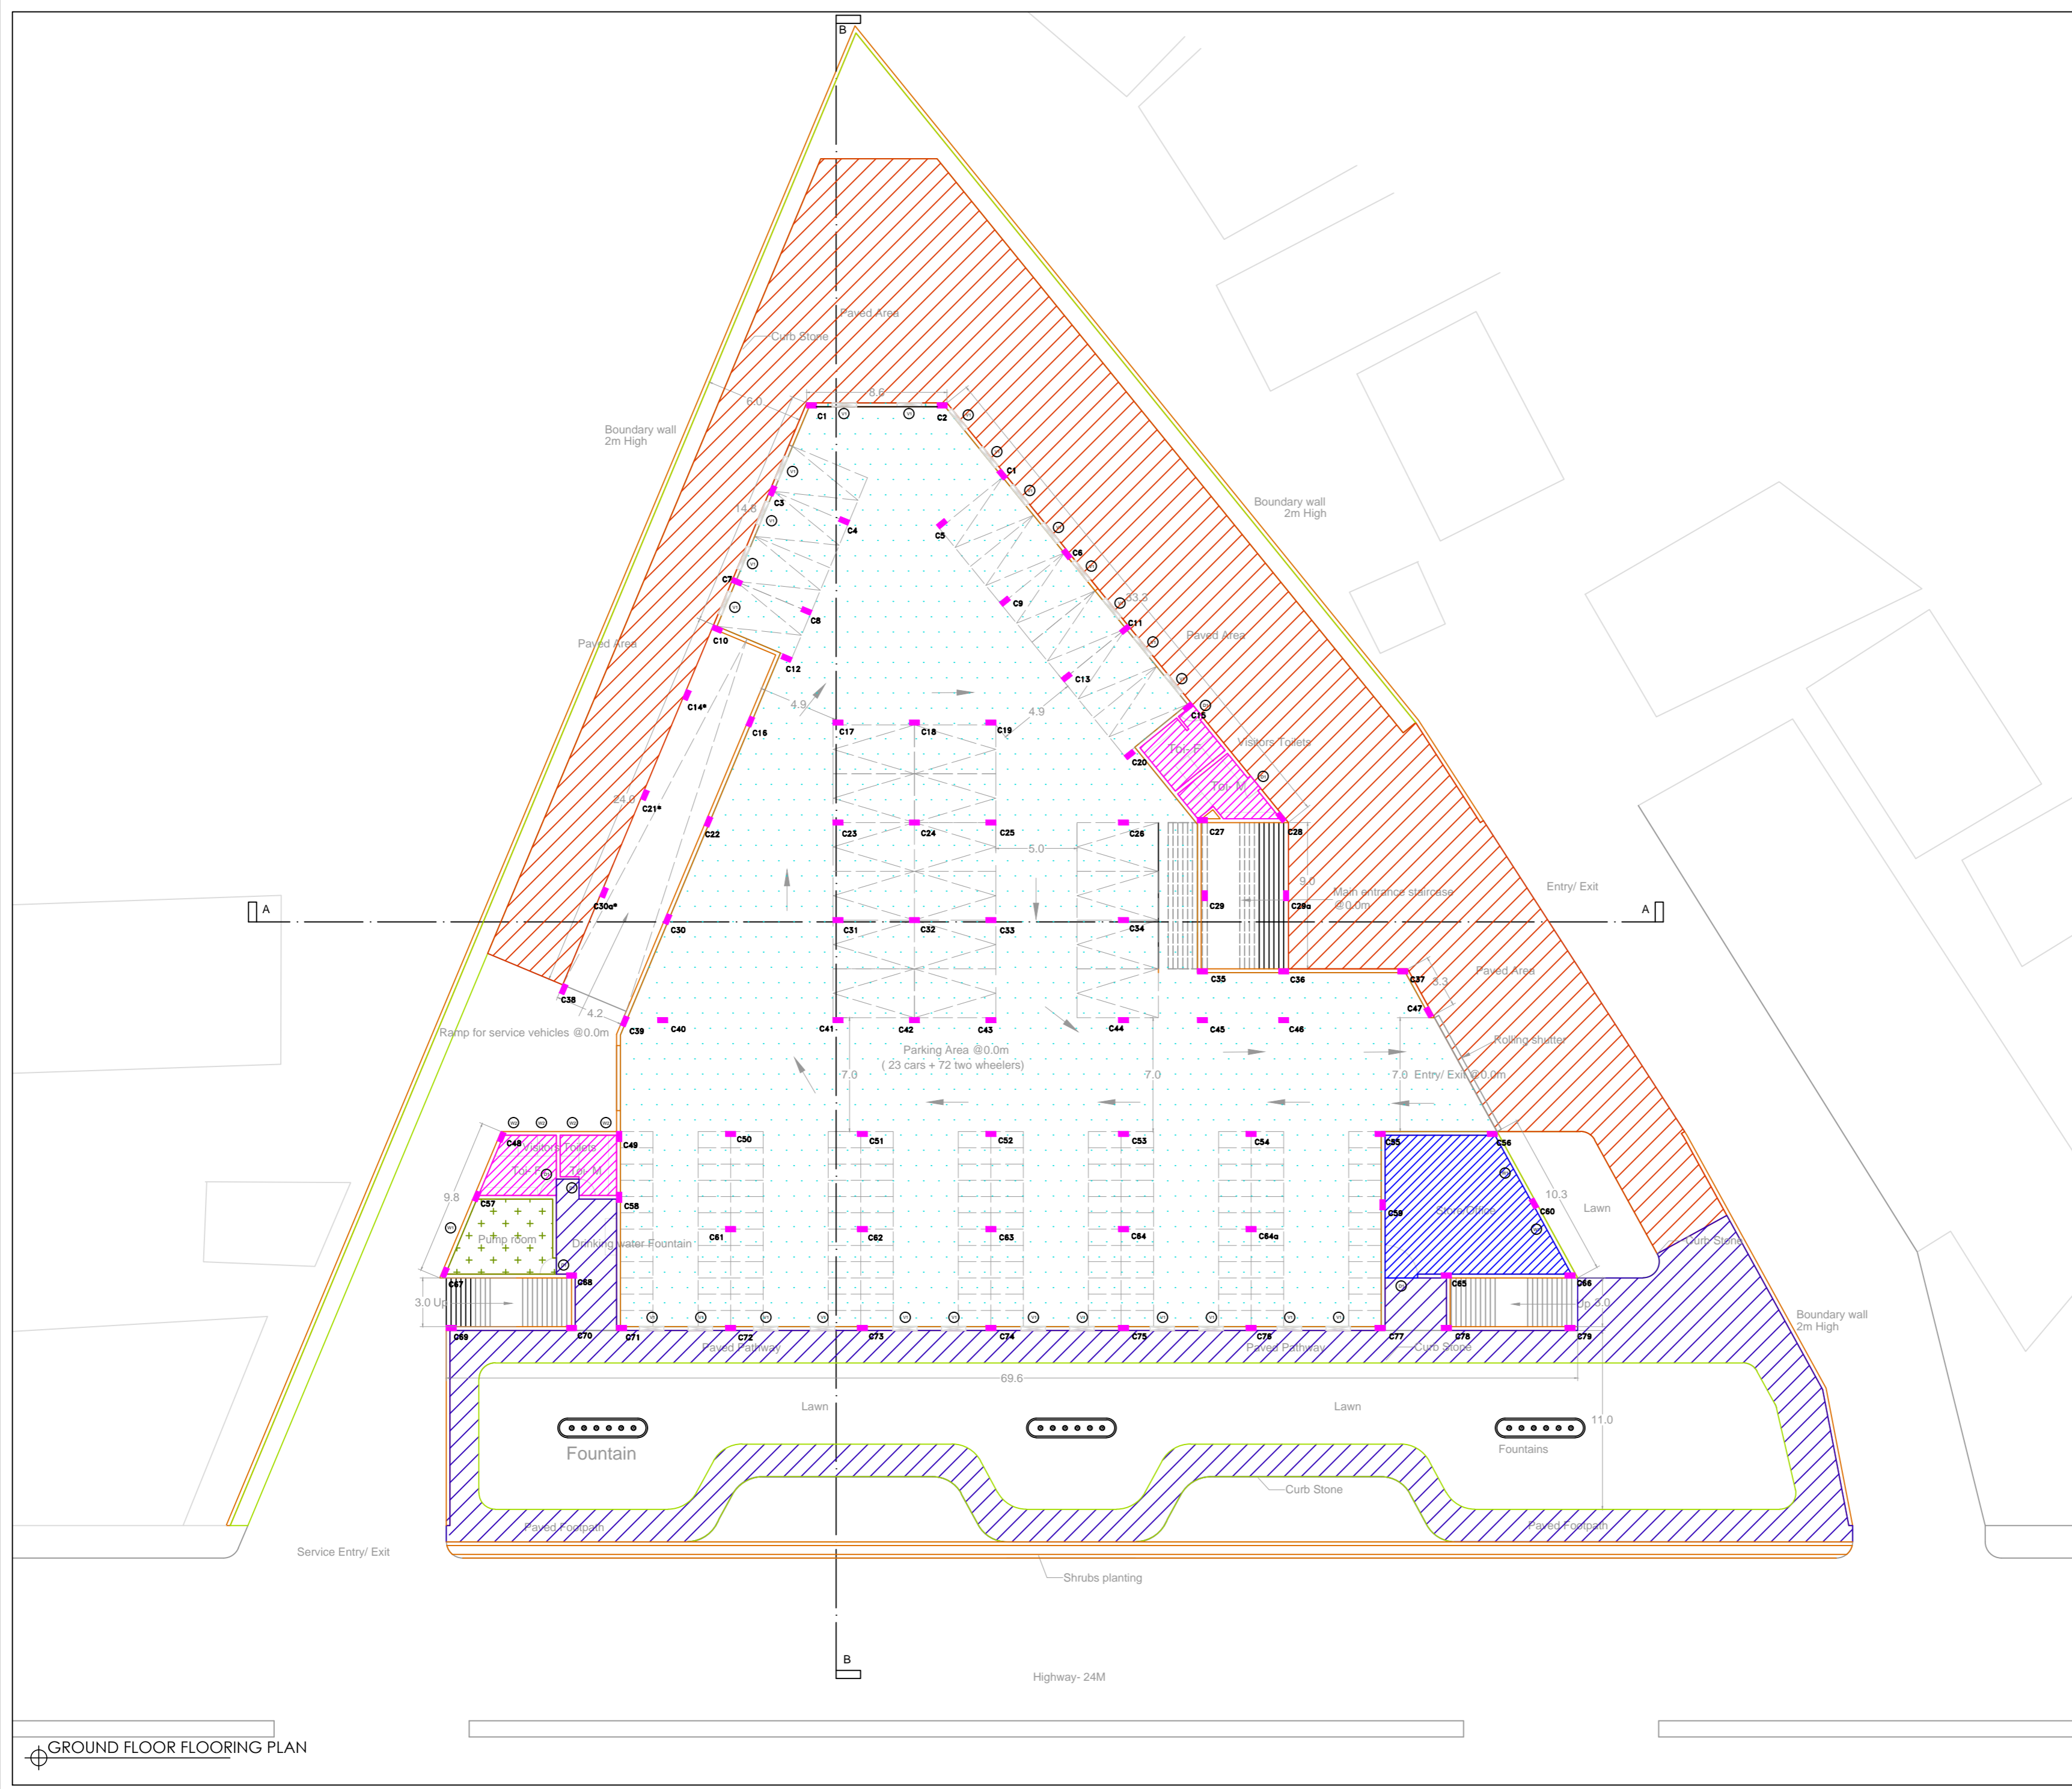

Key Plan



General Notes:

1. All dimensions are in millimeters, if otherwise specified.
2. Dimensions are to be read and not to be scaled.
3. The contractors must verify all dimensions on site and refer the relevant structural and other MEP drawings before commencing any work, and in case any discrepancy is noticed the same shall be brought to the notice of the Consultant and shall be clarified before execution of work.
4. All survey carried out through visual study of the building and no destructive analysis has been carried out.
5. Refer this drawing along with the other relevant architectural, structural and MEP services drawings.

Legends

S.No.	Symbol	Material
1		Paver Block
2		Kota Stone 600mm x 600mm
3		Epoxy Floor
4		Heavy Duty Tile 900mm x 900mm
5		Ceramic Tile 300mm x 300mm
6		Vitrified Tile 900mm x 900mm

Client

Jabalpur Smart City Limited



Submitted by

IPG GLOBAL
CONSTRUCTION CONSULTING PRIVATE LIMITED
 IPE GLOBAL LIMITED
 B-84, Defence Colony, New Delhi -110024

Project

**COMMUNITY MARRIAGE HALL,
 GARHA, JABALPUR**

Sub-project

Rev.	Date	Description	Approved

Rev. Date Description Approved


Revision Index

Drawing Title

Ground Floor Flooring Plan


<input checked="" type="checkbox"/> For Tender <input type="checkbox"/> For Information <input type="checkbox"/> For Execution	Date	July 02, 2019	Drawn PB
	Scale	Sheet Size	Checked SRK
		A1	Approved SRK

Dwg. No. **IPE/JSCL/CMH/04** Revision

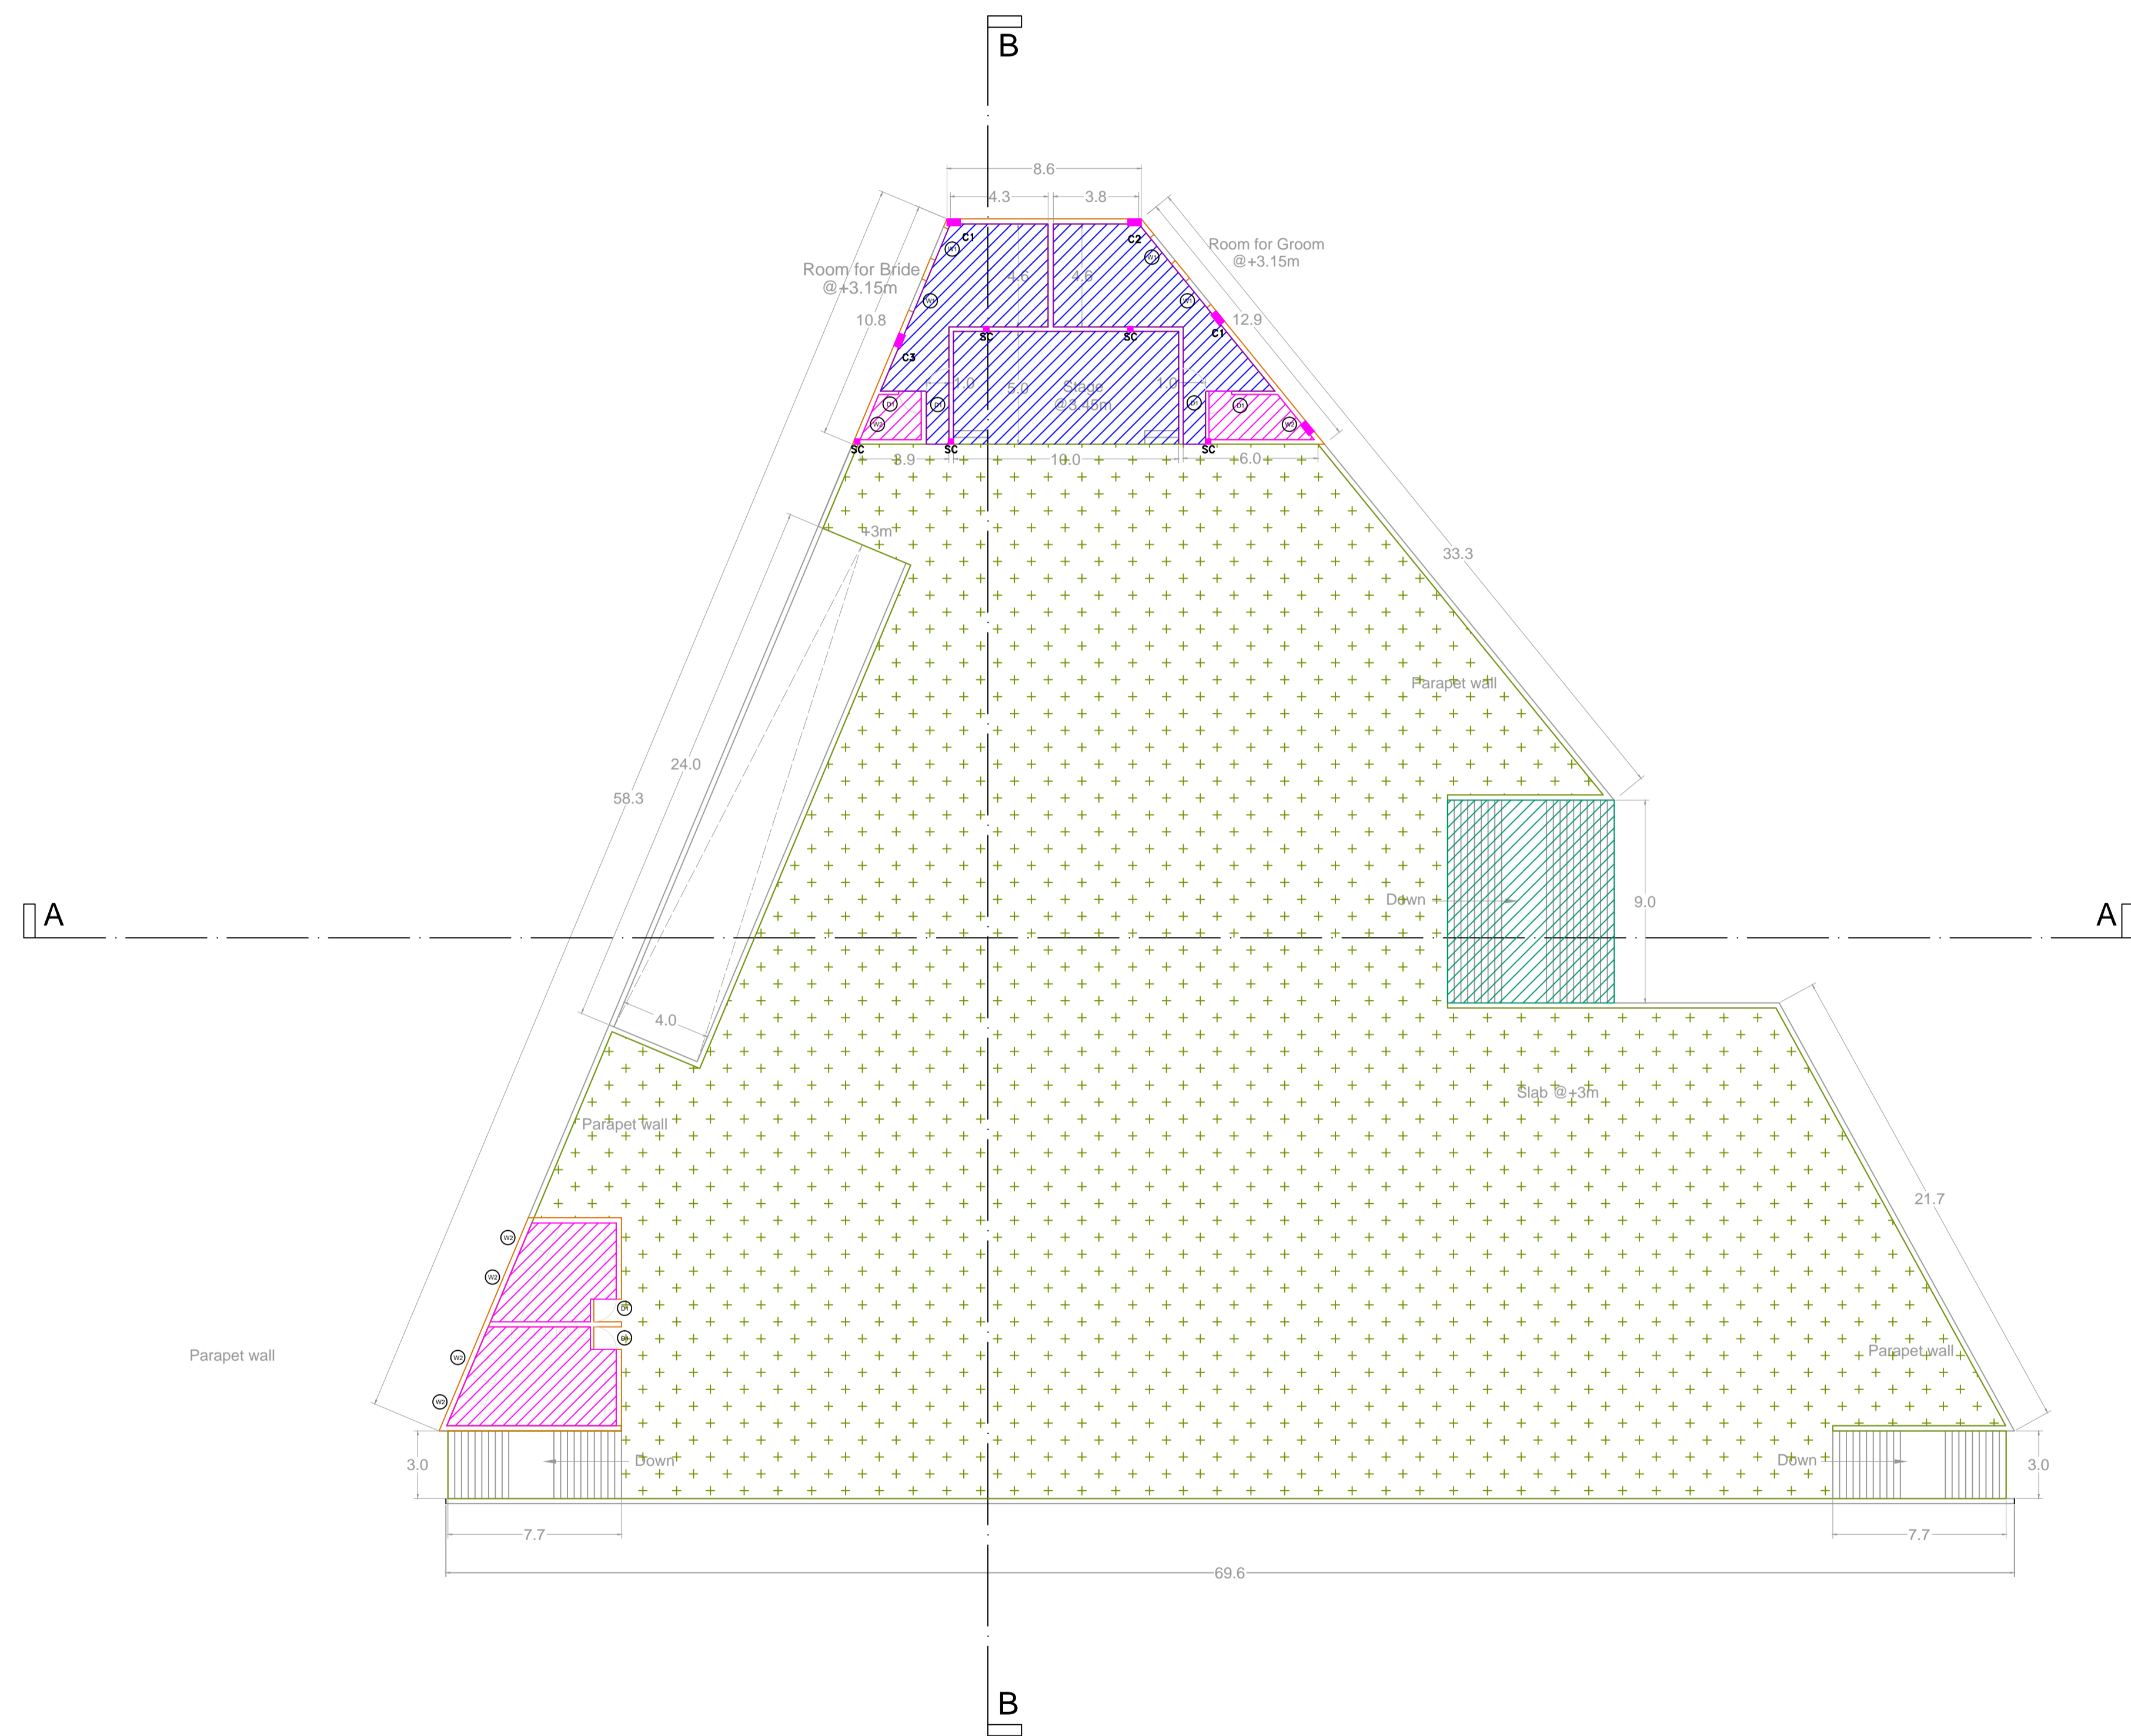

**1ST FLOOR PLAN
@ +3.0M**

Key Plan

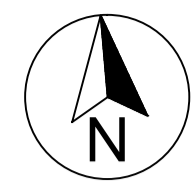

General Notes:

1. All dimensions are in millimeters, if otherwise specified.
2. Dimensions are to be read and not to be scaled.
3. The contractors must verify all dimensions on site and refer the relevant structural and other MEP drawings before commencing any work, and in case any discrepancy is noticed the same shall be brought to the notice of the Consultant and shall be clarified before execution of work.
4. All survey carried out through visual study of the building and no destructive analysis has been carried out.
5. Refer this drawing along with the other relevant architectural, structural and MEP services drawings.

Legends

S.No.	Symbol	Material
1		Ceramic Tile 300mm x 300mm
2		Kota Stone 600mm x 600mm
3		Granite 1200mm x 300mm
4		Vitrified Tile 900mm x 900mm

Client

Jabalpur Smart City Limited



Submitted by

IFE GLOBAL
INTERNATIONAL ENGINEERING CONSULTANTS
 IFE GLOBAL LIMITED
 B-84, Defence Colony, New Delhi - 110024

Project

**COMMUNITY MARRIAGE HALL,
GARHA, JABALPUR**

Sub-project

Rev.	Date	Description	Approved


Revision Index

Drawing Title


First Floor Flooring Plan

<input checked="" type="checkbox"/> For Tender <input type="checkbox"/> For Information <input type="checkbox"/> For Execution	Date	Drawn
	August 13, 2019	PB
	Scale	Checked
	Sheet Size	SRK
	A1	Approved
		SRK

Dwg. No.	Revision
IFE/JSCL/CMH/05	

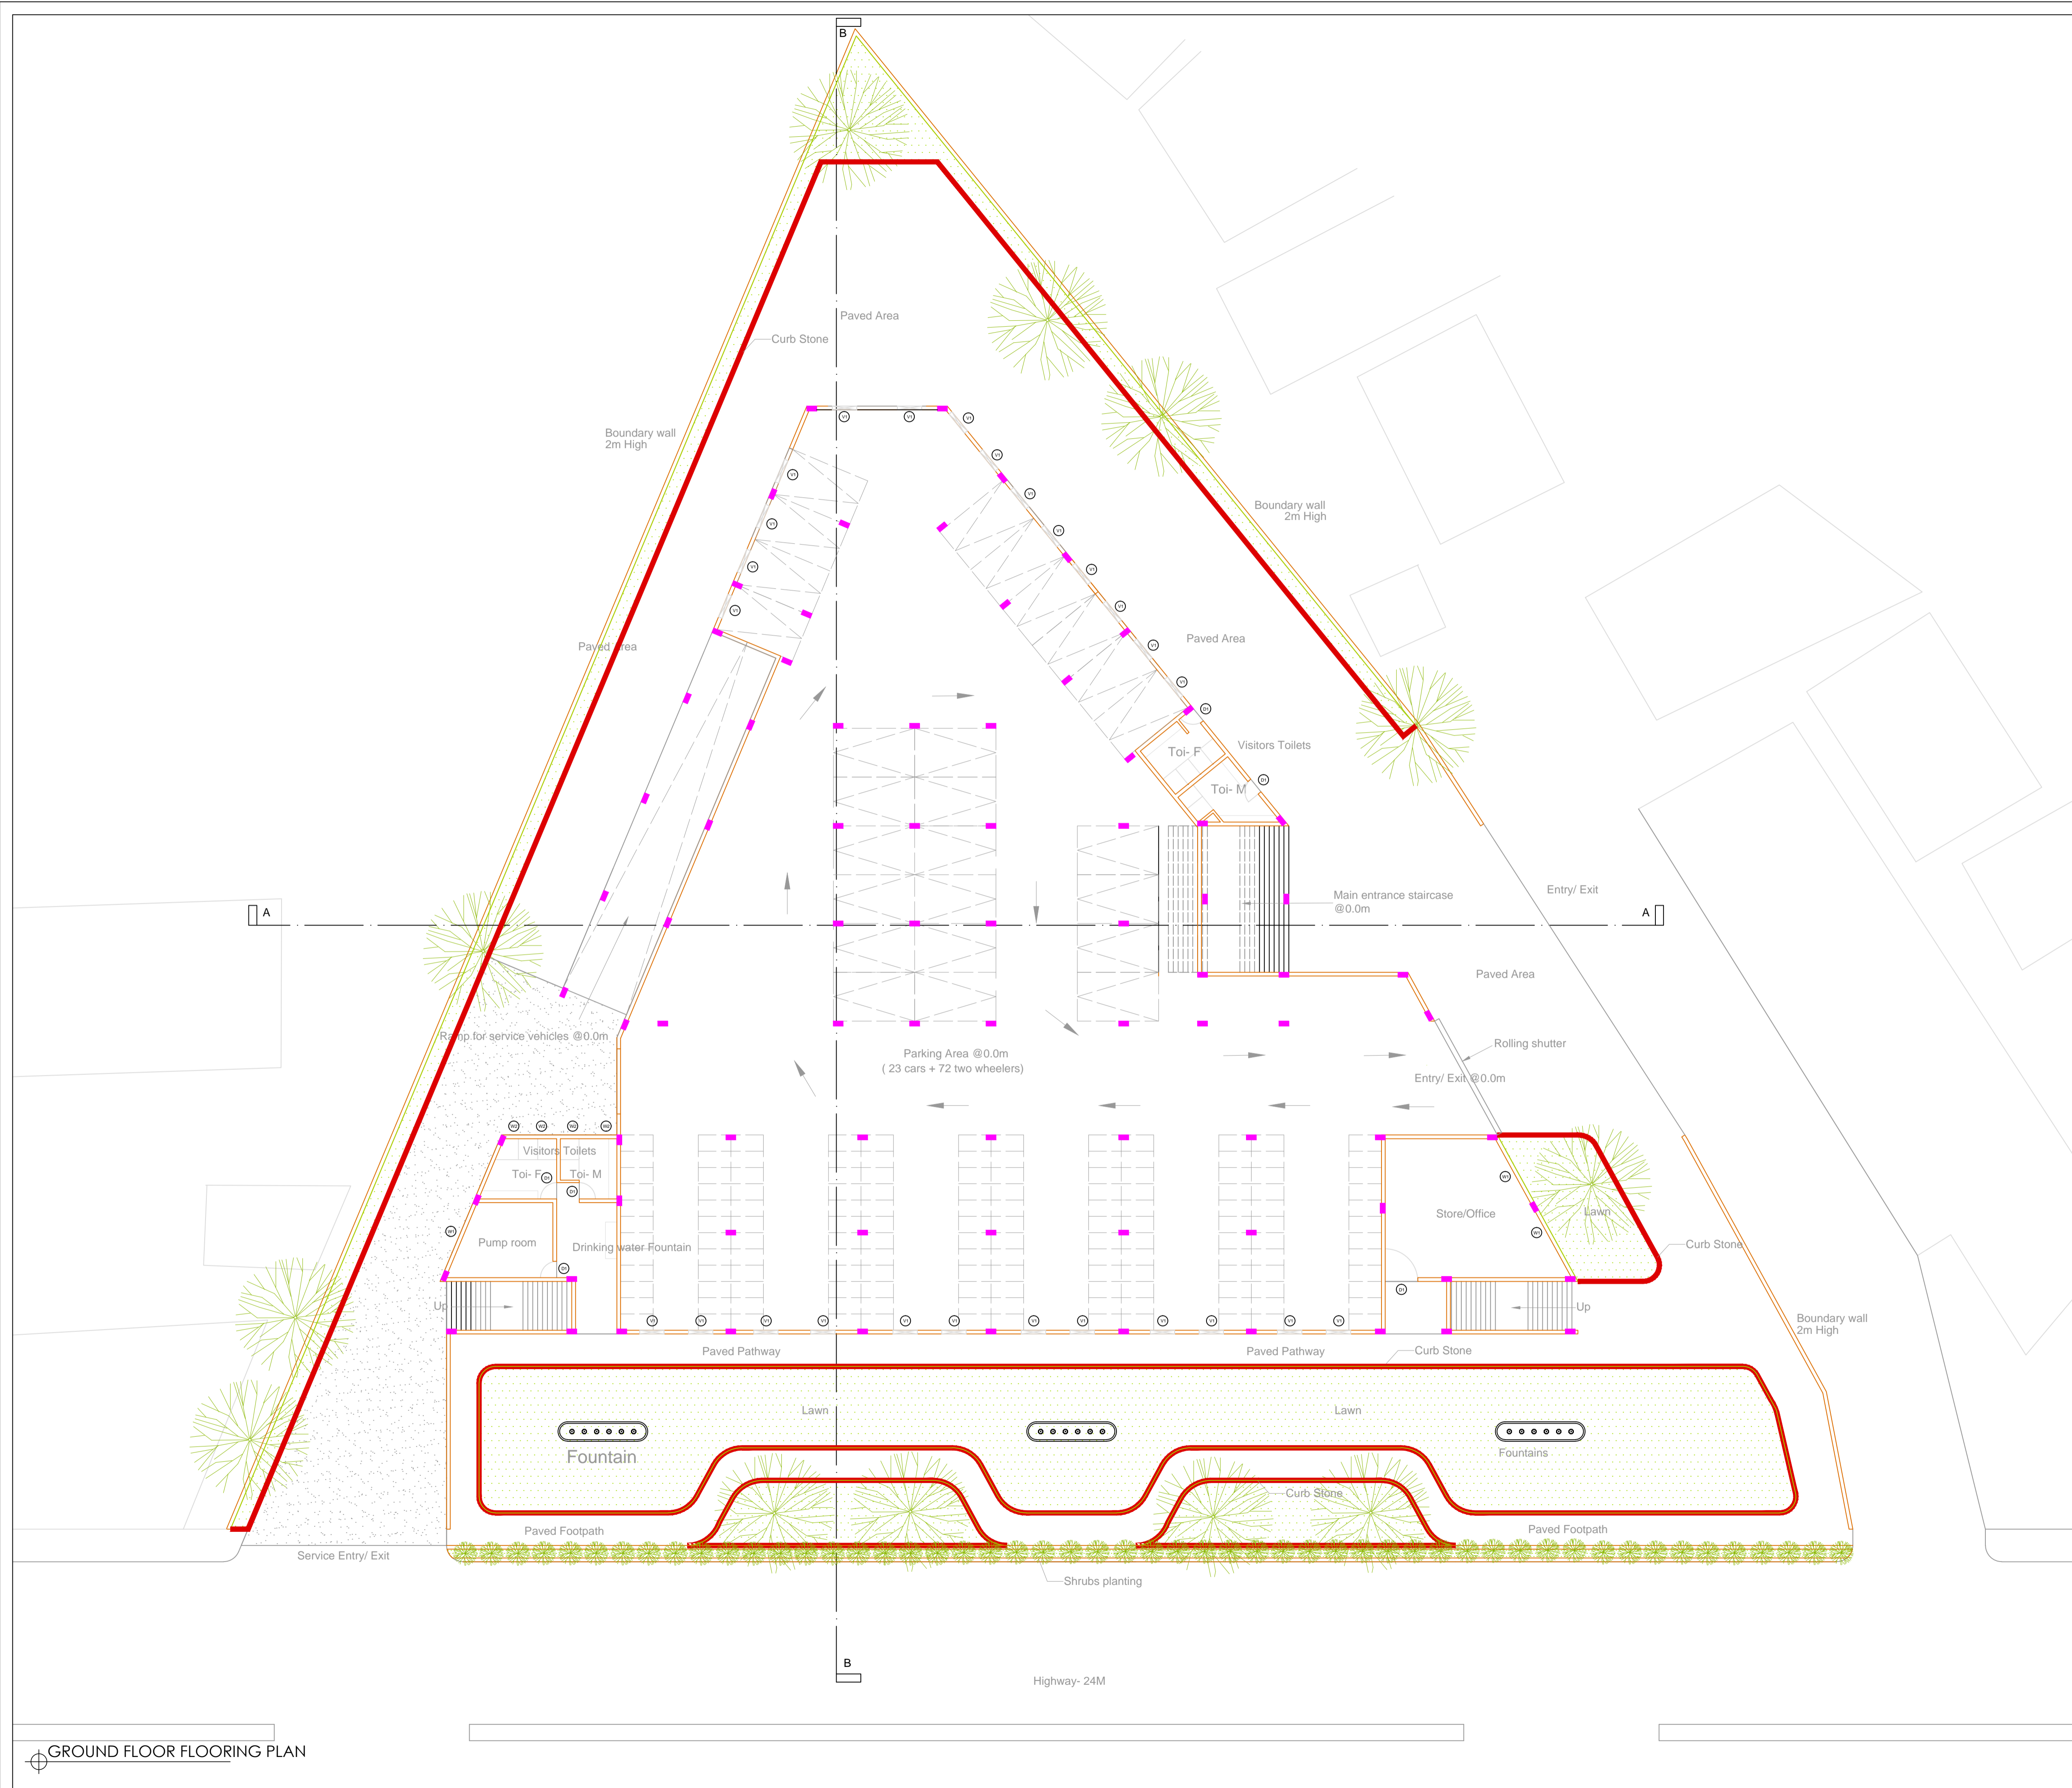

Key Plan

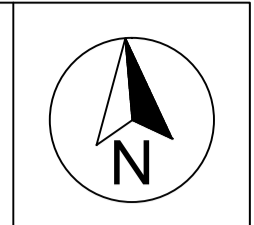

- General Notes:**
1. All dimensions are in millimeters, if otherwise specified.
 2. Dimensions are to be read and not to be scaled.
 3. The contractors must verify all dimensions on site and refer the relevant structural and other MEP drawings before commencing any work, and in case any discrepancy is noticed the same shall be brought to the notice of the Consultant and shall be clarified before execution of work.
 4. All survey carried out through visual study of the building and no destructive analysis has been carried out.
 5. Refer this drawing along with the other relevant architectural, structural and MEP services drawings.

Legends

S.No.	Symbol	Material
1		Carpet Grass
2		Kerb Stone 150mm thk.
3		6m High Trees
3		1m High Shrubs
3		Concrete pathway

Client
 Jabalpur Smart City Limited



Submitted by
IFE GLOBAL
 IFE GLOBAL LIMITED
 B-84, Defence Colony, New Delhi -110024

Project
**COMMUNITY MARRIAGE HALL,
 GARHA, JABALPUR**

Sub-project

Rev.	Date	Description	Approved

Revision Index



Drawing Title

Landscape Plan

<input checked="" type="checkbox"/> For Tender <input type="checkbox"/> For Information <input type="checkbox"/> For Execution	Date	Drawn
	August 13, 2019	PB
	Scale	Sheet Size
		Checked
		SRK
		Approved
		SRK

Dwg. No. **IFE/JSCL/CMH/06** Revision

GROUND FLOOR FLOORING PLAN

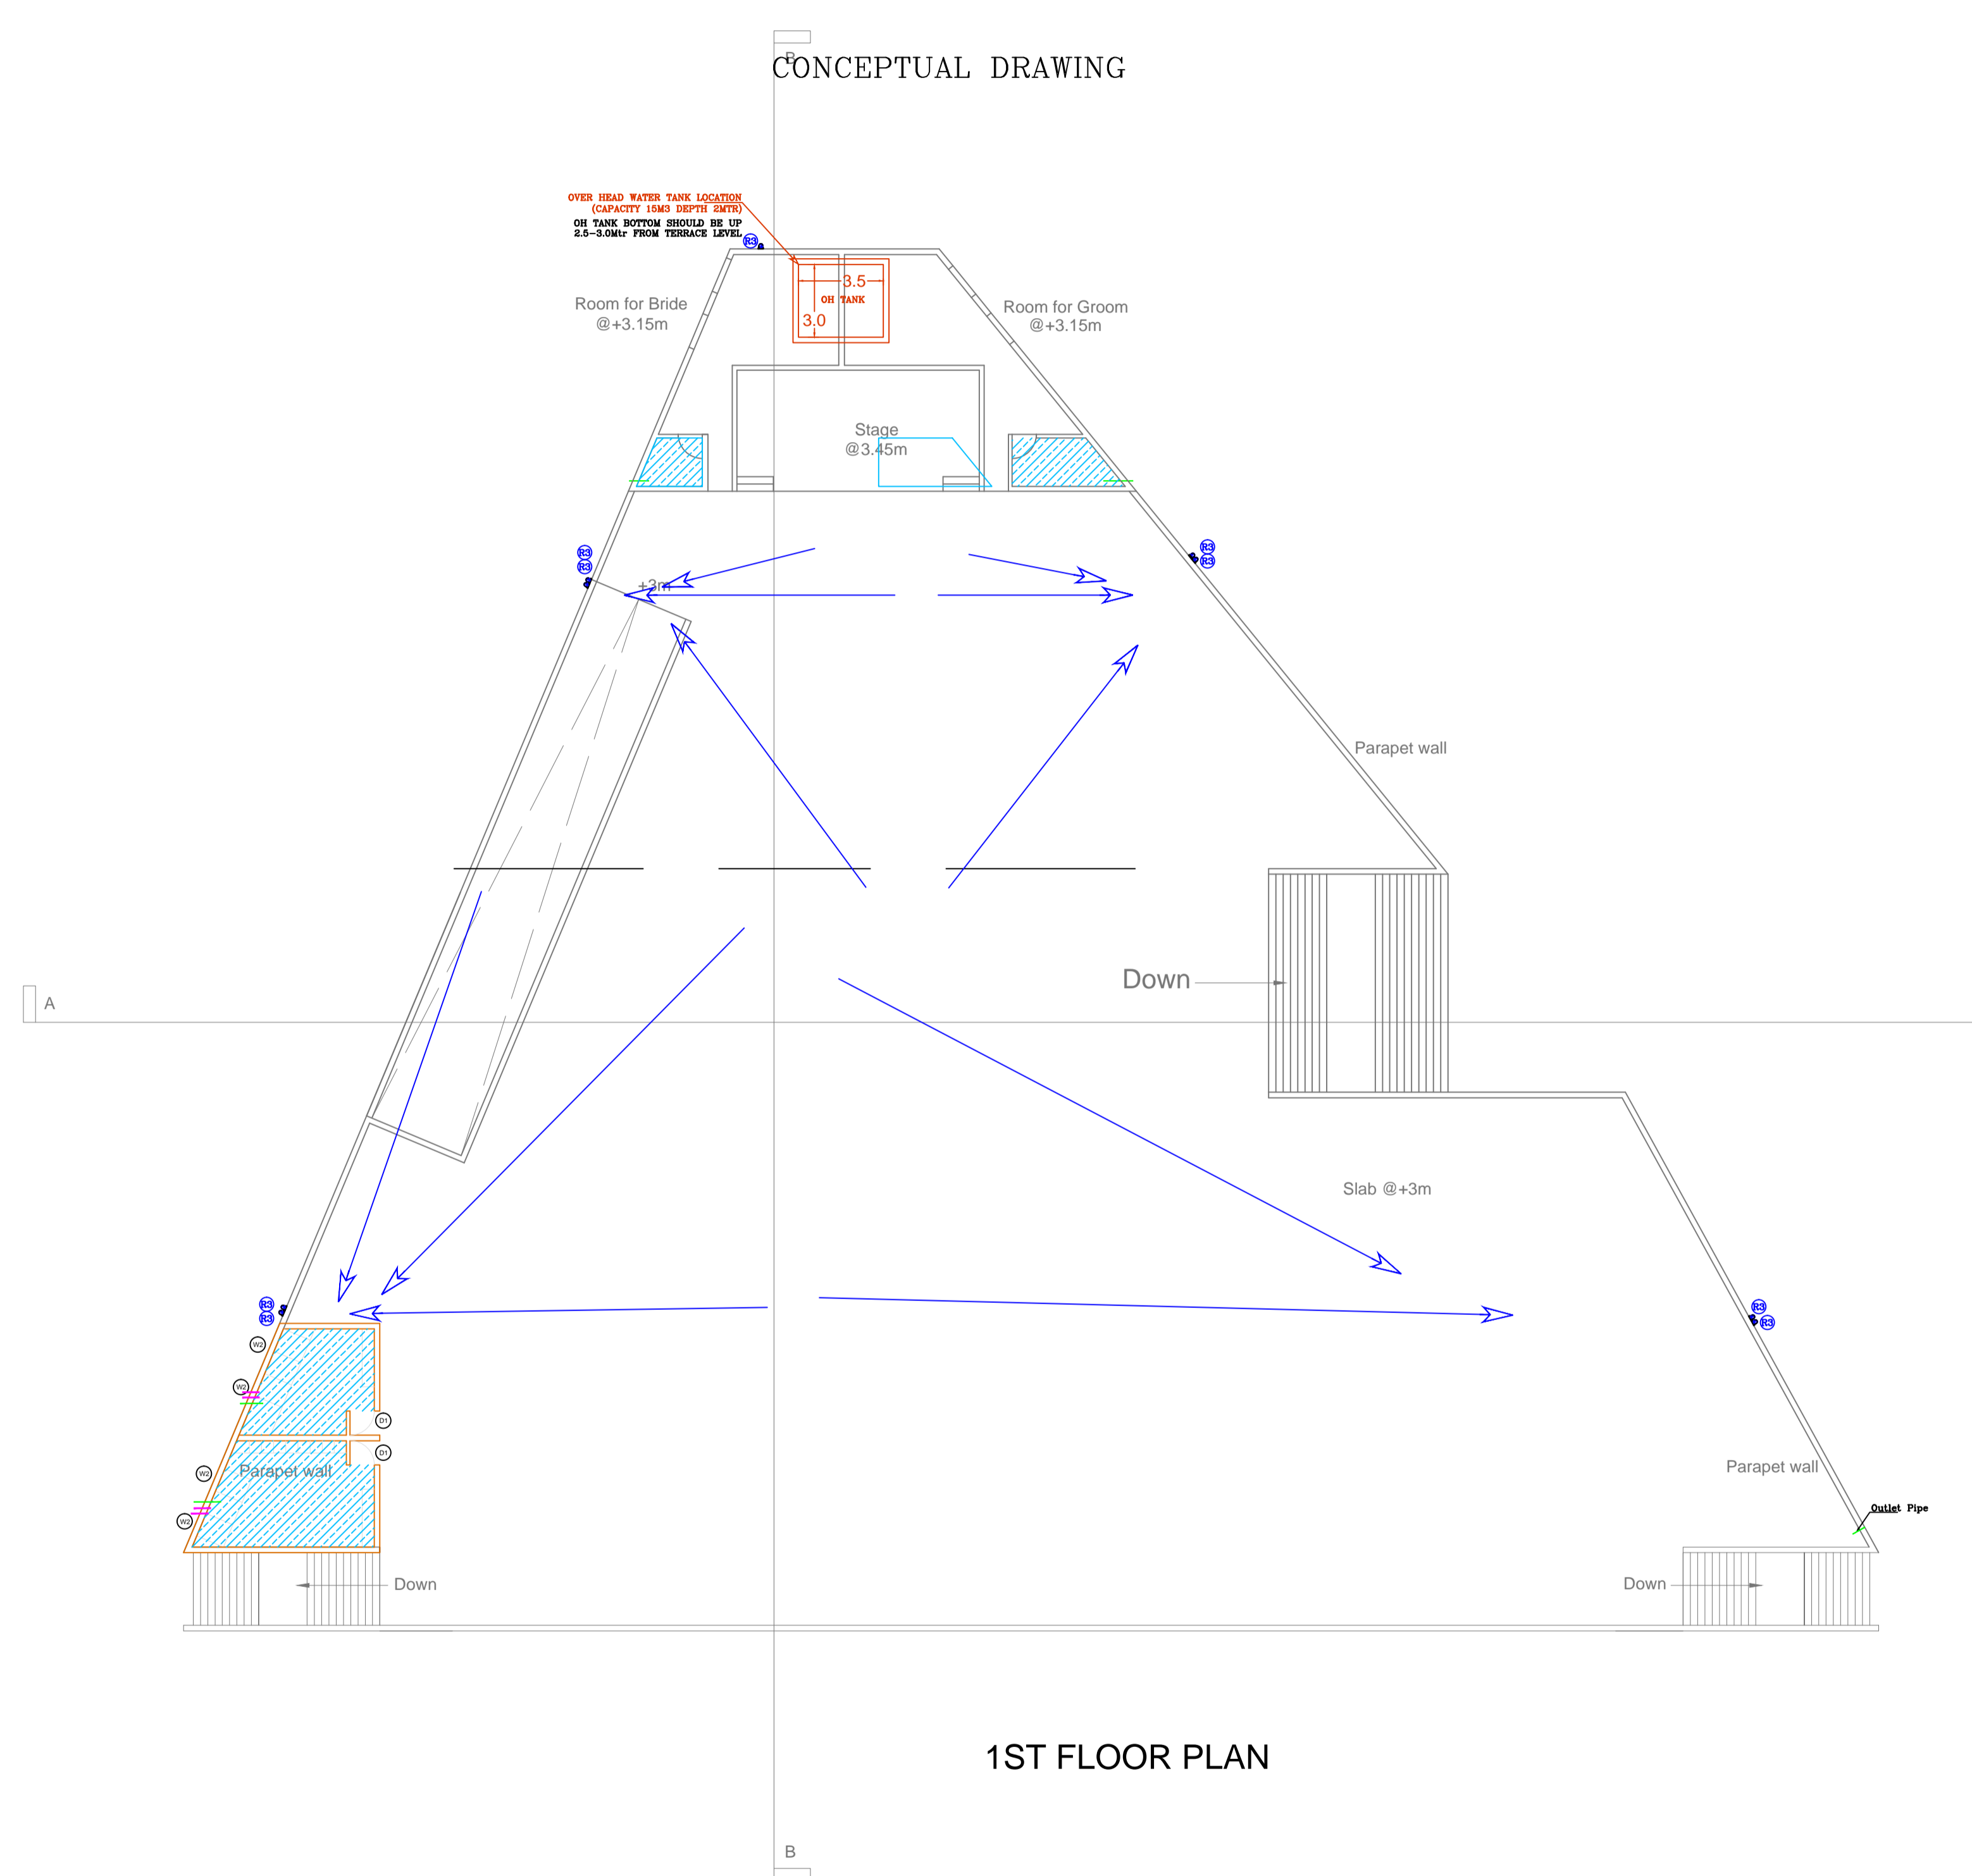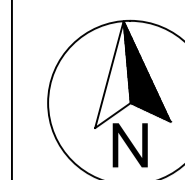

1ST FLOOR PLAN

COLOUR LEGENDS	
—	DOMESTIC WATER SUPPLY
—	DRAINAGE PIPE
—	SOIL PIPE
—	WASTE PIPE
—	TREATED WATER
—	GARDEN LINE
—	STORM WATER

SYMBOLS	
	BORE WELL
	CONTROL VALVE
	O.H.W.T.
	SEPTIC TANK
	U.G. TANK
	SOIL MANHOLE
	SOIL MANHOLE
	150 ϕ RCC HUME PIPE FOR CROSSING

RAIN WATER / ROAD CROSSING	
R	110mm OD 6kg/cm ² R.W.P
R2	75mm OD 6kg/cm ² R.W.P
R3	160mm OD 6kg/cm ² R.W.P

SOIL / WASTE / WATER SUPPLY	
A	100 ϕ SOIL DOWNTAKE PIPE
B	100 ϕ WASTE DOWNTAKE PIPE
C	100 ϕ SOIL PIPE 1:50
D	100 ϕ WASTE PIPE 1:50
E1	40 ϕ WASTE PIPE 1:50
E2	32 ϕ WASTE PIPE 1:50
T	75 ϕ ANTISYPHONAGE PIPE
V	75 ϕ VENT PIPE
V	75 ϕ VENT PIPE
F	DOMESTIC W.S. DOWNTAKE PIPE
I	DOMESTIC W.S. RISER/INLET

PLUMBING SYSTEM	
K	100X150 GULLY TRAP W/300X300MM CHAMBER
P1	R.C.C. HUME PIPE
P1	R.C.C. HUME PIPE

- NOTES**
- PIPES LOCATIONS CAN BE CHANGED AS PER FINAL TOILET FIXTURE LAYOUT.
 - MINOR CHANGES CAN BE DONE AS PER SITE CONDITION.
 - SEPTIC TANK & UG TANK LOCATION CAN BE CHANGE AS ARCHITECT.
 - THIS IS CONCEPTUAL PLUMBING LAYOUT NOT FINAL DRAWINGS.

- General Notes:**
- All dimensions are in millimeters, if otherwise specified.
 - Dimensions are to be read and not to be scaled.
 - The contractors must verify all dimensions on site and refer the relevant structural and other MEP drawings before commencing any work, and in case any discrepancy is noticed the same shall be brought to the notice of the Consultant and shall be clarified before execution of work.
 - All survey carried out through visual study of the building and no destructive analysis has been carried out.
 - Refer this drawing along with the other relevant architectural, structural and MEP services drawings.

Legends

Client
Jabalpur Smart City Limited



Submitted by
IPE GLOBAL
IPE GLOBAL LIMITED
B-84, Defence Colony, New Delhi - 110024

Project
**COMMUNITY MARRIAGE HALL,
GARHA, JABALPUR**

Sub-project

Rev.	Date	Description	Approved


Revision Index

Drawing Title


First Floor PHE Detail

<input checked="" type="checkbox"/> For Tender <input type="checkbox"/> For Information <input type="checkbox"/> For Execution	Date	August 13, 2019	Drawn PB
	Scale		Checked SRK
	Sheet Size	A1	Approved SRK

Dwg. No.	Revision
IPE/JSCL/CMH/8	

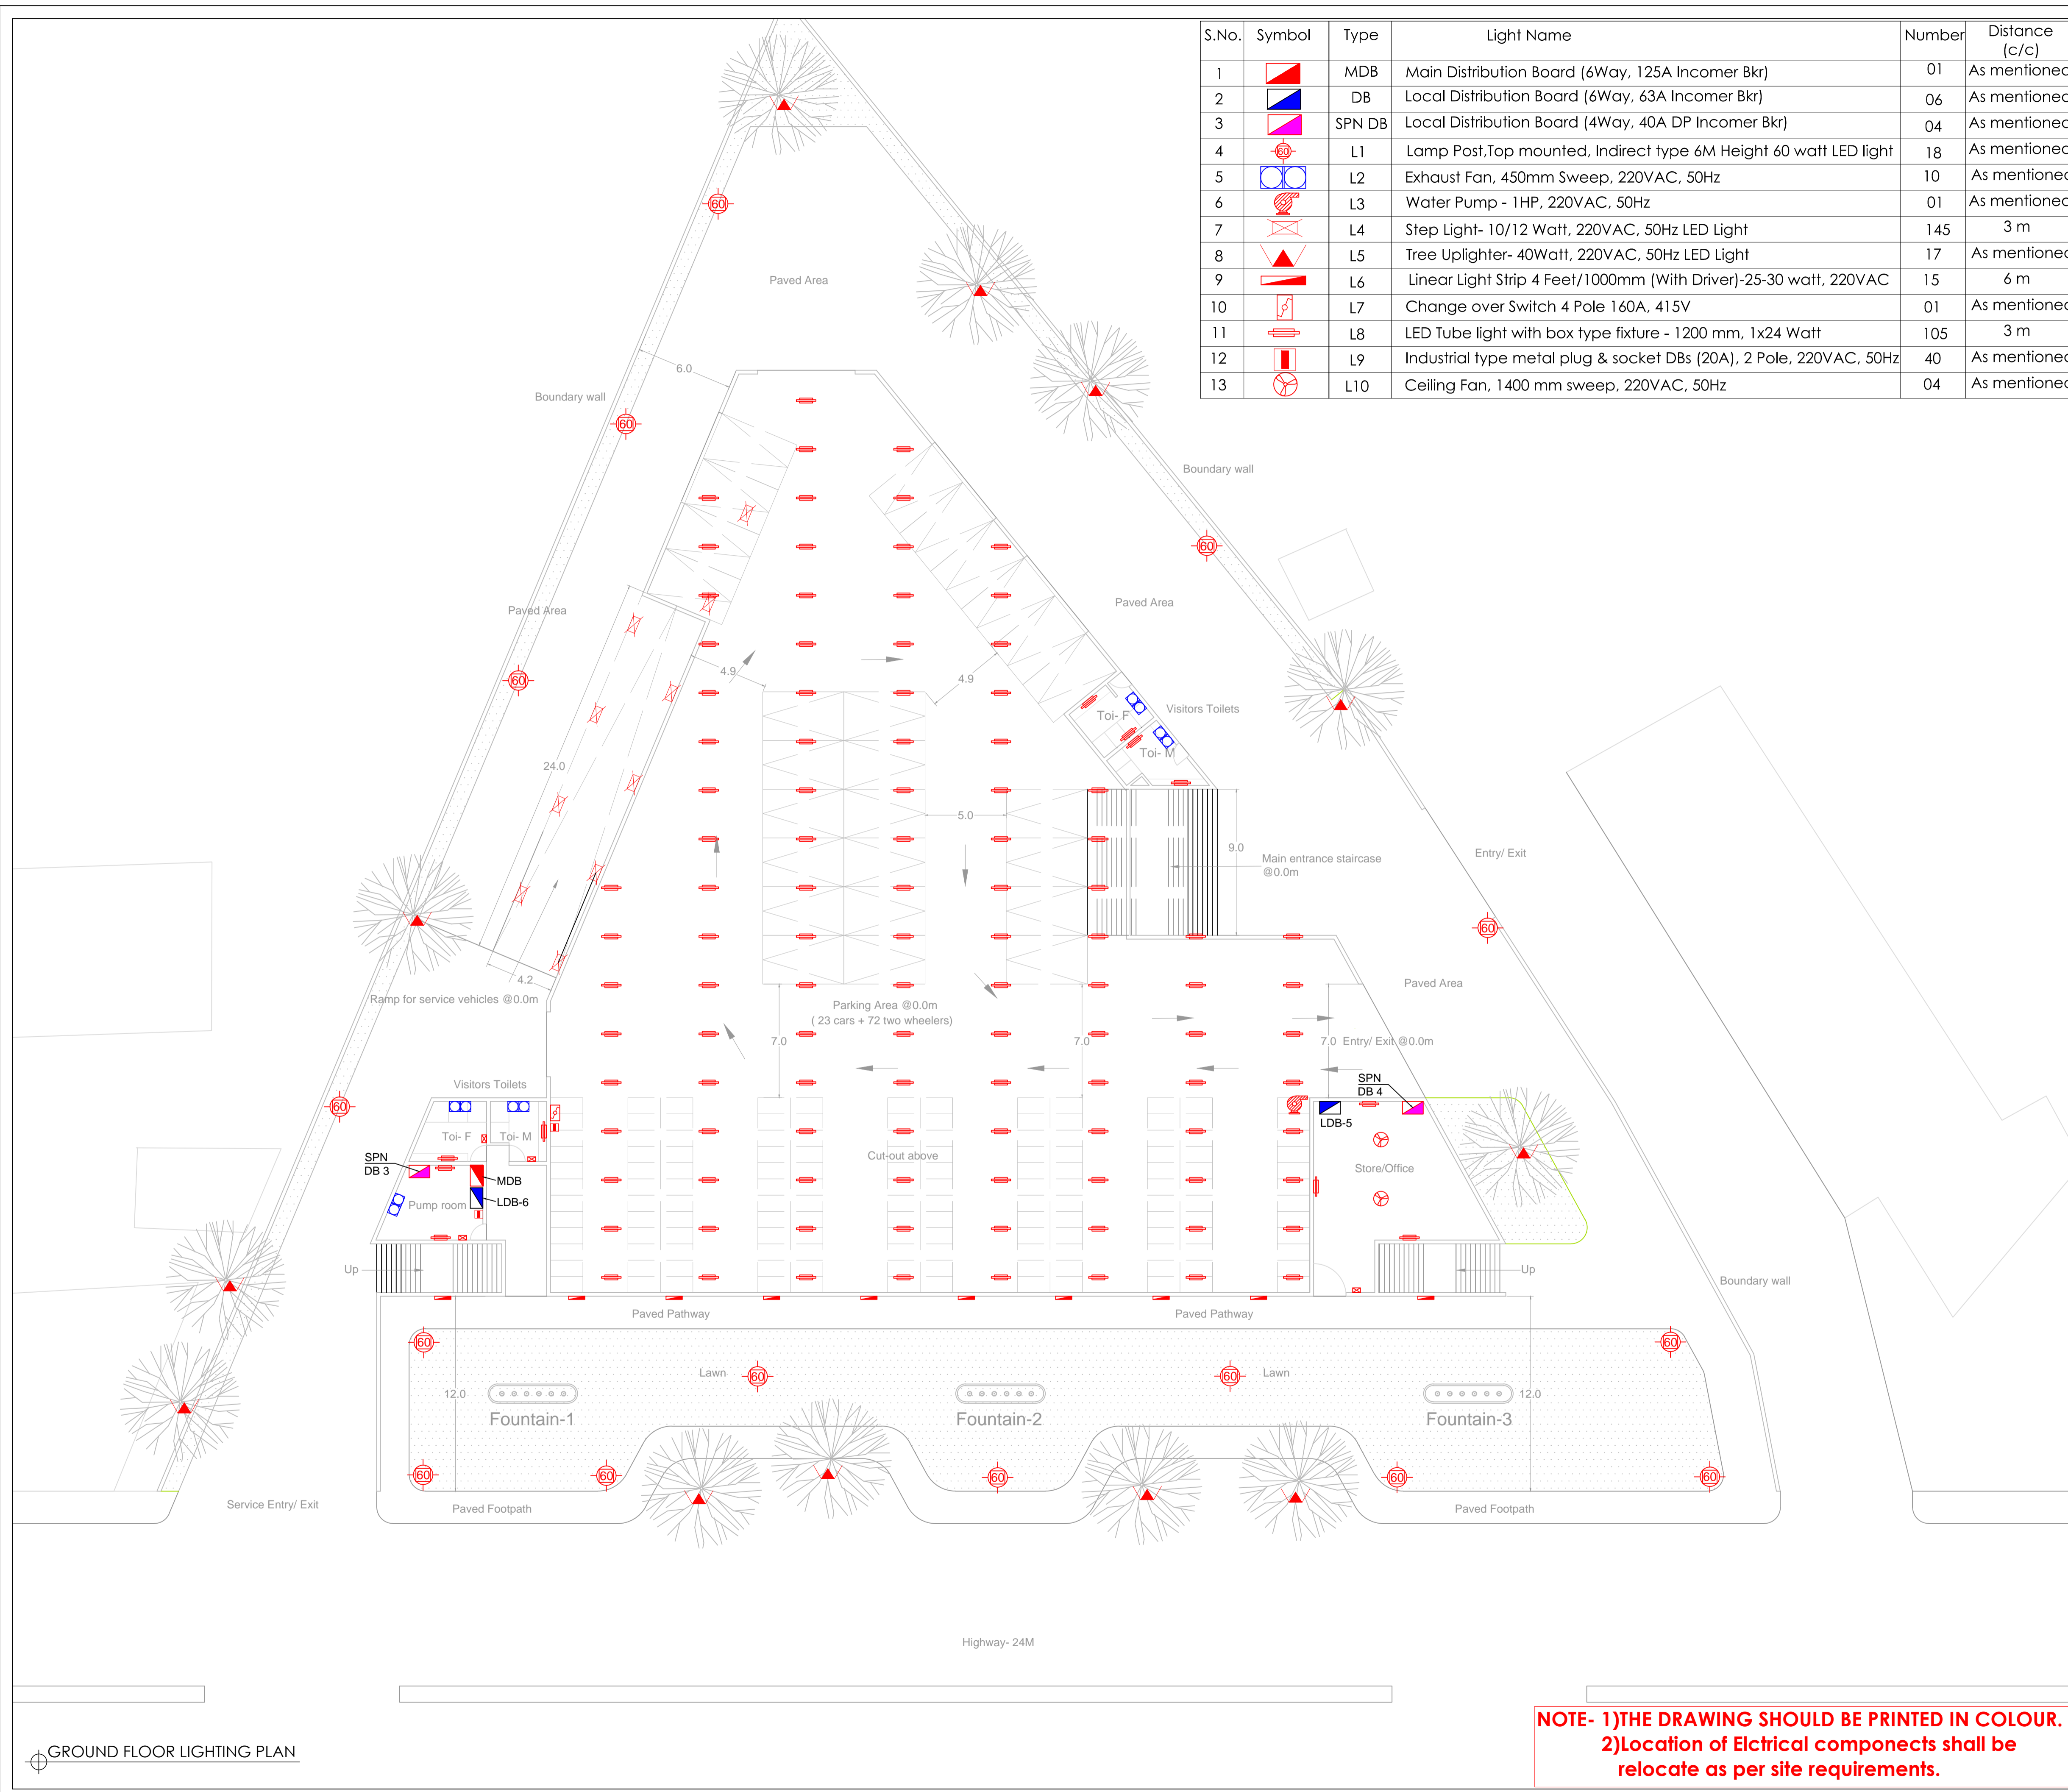

Key Plan

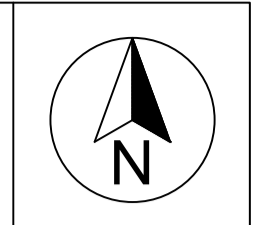

- General Notes:**
- All dimensions are in millimeters, if otherwise specified.
 - Dimensions are to be read and not to be scaled.
 - The contractors must verify all dimensions on site and refer the relevant structural and other MEP drawings before commencing any work, and in case any discrepancy is noticed the same shall be brought to the notice of the Consultant and shall be clarified before execution of work.
 - All survey carried out through visual study of the building and no destructive analysis has been carried out.
 - Refer this drawing along with the other relevant architectural, structural and MEP services drawings.

Legends

Client
Jabalpur Smart City Limited



Submitted by
IPE GLOBAL
IPE GLOBAL LIMITED
B-84, Defence Colony, New Delhi -110024

Project
**COMMUNITY MARRIAGE HALL,
GARHA, JABALPUR**

Sub-project

Rev.	Date	Description	Approved

Revision Index

Drawing Title

Ground Floor lighting plan


<input checked="" type="checkbox"/> For Tender	Date August 13, 2019	Drawn PB
<input type="checkbox"/> For Information	Scale	Checked MMK
<input type="checkbox"/> For Execution	Sheet Size A1	Approved MMK

Dwg. No.
IPE/JSCL/CMH/EP/01

Revision

**NOTE- 1)THE DRAWING SHOULD BE PRINTED IN COLOUR.
2)Location of Electrical componects shall be relocate as per site requirements.**


S.No.	Symbol	Type	Light Name	Number	Distance (c/c)
1		MDB	Main Distribution Board (6Way, 125A Incomer Bkr)	01	As mentioned
2		DB	Local Distribution Board (6Way, 63A Incomer Bkr)	06	As mentioned
3		SPN DB	Local Distribution Board (4Way, 40A DP Incomer Bkr)	04	As mentioned
4		L1	Lamp Post, Top mounted, Indirect type 6M Height 60 watt LED light	18	As mentioned
5		L2	Exhaust Fan, 450mm Sweep, 220VAC, 50Hz	10	As mentioned
6		L3	Water Pump - 1HP, 220VAC, 50Hz	01	As mentioned
7		L4	Step Light- 10/12 Watt, 220VAC, 50Hz LED Light	145	3 m
8		L5	Tree Uplighter- 40Watt, 220VAC, 50Hz LED Light	17	As mentioned
9		L6	Linear Light Strip 4 Feet/1000mm (With Driver)-25-30 watt, 220VAC	15	6 m
10		L7	Change over Switch 4 Pole 160A, 415V	01	As mentioned
11		L8	LED Tube light with box type fixture - 1200 mm, 1x24 Watt	105	3 m
12		L9	Industrial type metal plug & socket DBs (20A), 2 Pole, 220VAC, 50Hz	40	As mentioned
13		L10	Ceiling Fan, 1400 mm sweep, 220VAC, 50Hz	04	As mentioned

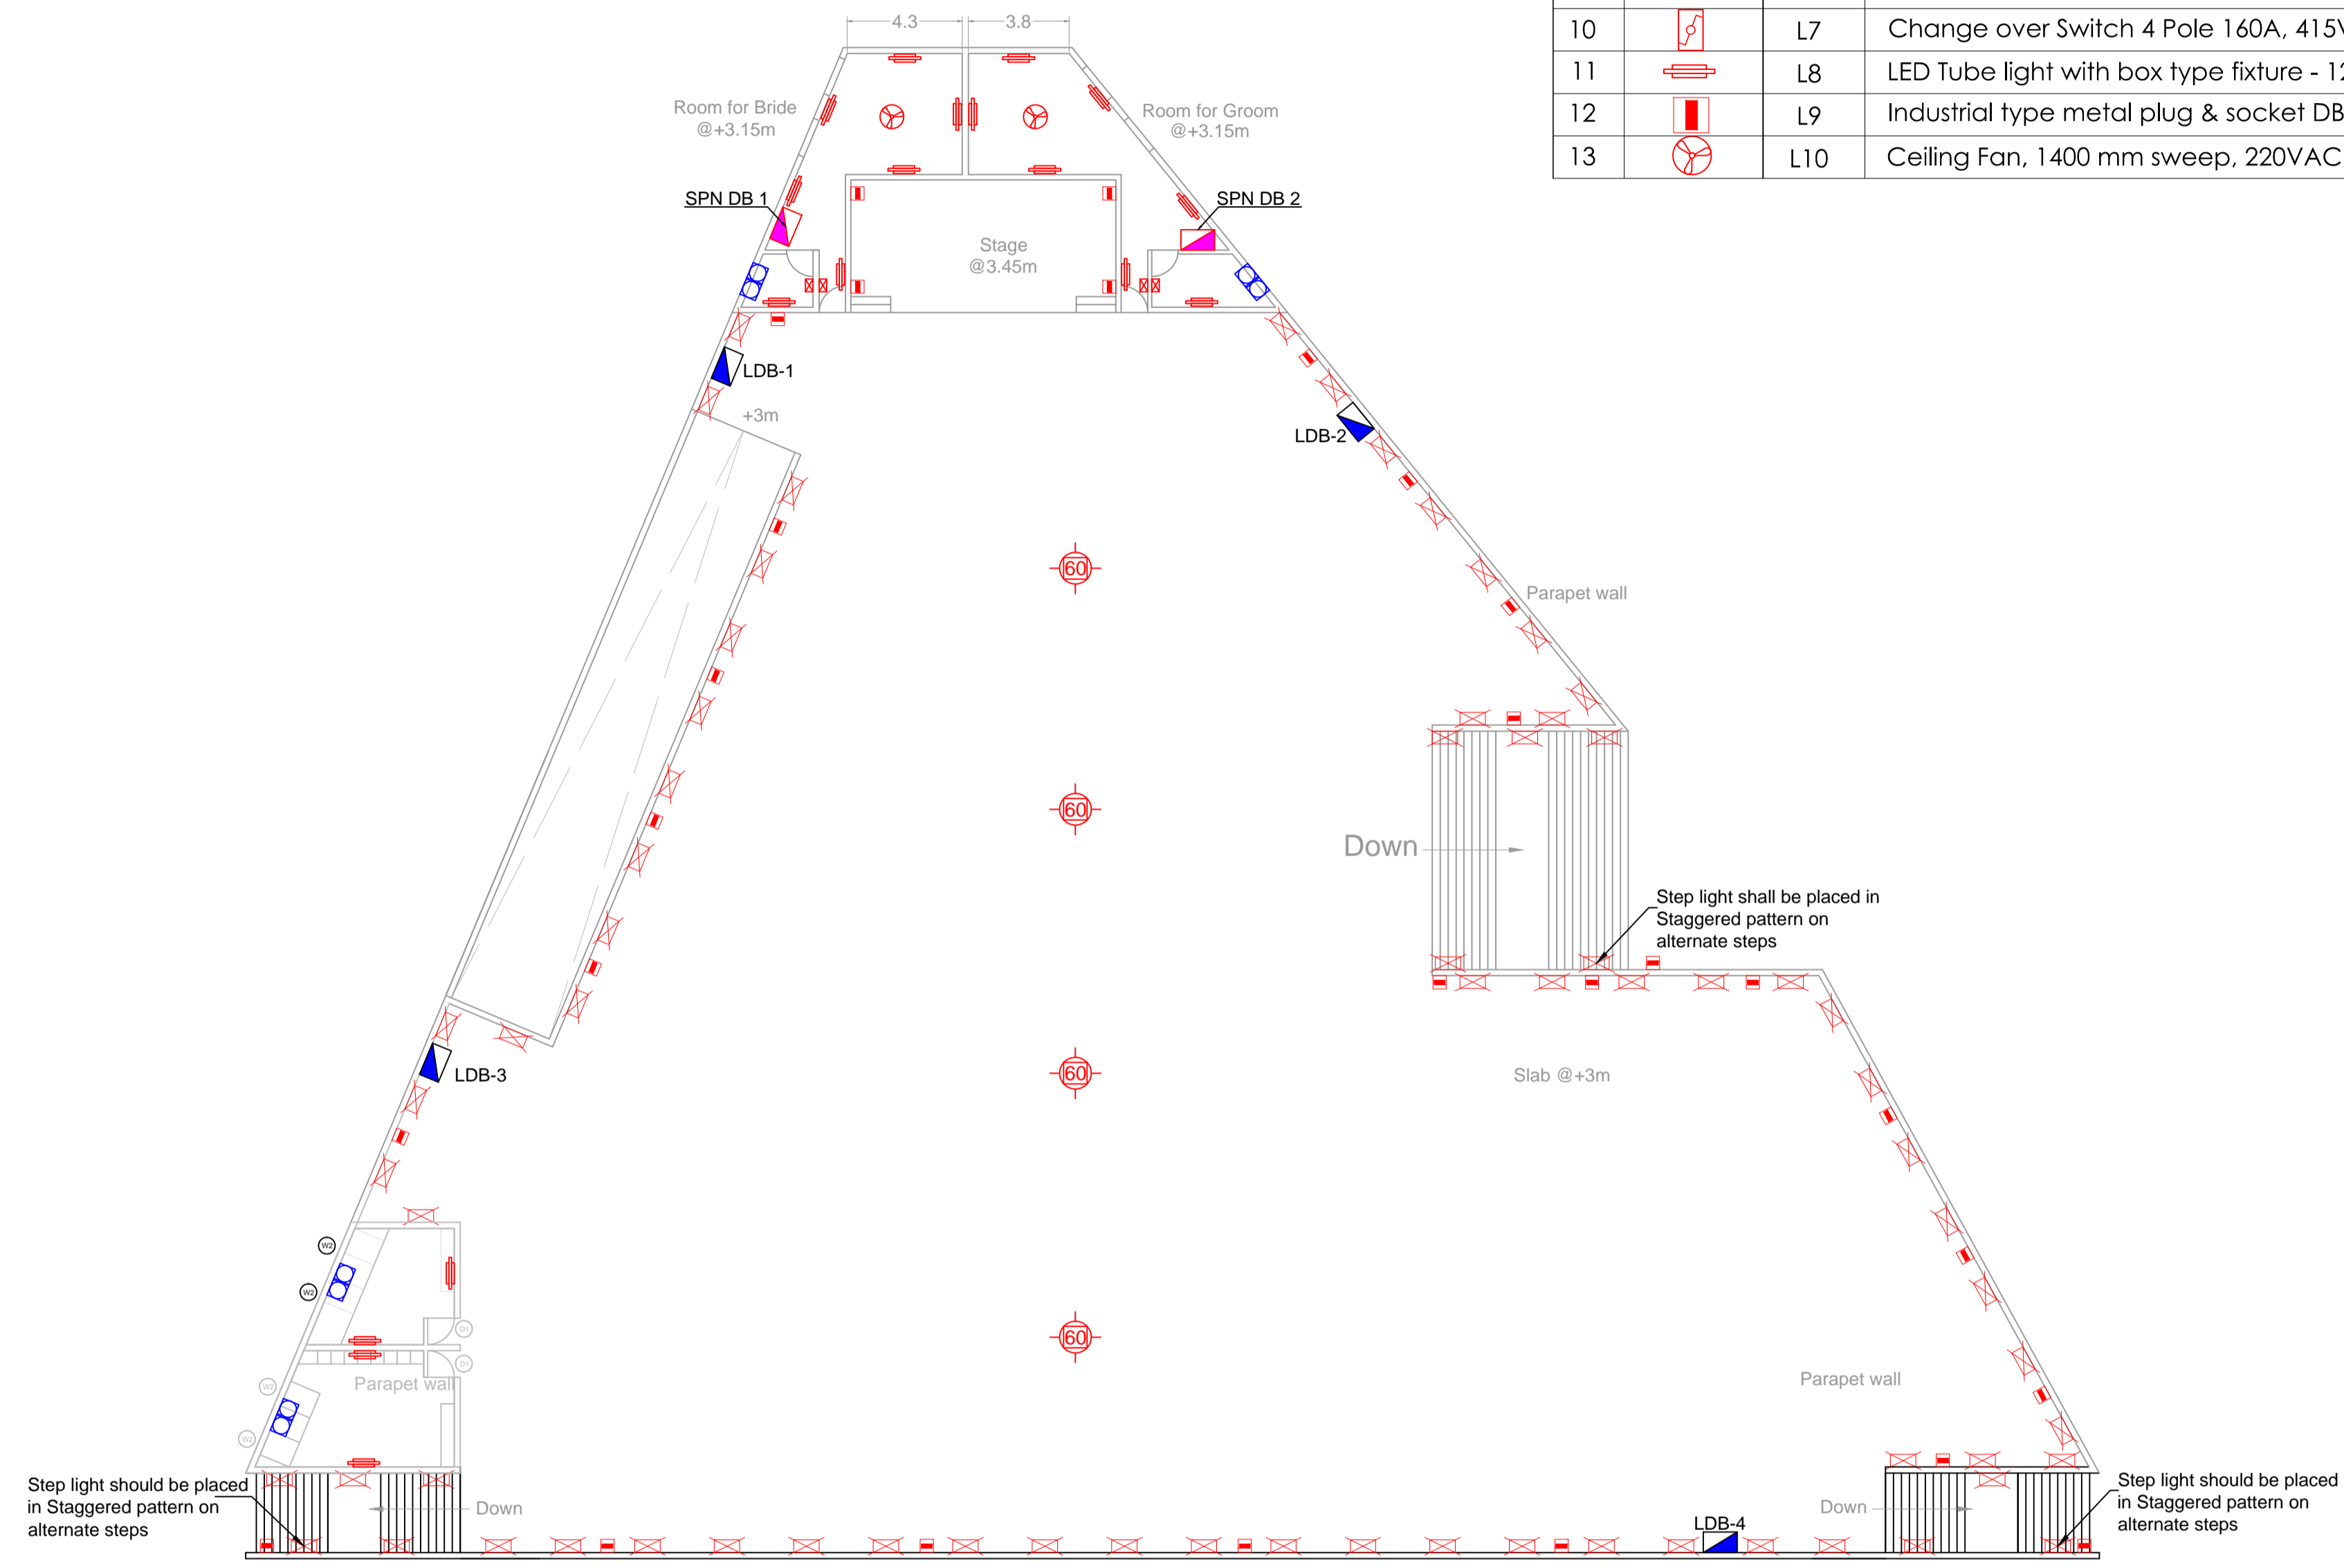

FIRST FLOOR PLAN

**NOTE- 1)THE DRAWING SHOULD BE PRINTED IN COLOUR.
2)Location of Elctrical componects shall be relocate as per site requirements.**

Key Plan

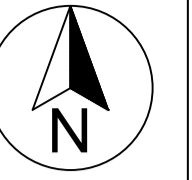

- General Notes:**
- All dimensions are in millimeters, if otherwise specified.
 - Dimensions are to be read and not to be scaled.
 - The contractors must verify all dimensions on site and refer the relevant structural and other MEP drawings before commencing any work, and in case any discrepancy is noticed the same shall be brought to the notice of the Consultant and shall be clarified before execution of work.
 - All survey carried out through visual study of the building and no destructive analysis has been carried out.
 - Refer this drawing along with the other relevant architectural, structural and MEP services drawings.

Legends

Client
Jabalpur Smart City Limited

Submitted by
IFE GLOBAL
IFE GLOBAL LIMITED
B-84, Defence Colony, New Delhi -110024

Project
**COMMUNITY MARRIAGE HALL,
GARHA, JABALPUR**

Sub-project

Rev.	Date	Description	Approved

Revision Index



Drawing Title

Ground Floor lighting plan

<input checked="" type="checkbox"/> For Tender	Date August 13, 2019	Drawn PB
<input type="checkbox"/> For Information	Scale	Checked MMK
<input type="checkbox"/> For Execution	Sheet Size A1	Approved MMK

Dwg. No. **IPE/JSCL/CMH/EP/03**

Revision

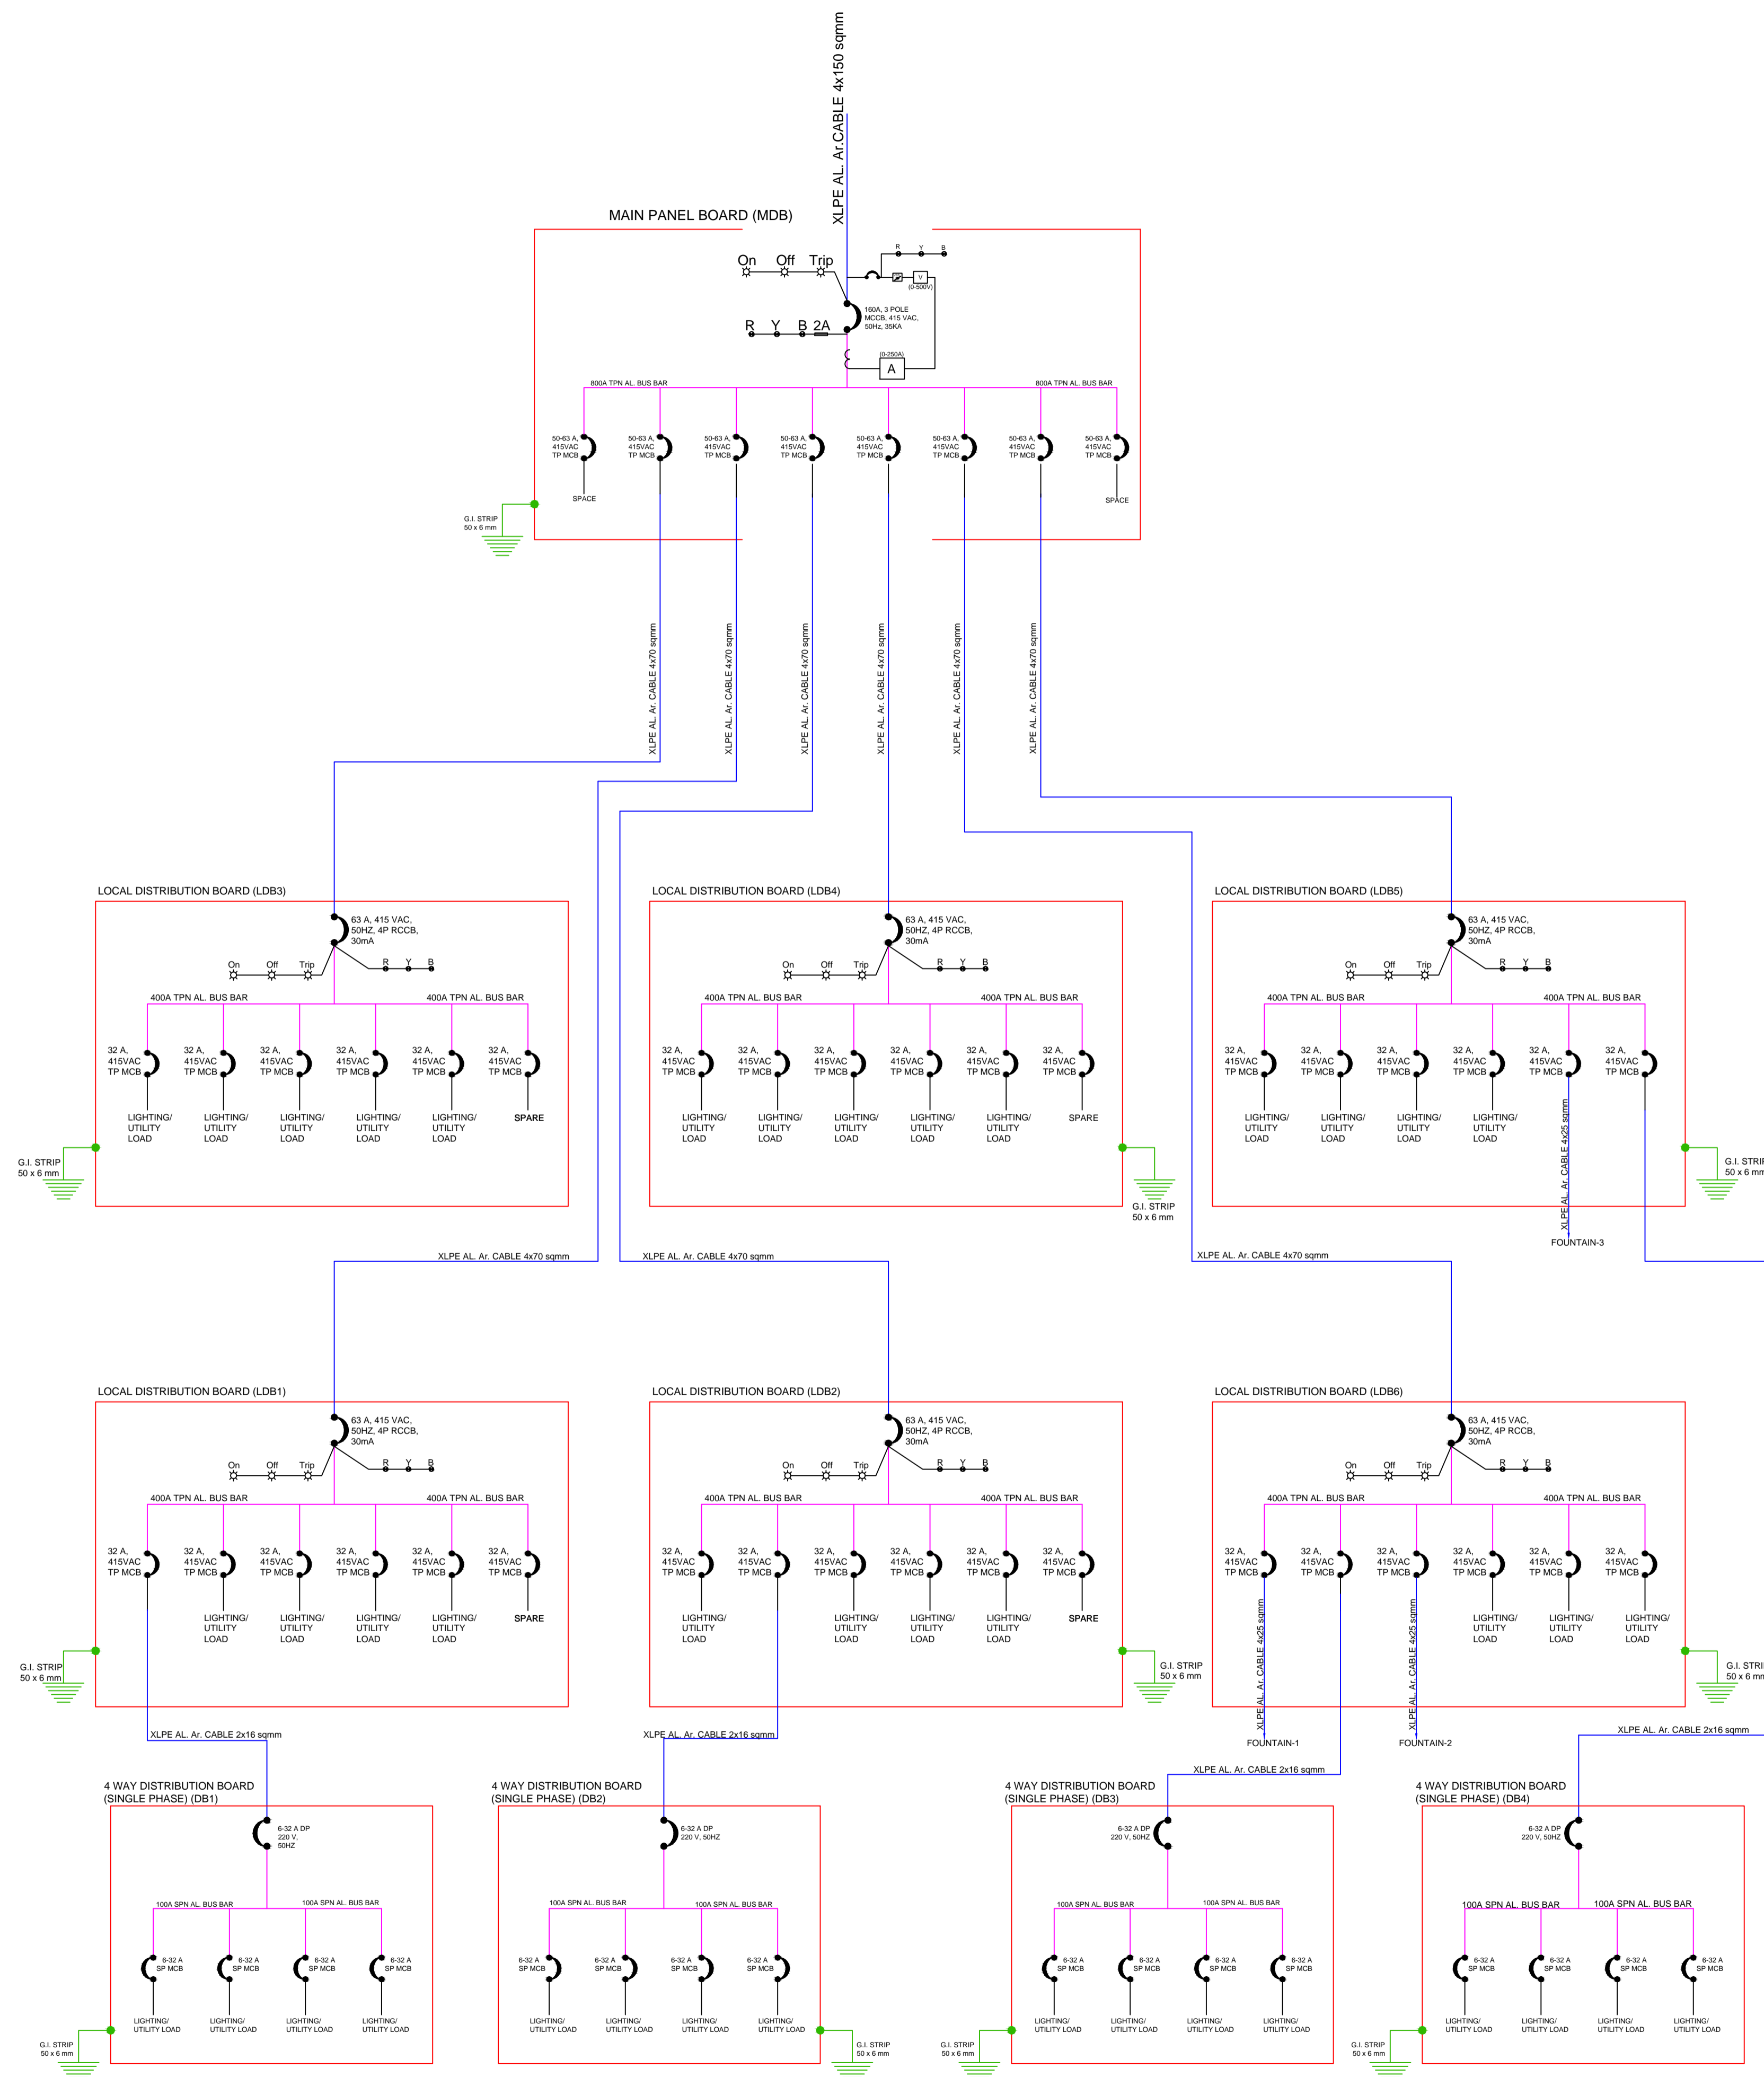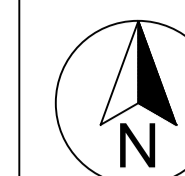

SINGLE LINE DIAGRAM

**NOTE- 1)THE DRAWING SHOULD BE PRINTED IN COLOUR.
2)Location of Elctrical componects shall be relocate as per site requirements.**

General Notes:

1. All dimensions are in millimeters, if otherwise specified.
2. Dimensions are to be read and not to be scaled.
3. The contractors must verify all dimensions on site and refer the relevant structural and other MEP drawings before commencing any work, and in case any discrepancy is noticed the same shall be brought to the notice of the Consultant and shall be clarified before execution of work.
4. All survey carried out through visual study of the building and no destructive analysis has been carried out.
5. Refer this drawing along with the other relevant architectural, structural and MEP services drawings.

Legends

Client

Jabalpur Smart City Limited



Submitted by

IPE GLOBAL
IPE GLOBAL LIMITED
B-84, Defence Colony, New Delhi-110024

Project

**COMMUNITY MARRIAGE HALL,
GARHA, JABALPUR**

Sub-project

Rev.	Date	Description	Approved


Revision Index

Drawing Title


Single line diagram for lighting plan

<input checked="" type="checkbox"/> For Tender <input type="checkbox"/> For Information <input type="checkbox"/> For Execution	Date	Drawn
	August 13, 2019	PB
Scale	Sheet Size	Checked
1:500	A1	MMK
		Approved
		MMK


Dwg. No.	Revision
IPE/JSCL/CMH/EP/02	

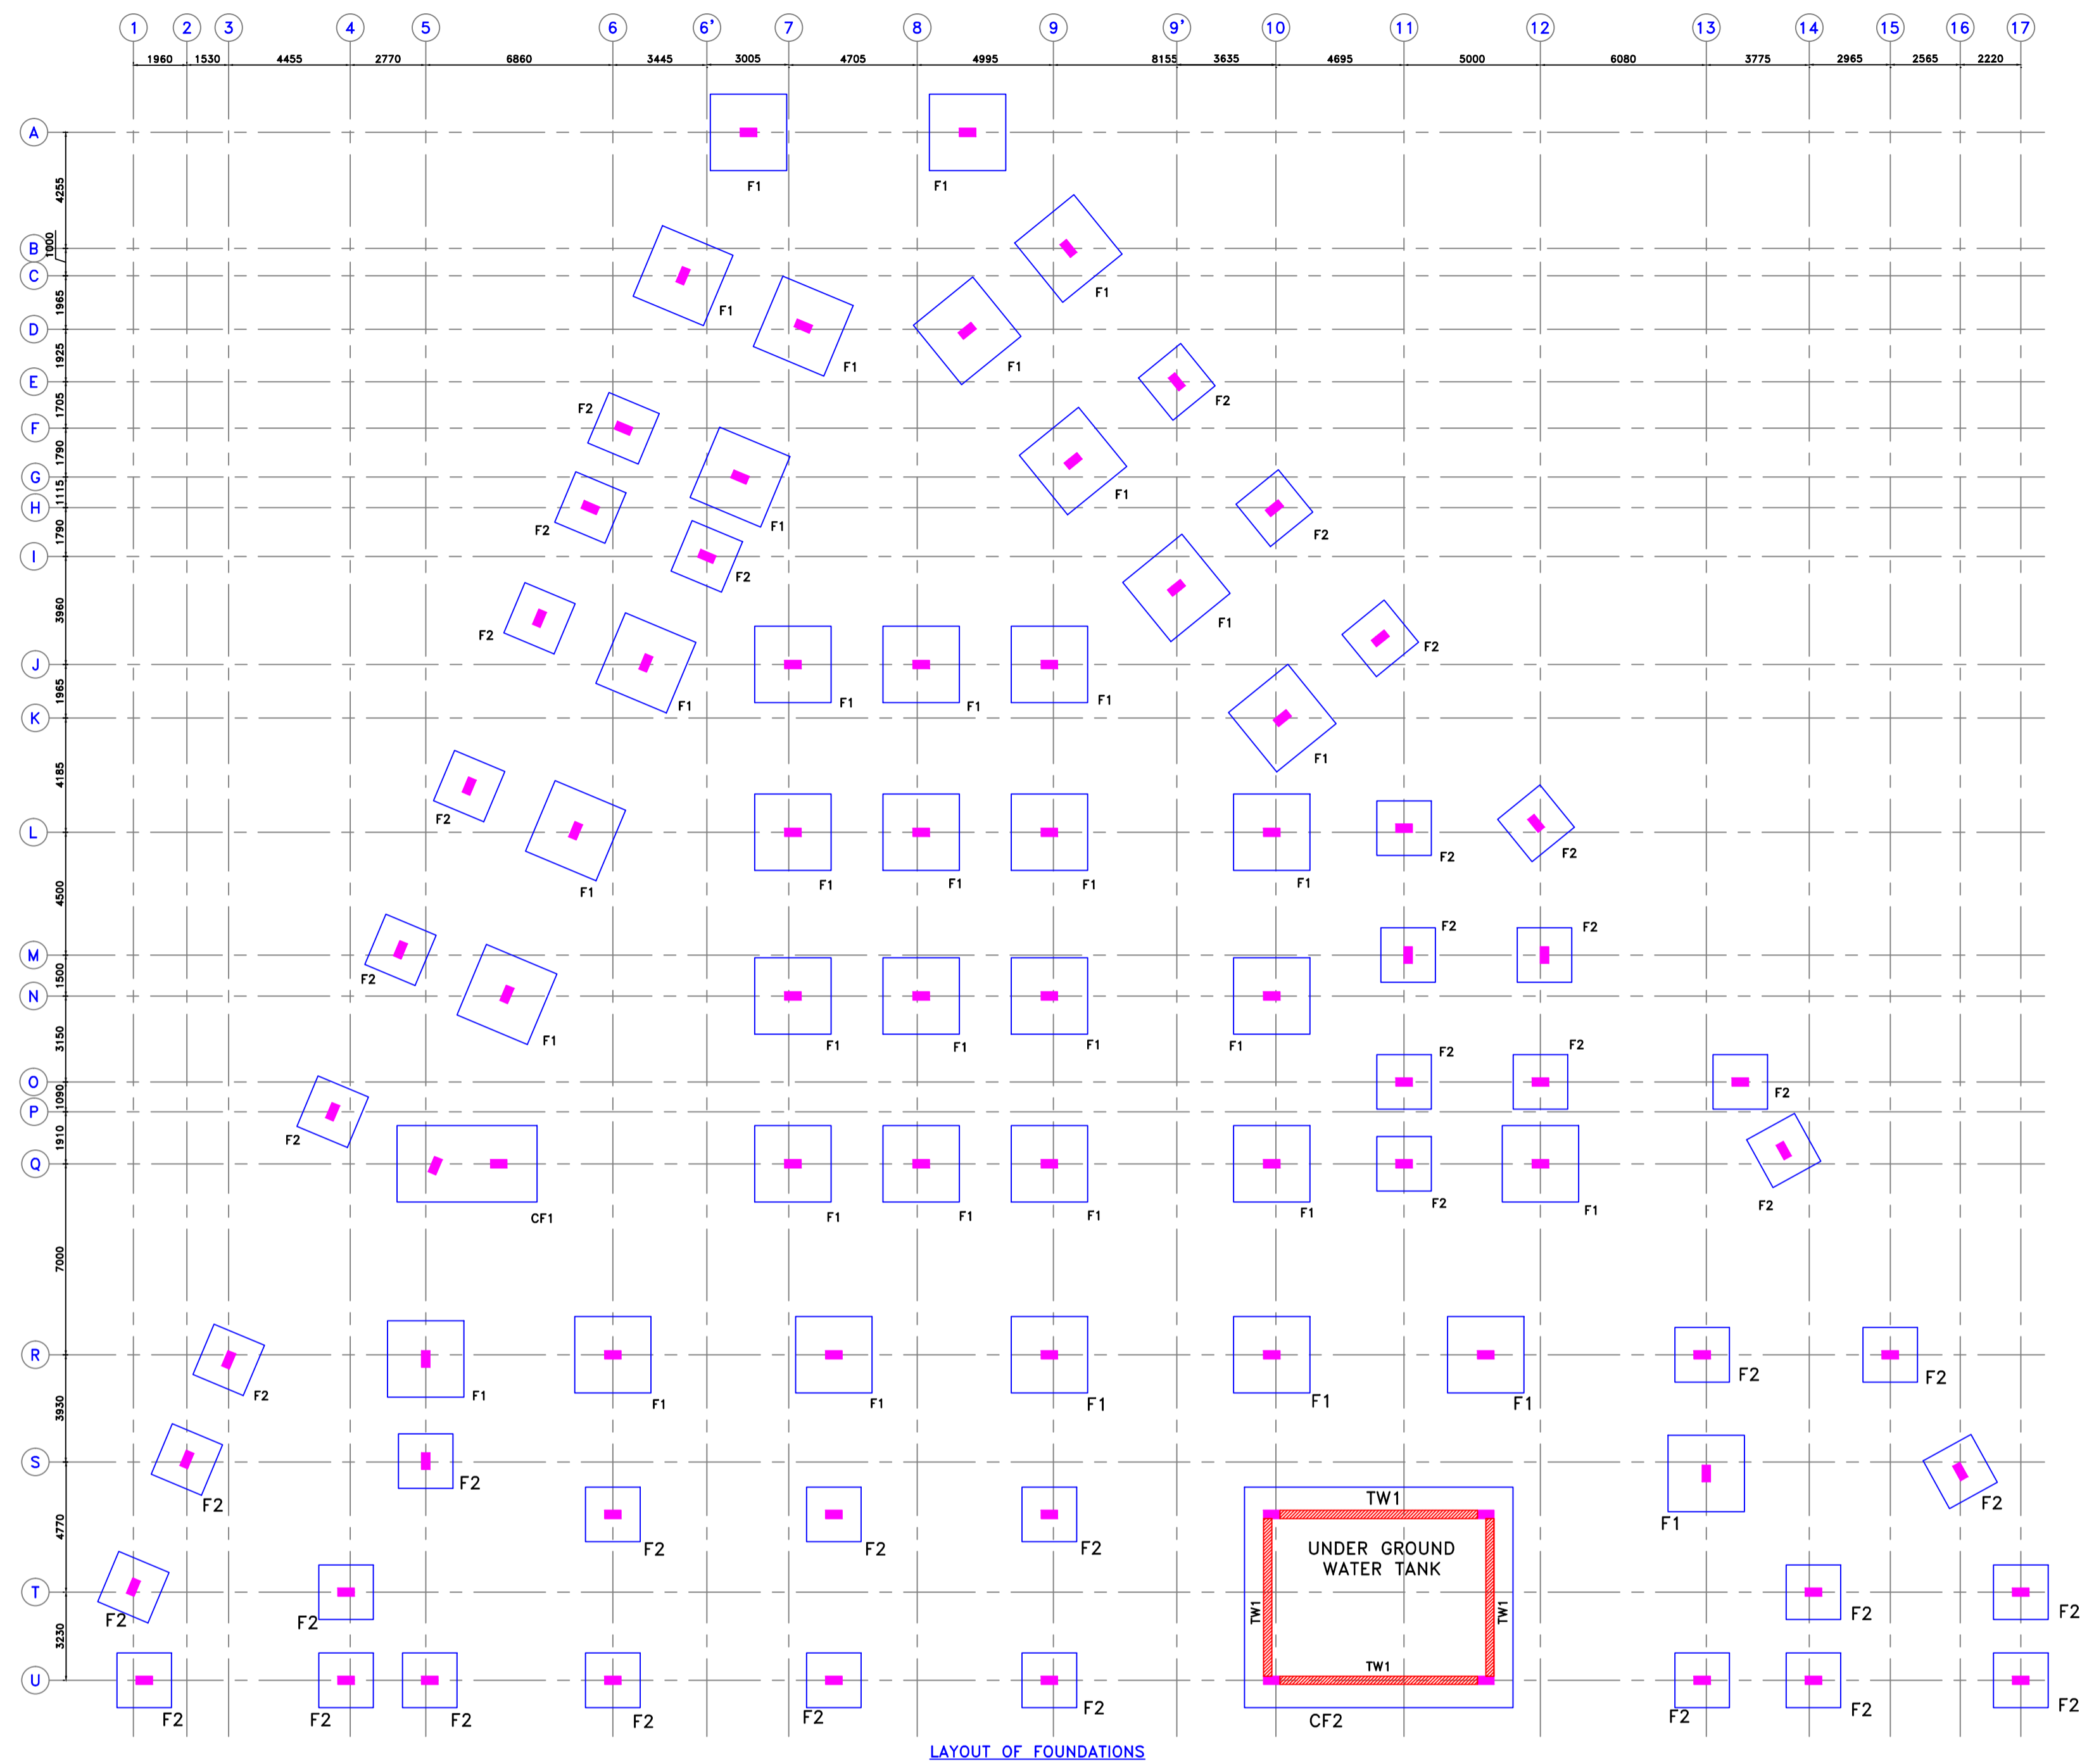

LAYOUT OF FOUNDATIONS

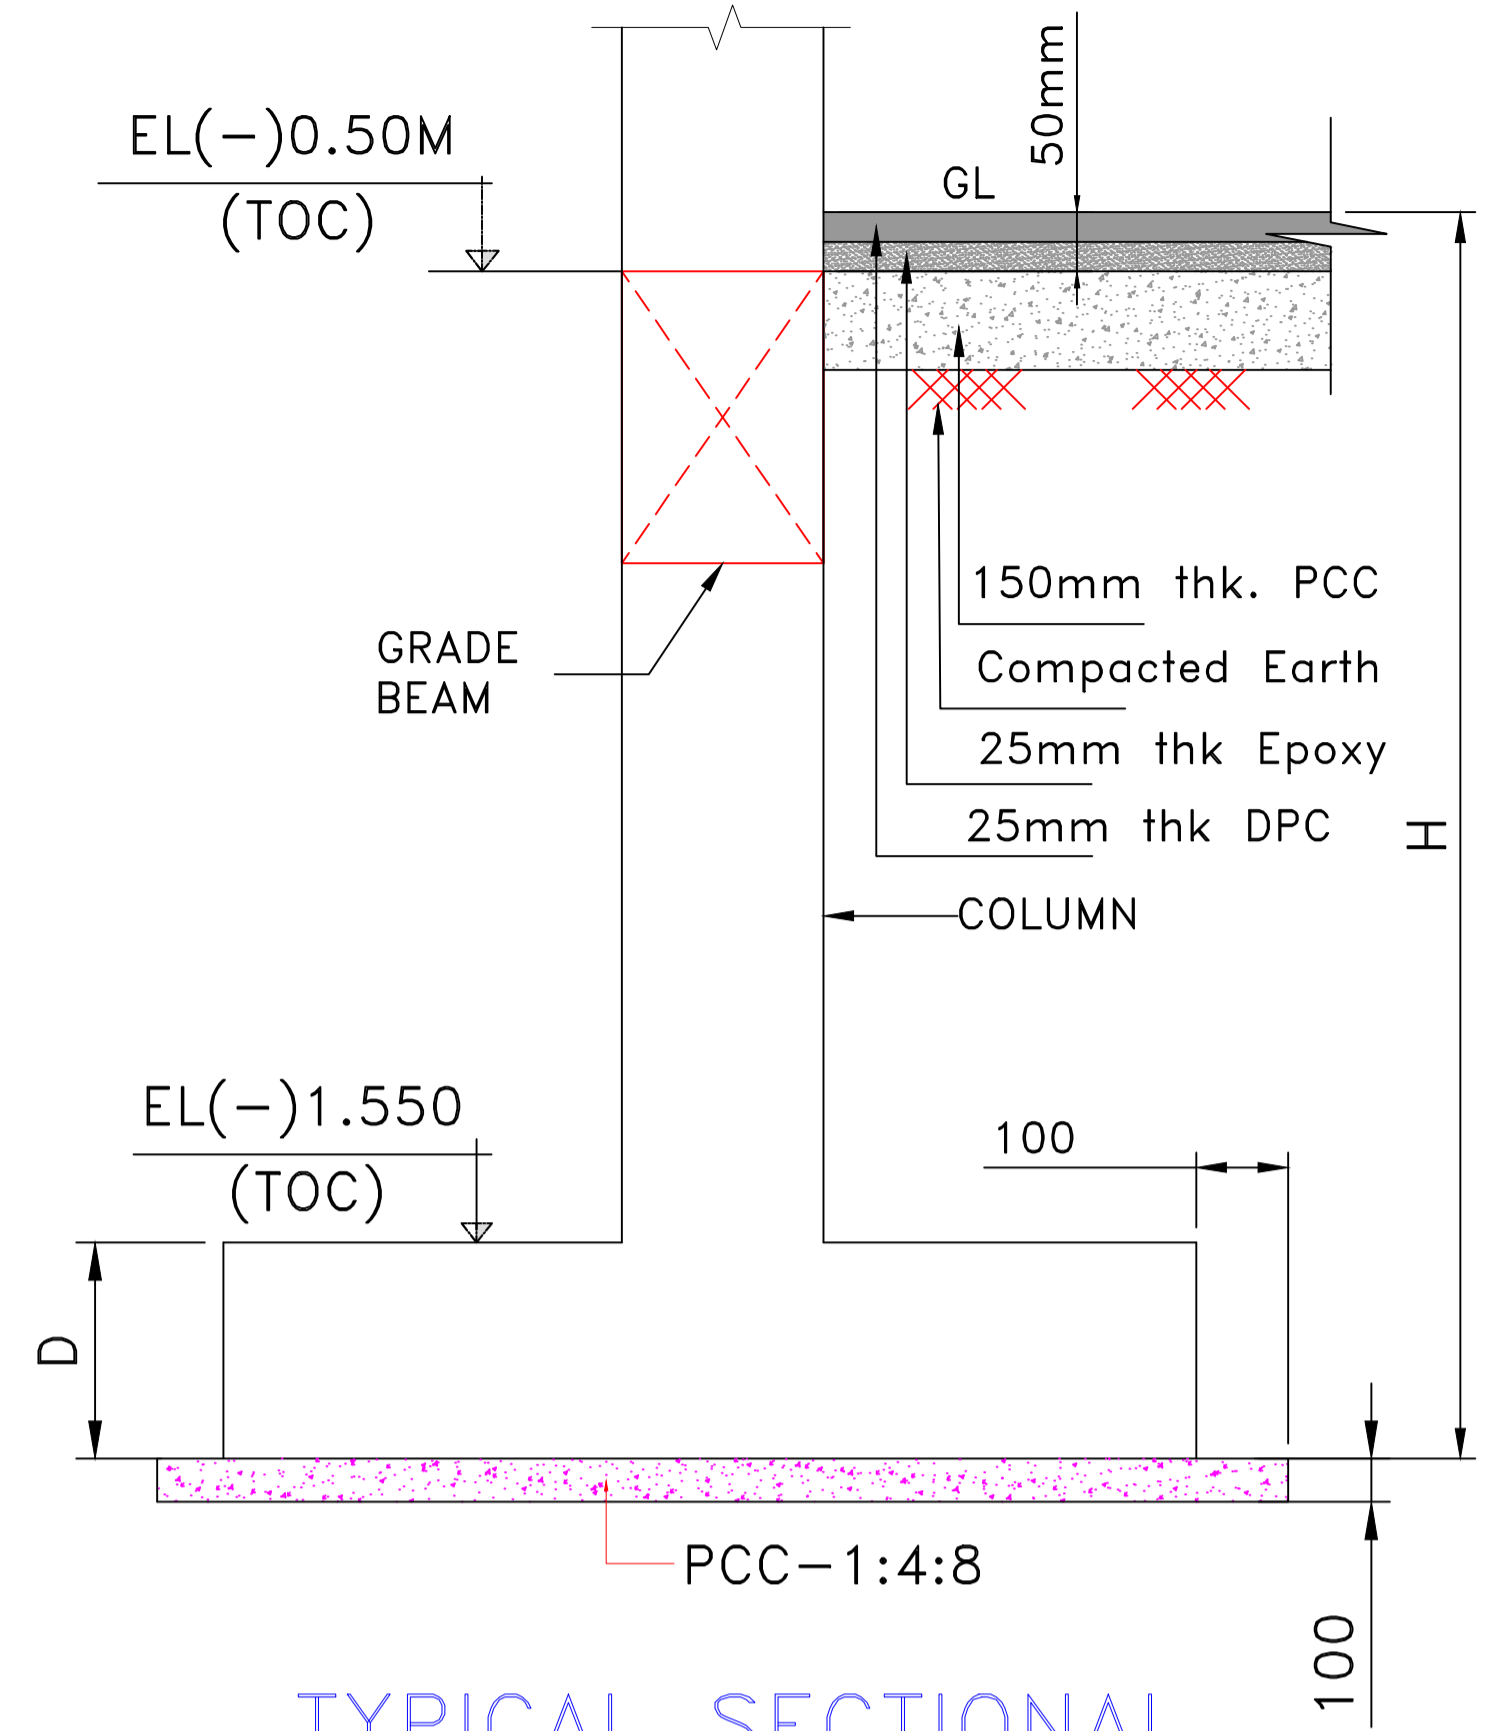


TYPICAL SECTIONAL DETAILS OF FOUNDATION

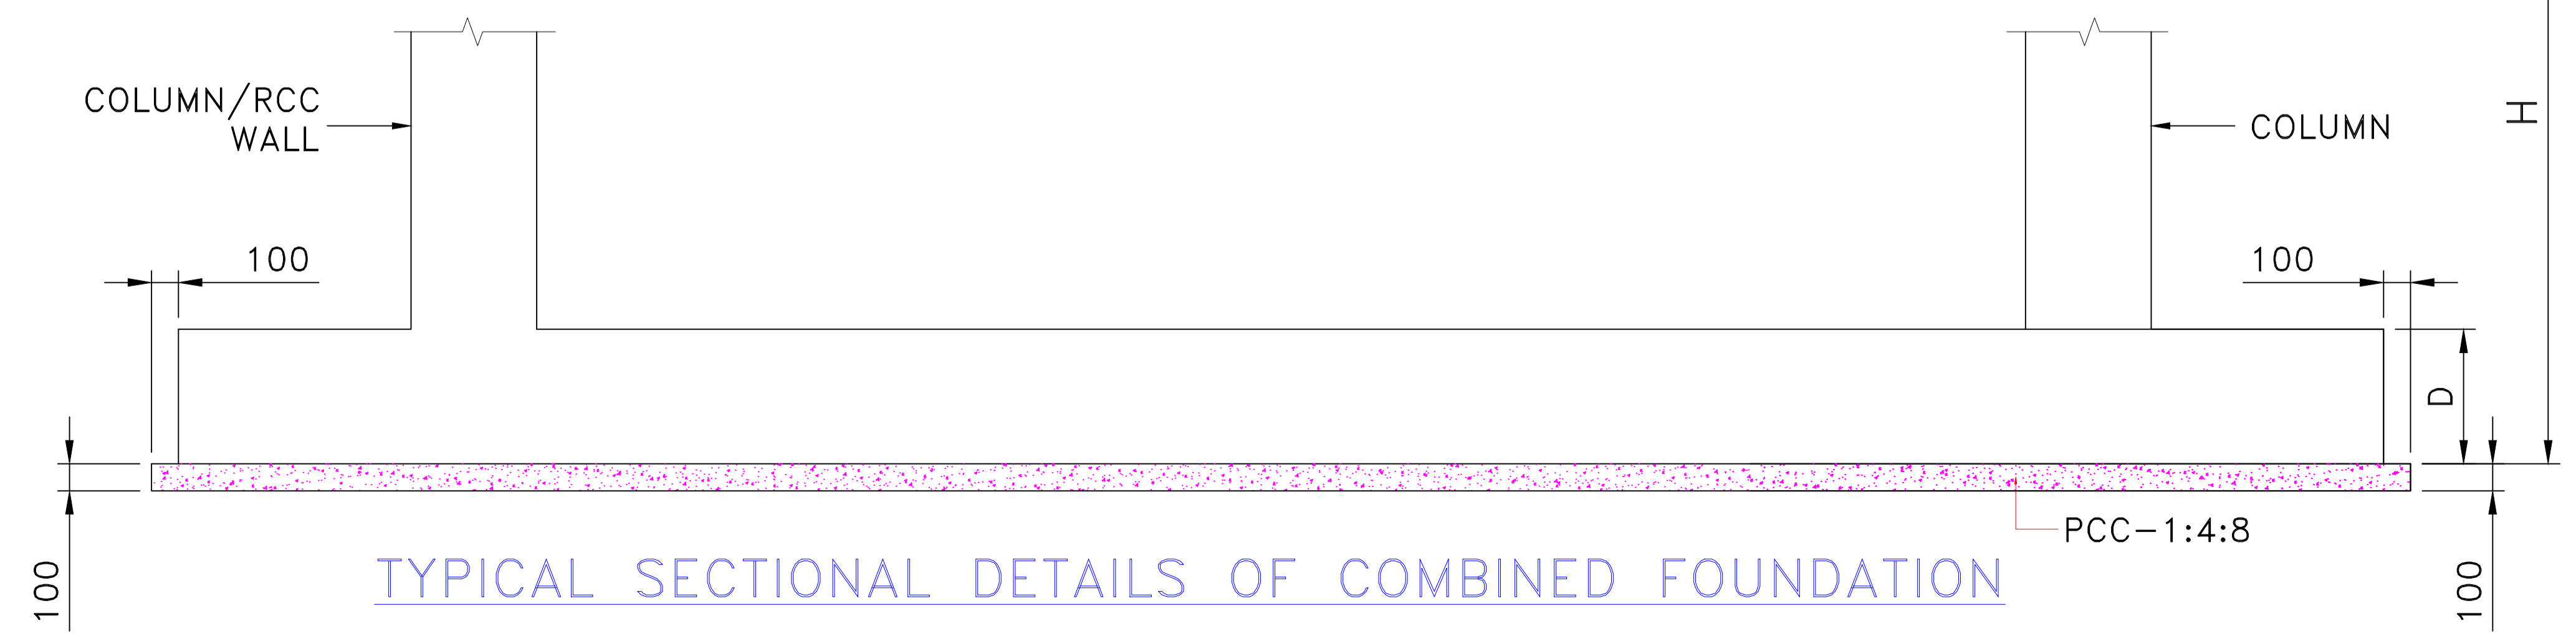

TYPICAL SECTIONAL DETAILS OF COMBINED FOUNDATION

FOUNDATION PLAN

Key Plan

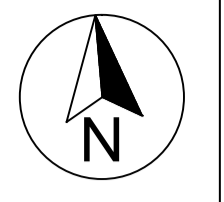

General Notes:

- All dimensions are in millimeters, if otherwise specified.
- Dimensions are to be read and not to be scaled.
- The contractors must verify all dimensions on site and refer the relevant structural and other MEP drawings before commencing any work, and in case any discrepancy is noticed the same shall be brought to the notice of the Consultant and shall be clarified before execution of work.
- All survey carried out through visual study of the building and no destructive analysis has been carried out.
- Refer this drawing along with the other relevant architectural, structural and MEP services drawings.

Legends

SCHEDULE OF FOUNDATIONS

FOOTING TYPE	NOS	FOOTING NO.	FOOTING SIZE (L x B x D)	FOOTING H
01	36	F1	2800 X 2800 X 600	2000
02	41	F2	2000 X 2000 X 600	2000
03	01	CF1	5130 X 2800 X 600	2000
04	01	CF2	9840 X 8080 X 600	2000

Client

Jabalpur Smart City Limited



Submitted by

IPE GLOBAL
IPE GLOBAL LIMITED
B-84, Defence Colony, New Delhi - 110024

Project

**COMMUNITY MARRIAGE HALL,
GARHA, JABALPUR**

Sub-project

Rev.	Date	Description	Approved



Revision Index

Drawing Title

Foundation plan

<input checked="" type="checkbox"/> For Tender <input type="checkbox"/> For Information <input type="checkbox"/> For Execution	Date	August 13, 2019	Drawn	PB
	Scale		Checked	SRK
	Sheet Size	A1	Approved	SRK

Dwg. No. **IPJ/JSCL/CMH/ST/01** Revision

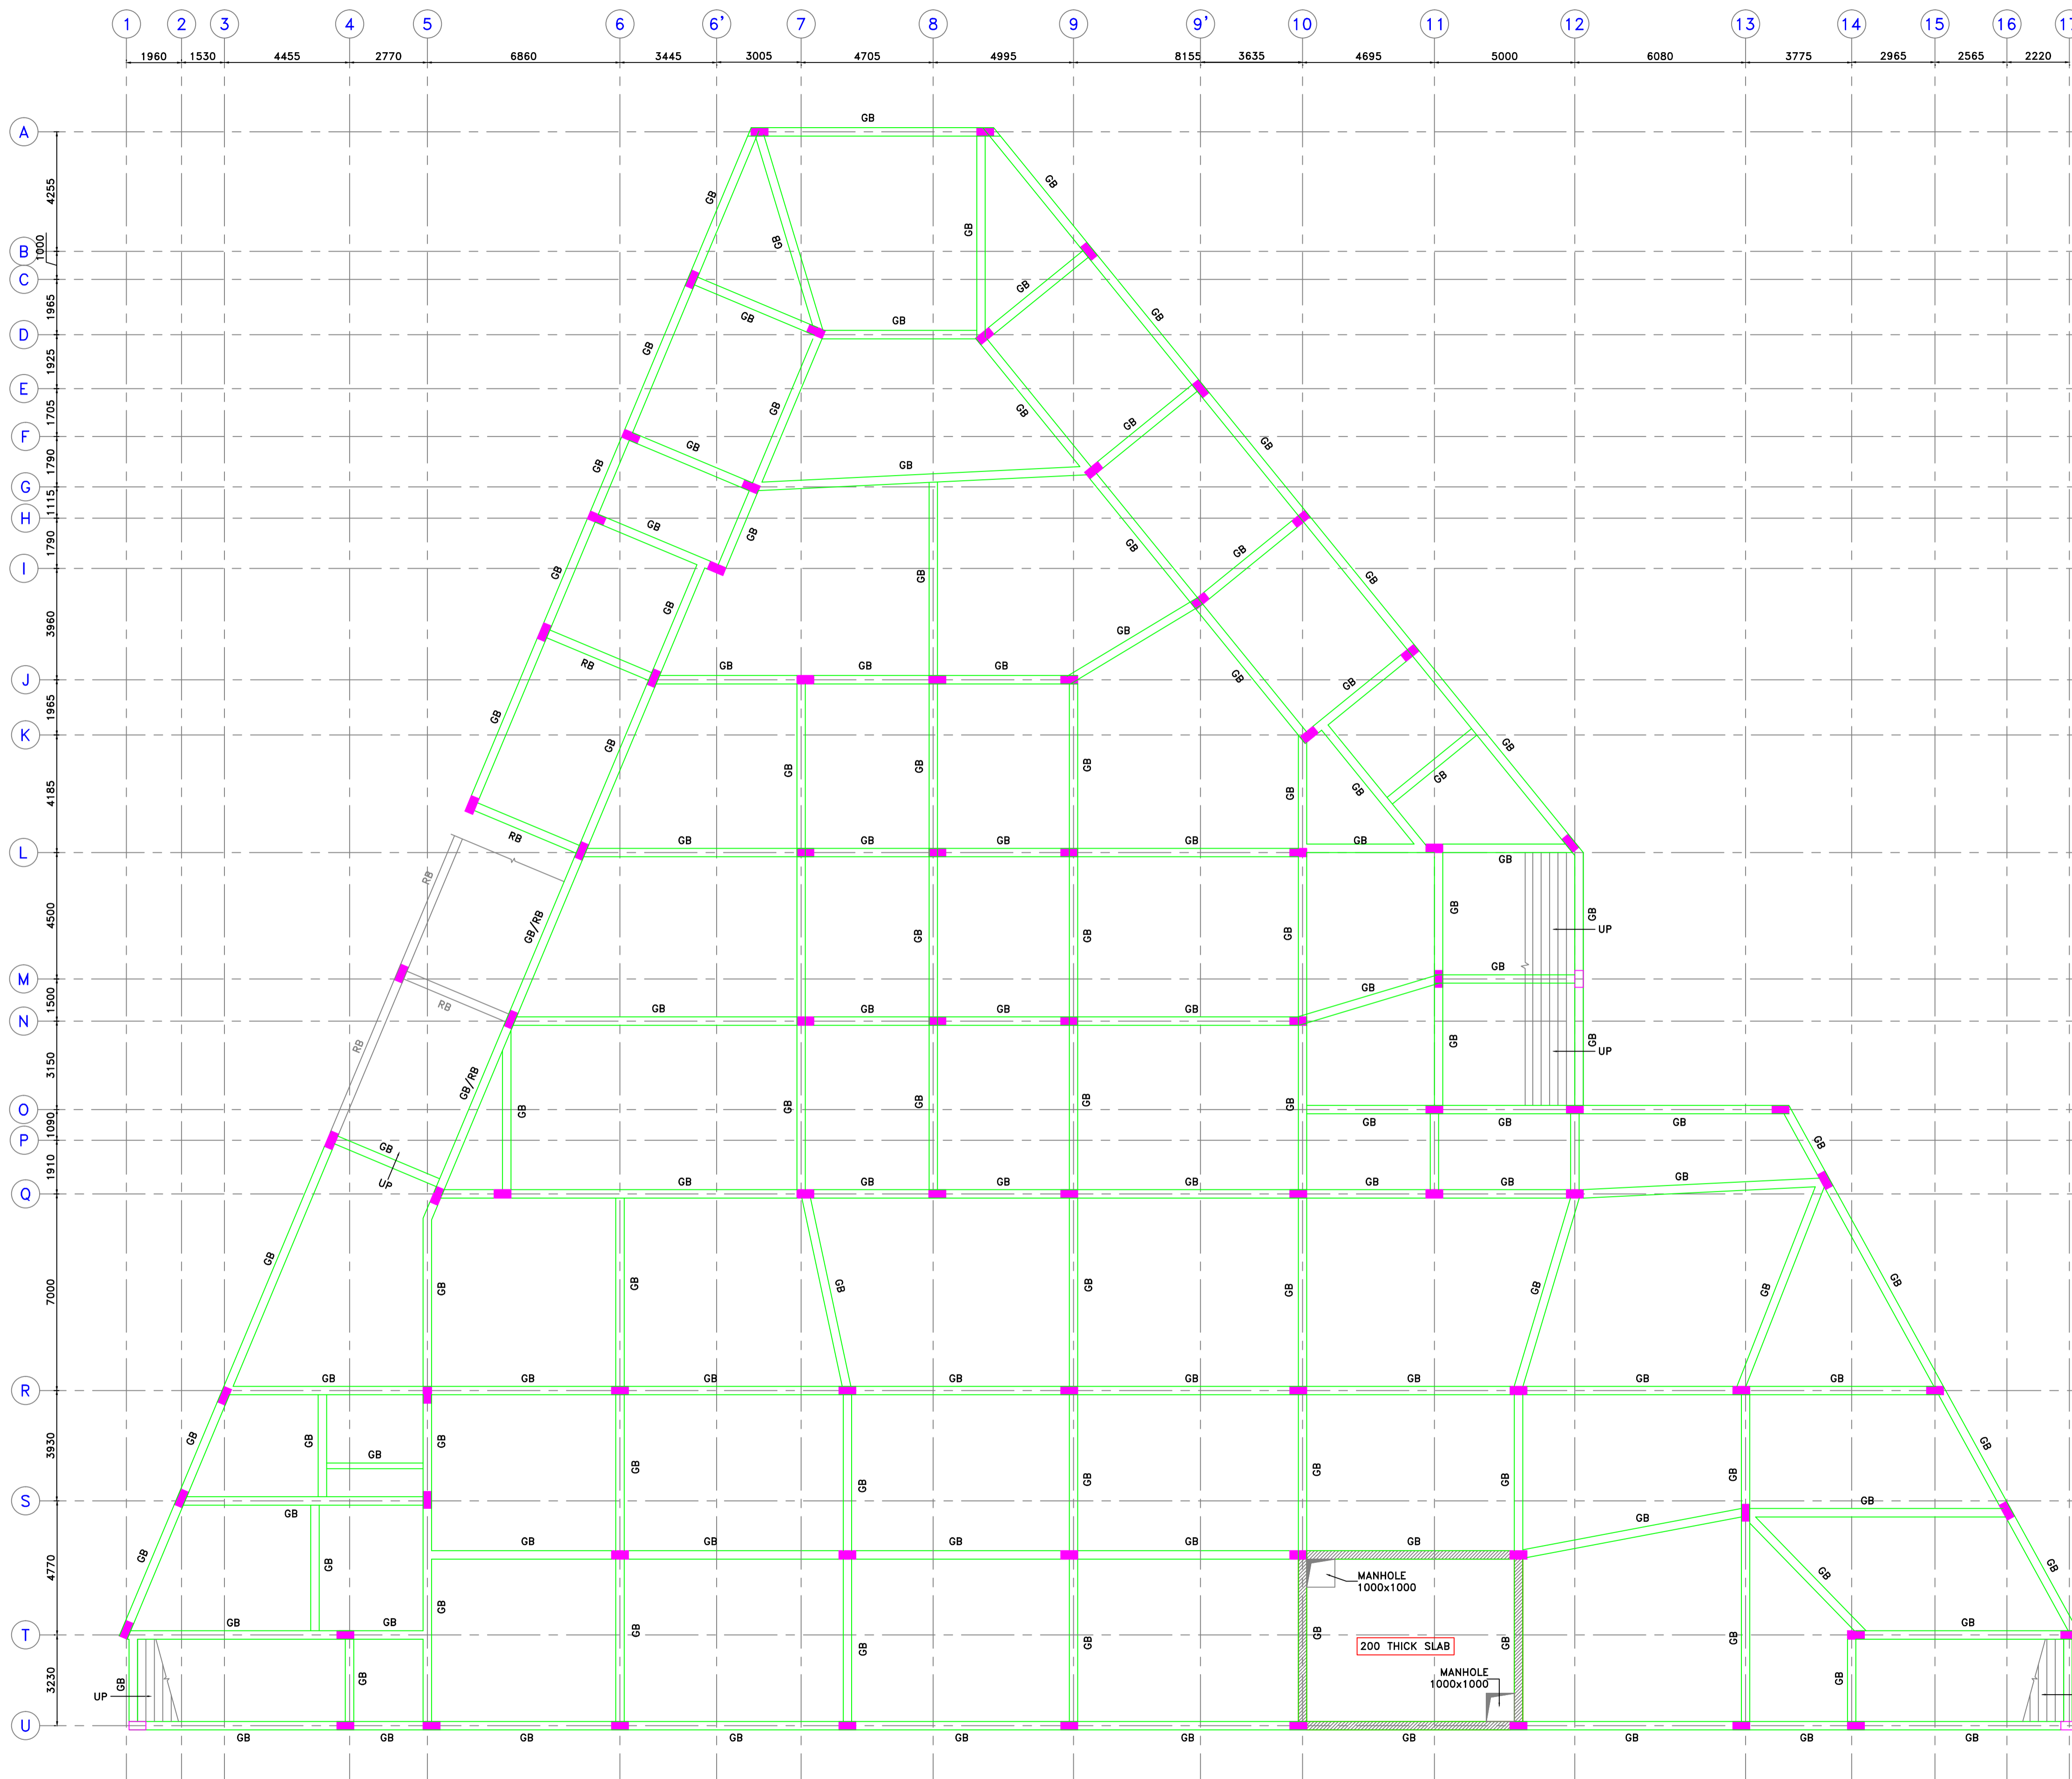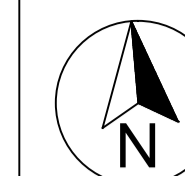

LAYOUT OF GROUND FLOOR LEVEL BEAMS AT EL(-)0.50M (TOC),UNO
ALL BEAMS ARE 300MM WIDE & 600MM DEEP

GROUND FLOOR BEAM PLAN

General Notes:

1. All dimensions are in millimeters, if otherwise specified.
2. Dimensions are to be read and not to be scaled.
3. The contractors must verify all dimensions on site and refer the relevant structural and other MEP drawings before commencing any work, and in case any discrepancy is noticed the same shall be brought to the notice of the Consultant and shall be clarified before execution of work.
4. All survey carried out through visual study of the building and no destructive analysis has been carried out.
5. Refer this drawing along with the other relevant architectural, structural and MEP services drawings.

Legends

Client

Jabalpur Smart City Limited



Submitted by

IPE GLOBAL
IPE GLOBAL LIMITED
B-84, Defence Colony, New Delhi - 110024

Project

**COMMUNITY MARRIAGE HALL,
GARHA, JABALPUR**

Sub-project

Rev.	Date	Description	Approved

Revision Index

Drawing Title


Ground Floor Beam plan

<input checked="" type="checkbox"/> For Tender <input type="checkbox"/> For Information <input type="checkbox"/> For Execution	Date	July 10, 2019	Drawn PB
	Scale		Checked SRK
	Sheet Size	A1	Approved SRK

Dwg. No.


ipe/jscl/cmh/st/03

Revision

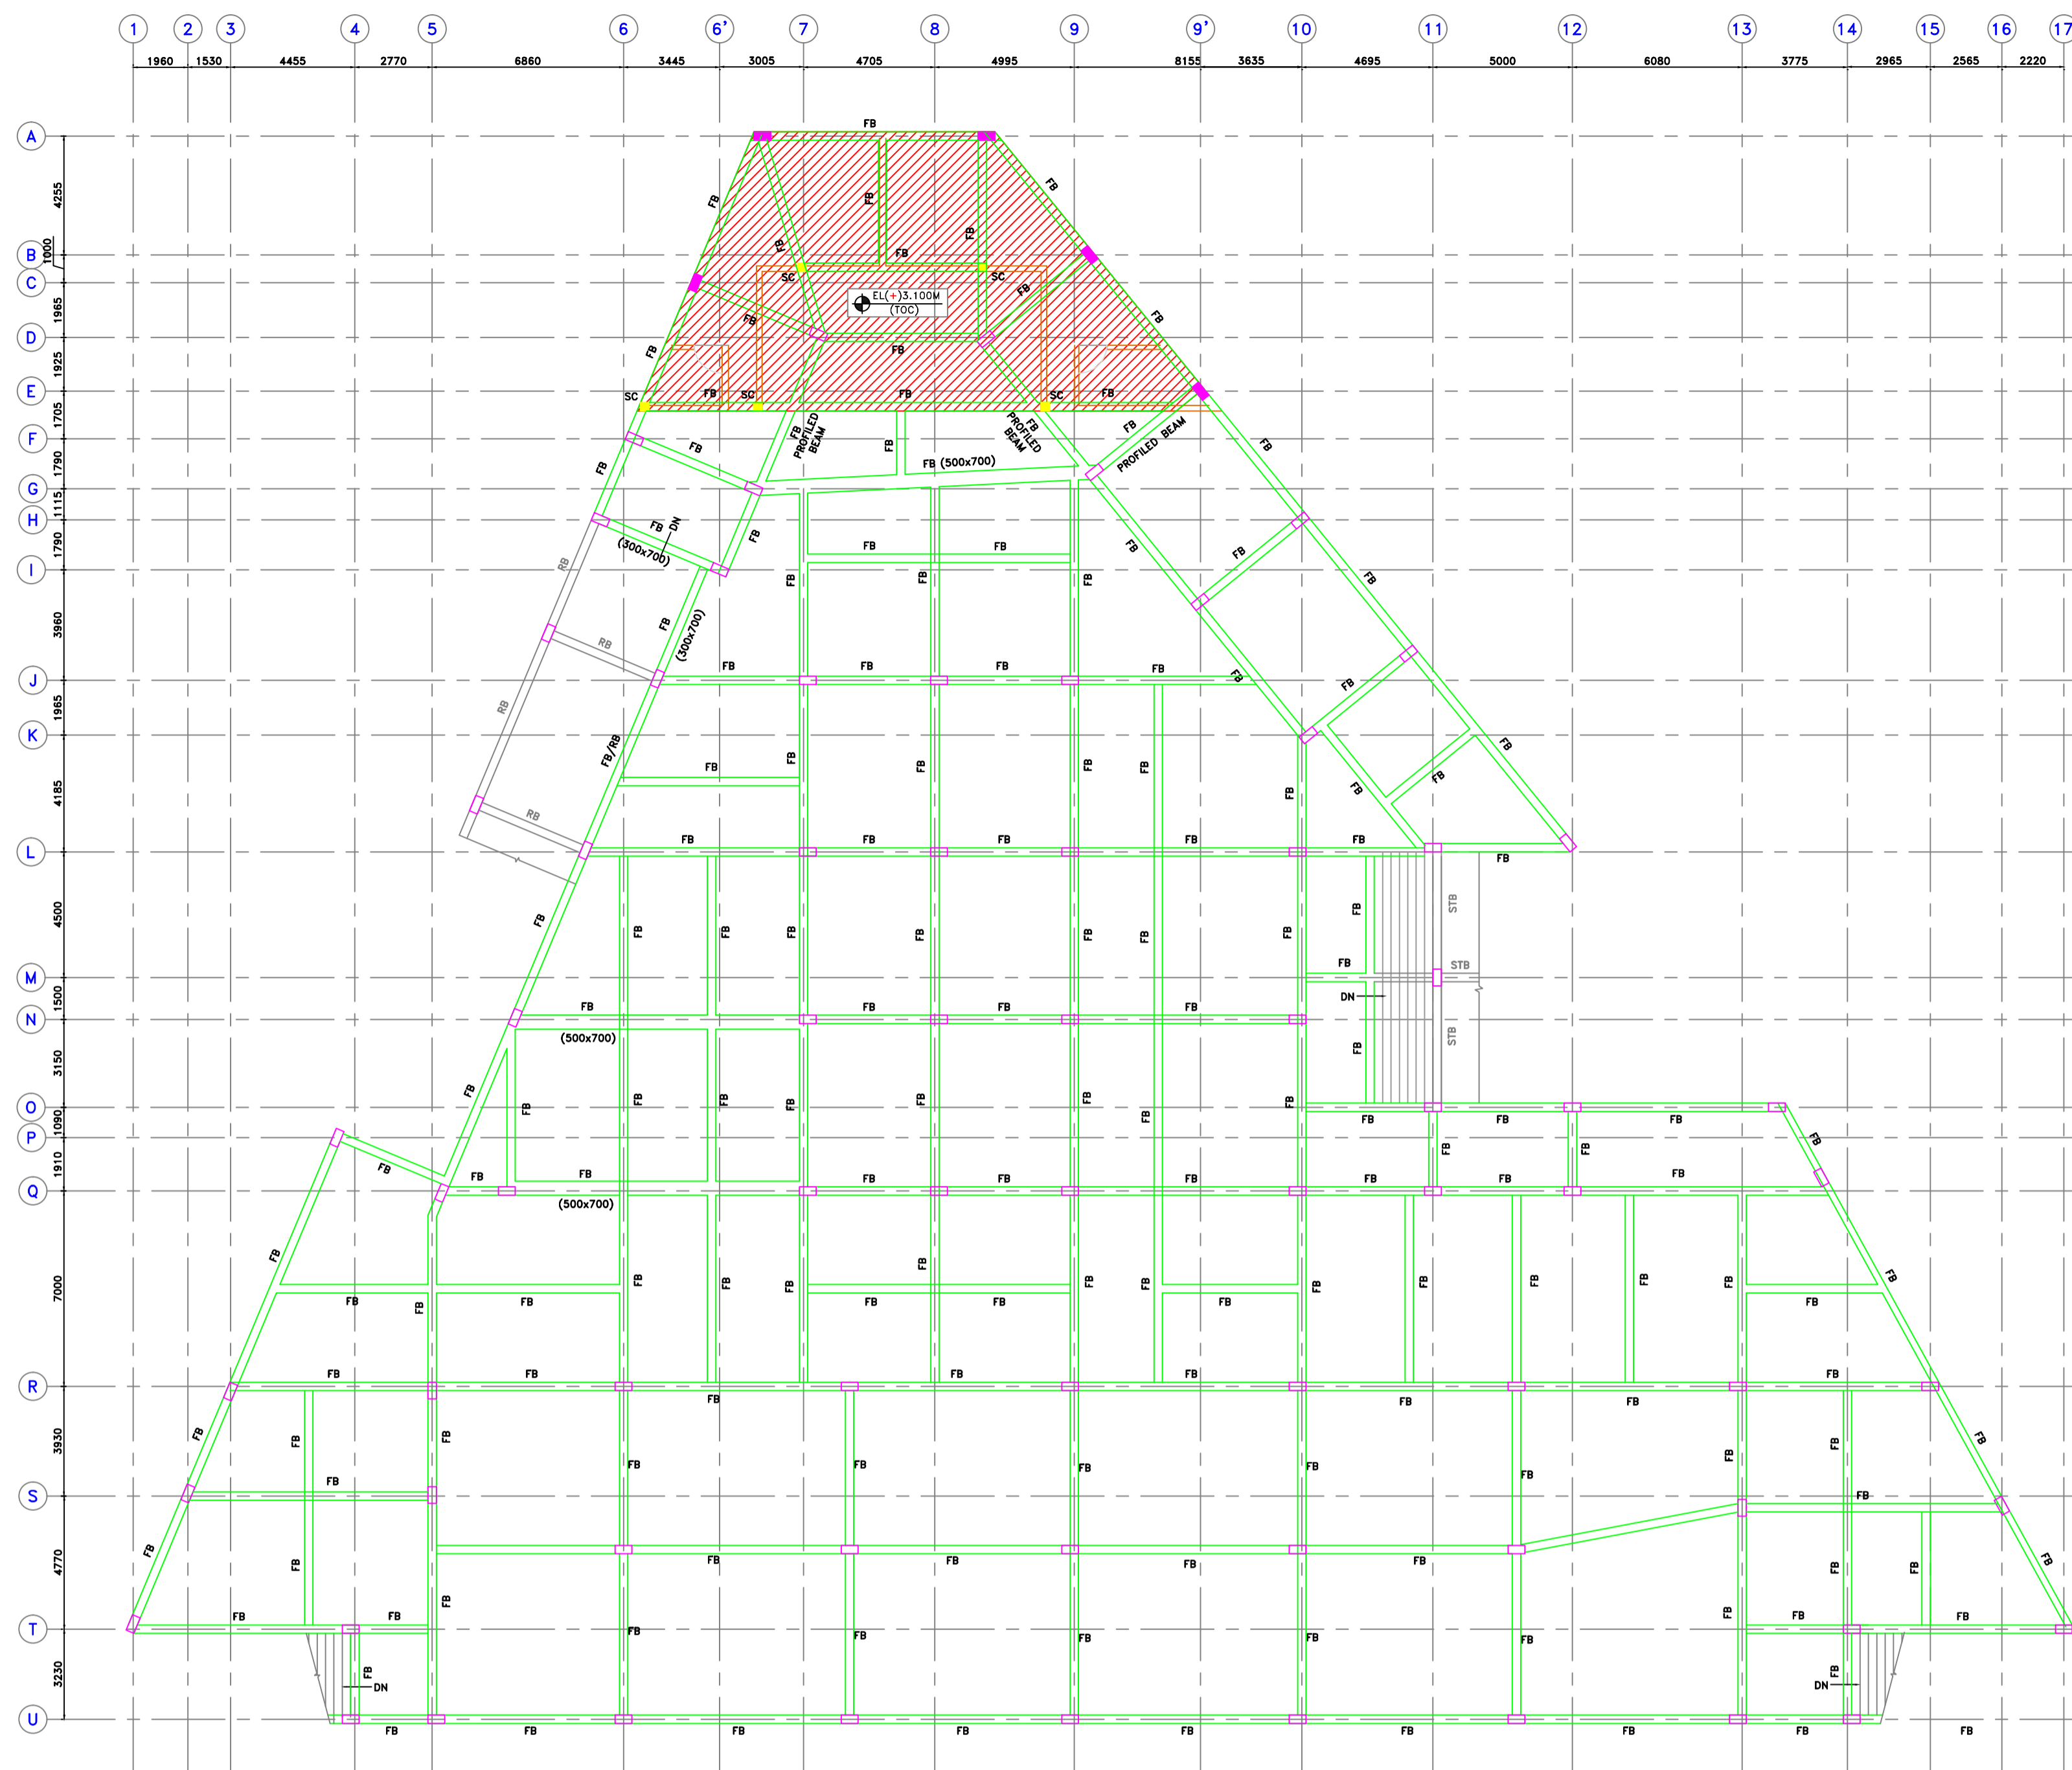

LAYOUT OF FIRST FLOOR BEAMS & SLABS AT EL(+)2.950M
ALL BEAMS ARE 300MM WIDE & 600MM DEEP, UNO
 THICKNESS OF SLAB IS 150MM


FIRST FLOOR BEAM PLAN

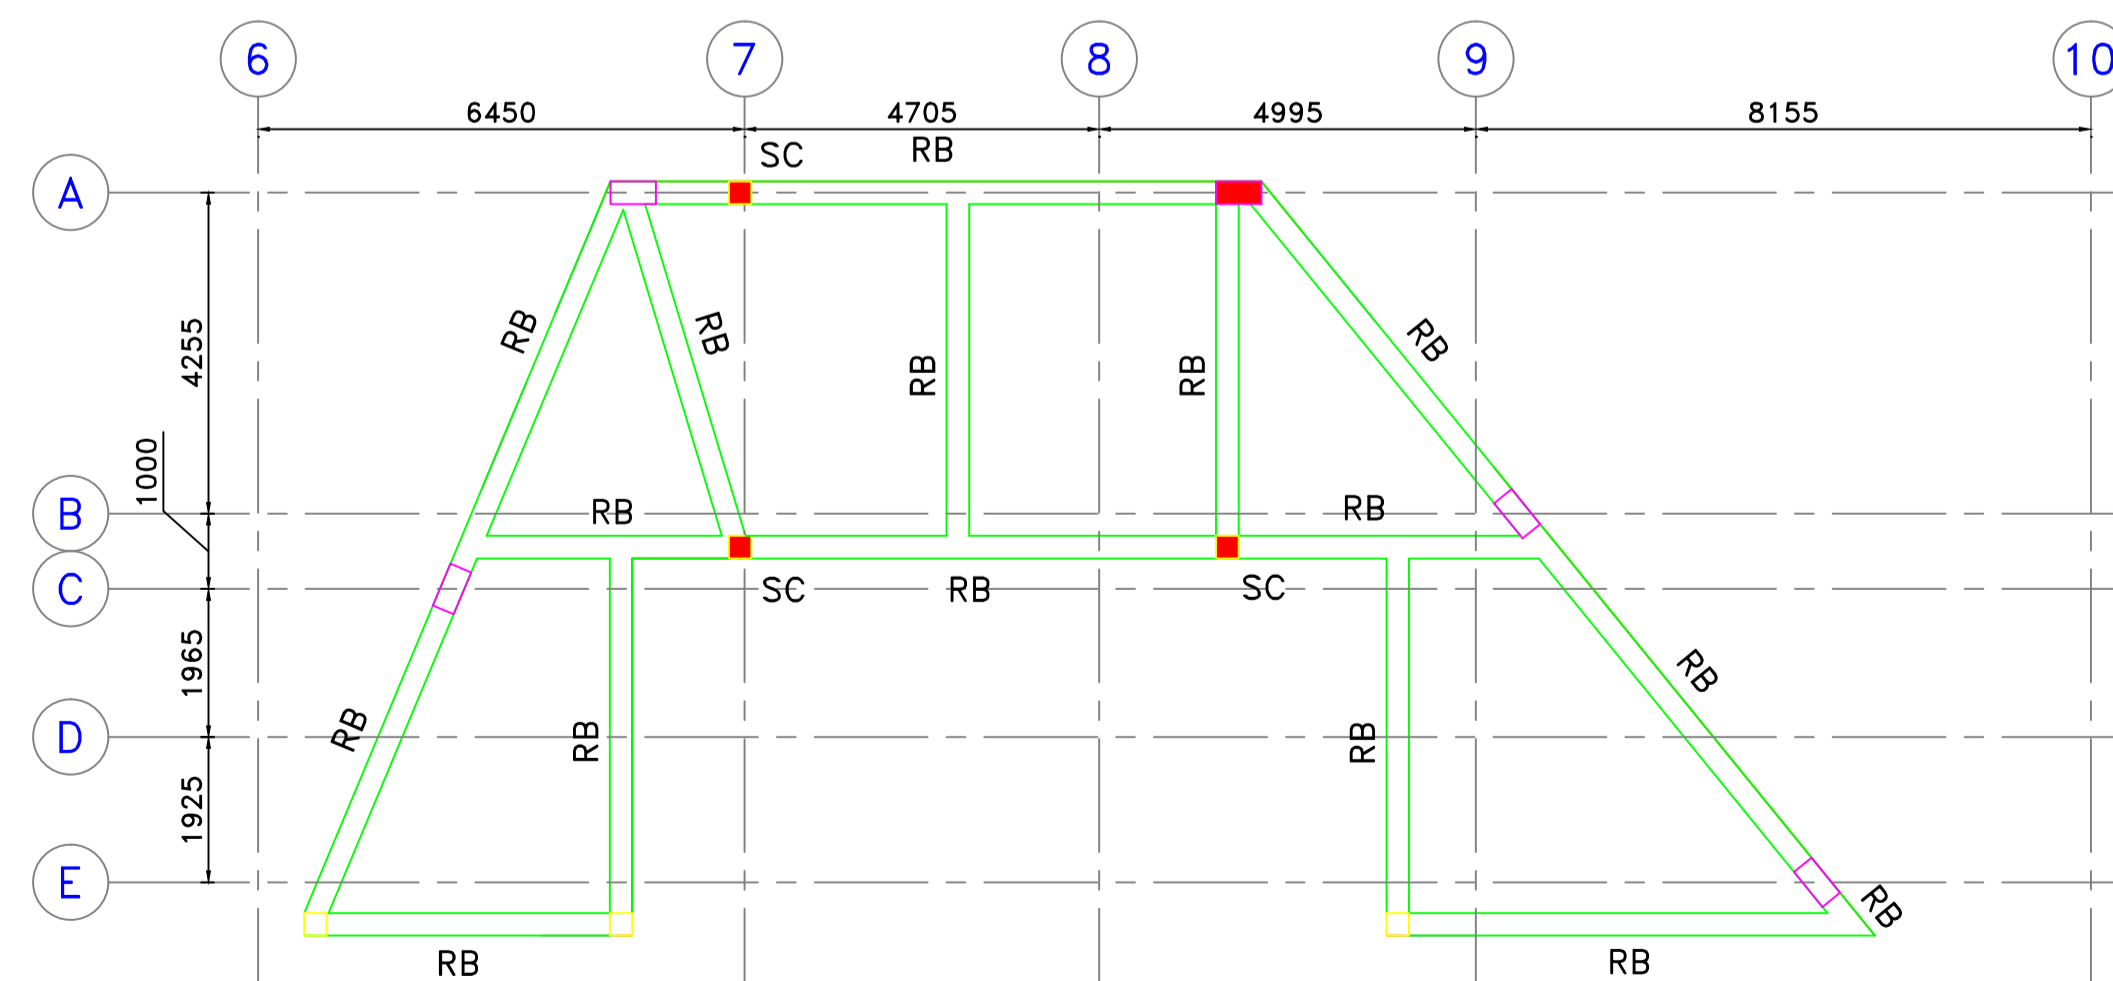

LAYOUT OF ROOF LEVEL BEAMS & SLABS AT EL(+)5.950M
ALL BEAMS ARE 300MM WIDE & 600MM DEEP
 THICKNESS OF SLAB IS 125MM

STAGE AREA BEAM PLAN

Key Plan

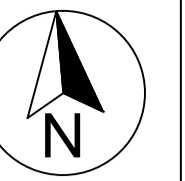

General Notes:

1. All dimensions are in millimeters, if otherwise specified.
2. Dimensions are to be read and not to be scaled.
3. The contractors must verify all dimensions on site and refer the relevant structural and other MEP drawings before commencing any work, and in case any discrepancy is noticed the same shall be brought to the notice of the Consultant and shall be clarified before execution of work.
4. All survey carried out through visual study of the building and no destructive analysis has been carried out.
5. Refer this drawing along with the other relevant architectural, structural and MEP services drawings.

Legends

Client

Jabalpur Smart City Limited



Submitted by

IPG GLOBAL
IPG GLOBAL LIMITED
 B-84, Defence Colony, New Delhi - 110024

Project

**COMMUNITY MARRIAGE HALL,
 GARHA, JABALPUR**

Sub-project

Rev.	Date	Description	Approved

Revision Index

Drawing Title



First Floor Beam Plan

<input checked="" type="checkbox"/> For Tender	Date August 13, 2019	Drawn PB
<input type="checkbox"/> For Information	Scale	Sheet Size A1
<input type="checkbox"/> For Execution		Checked SRK Approved SRK

Dwg. No.

IPG/JSCL/CMH/ST/04

Revision

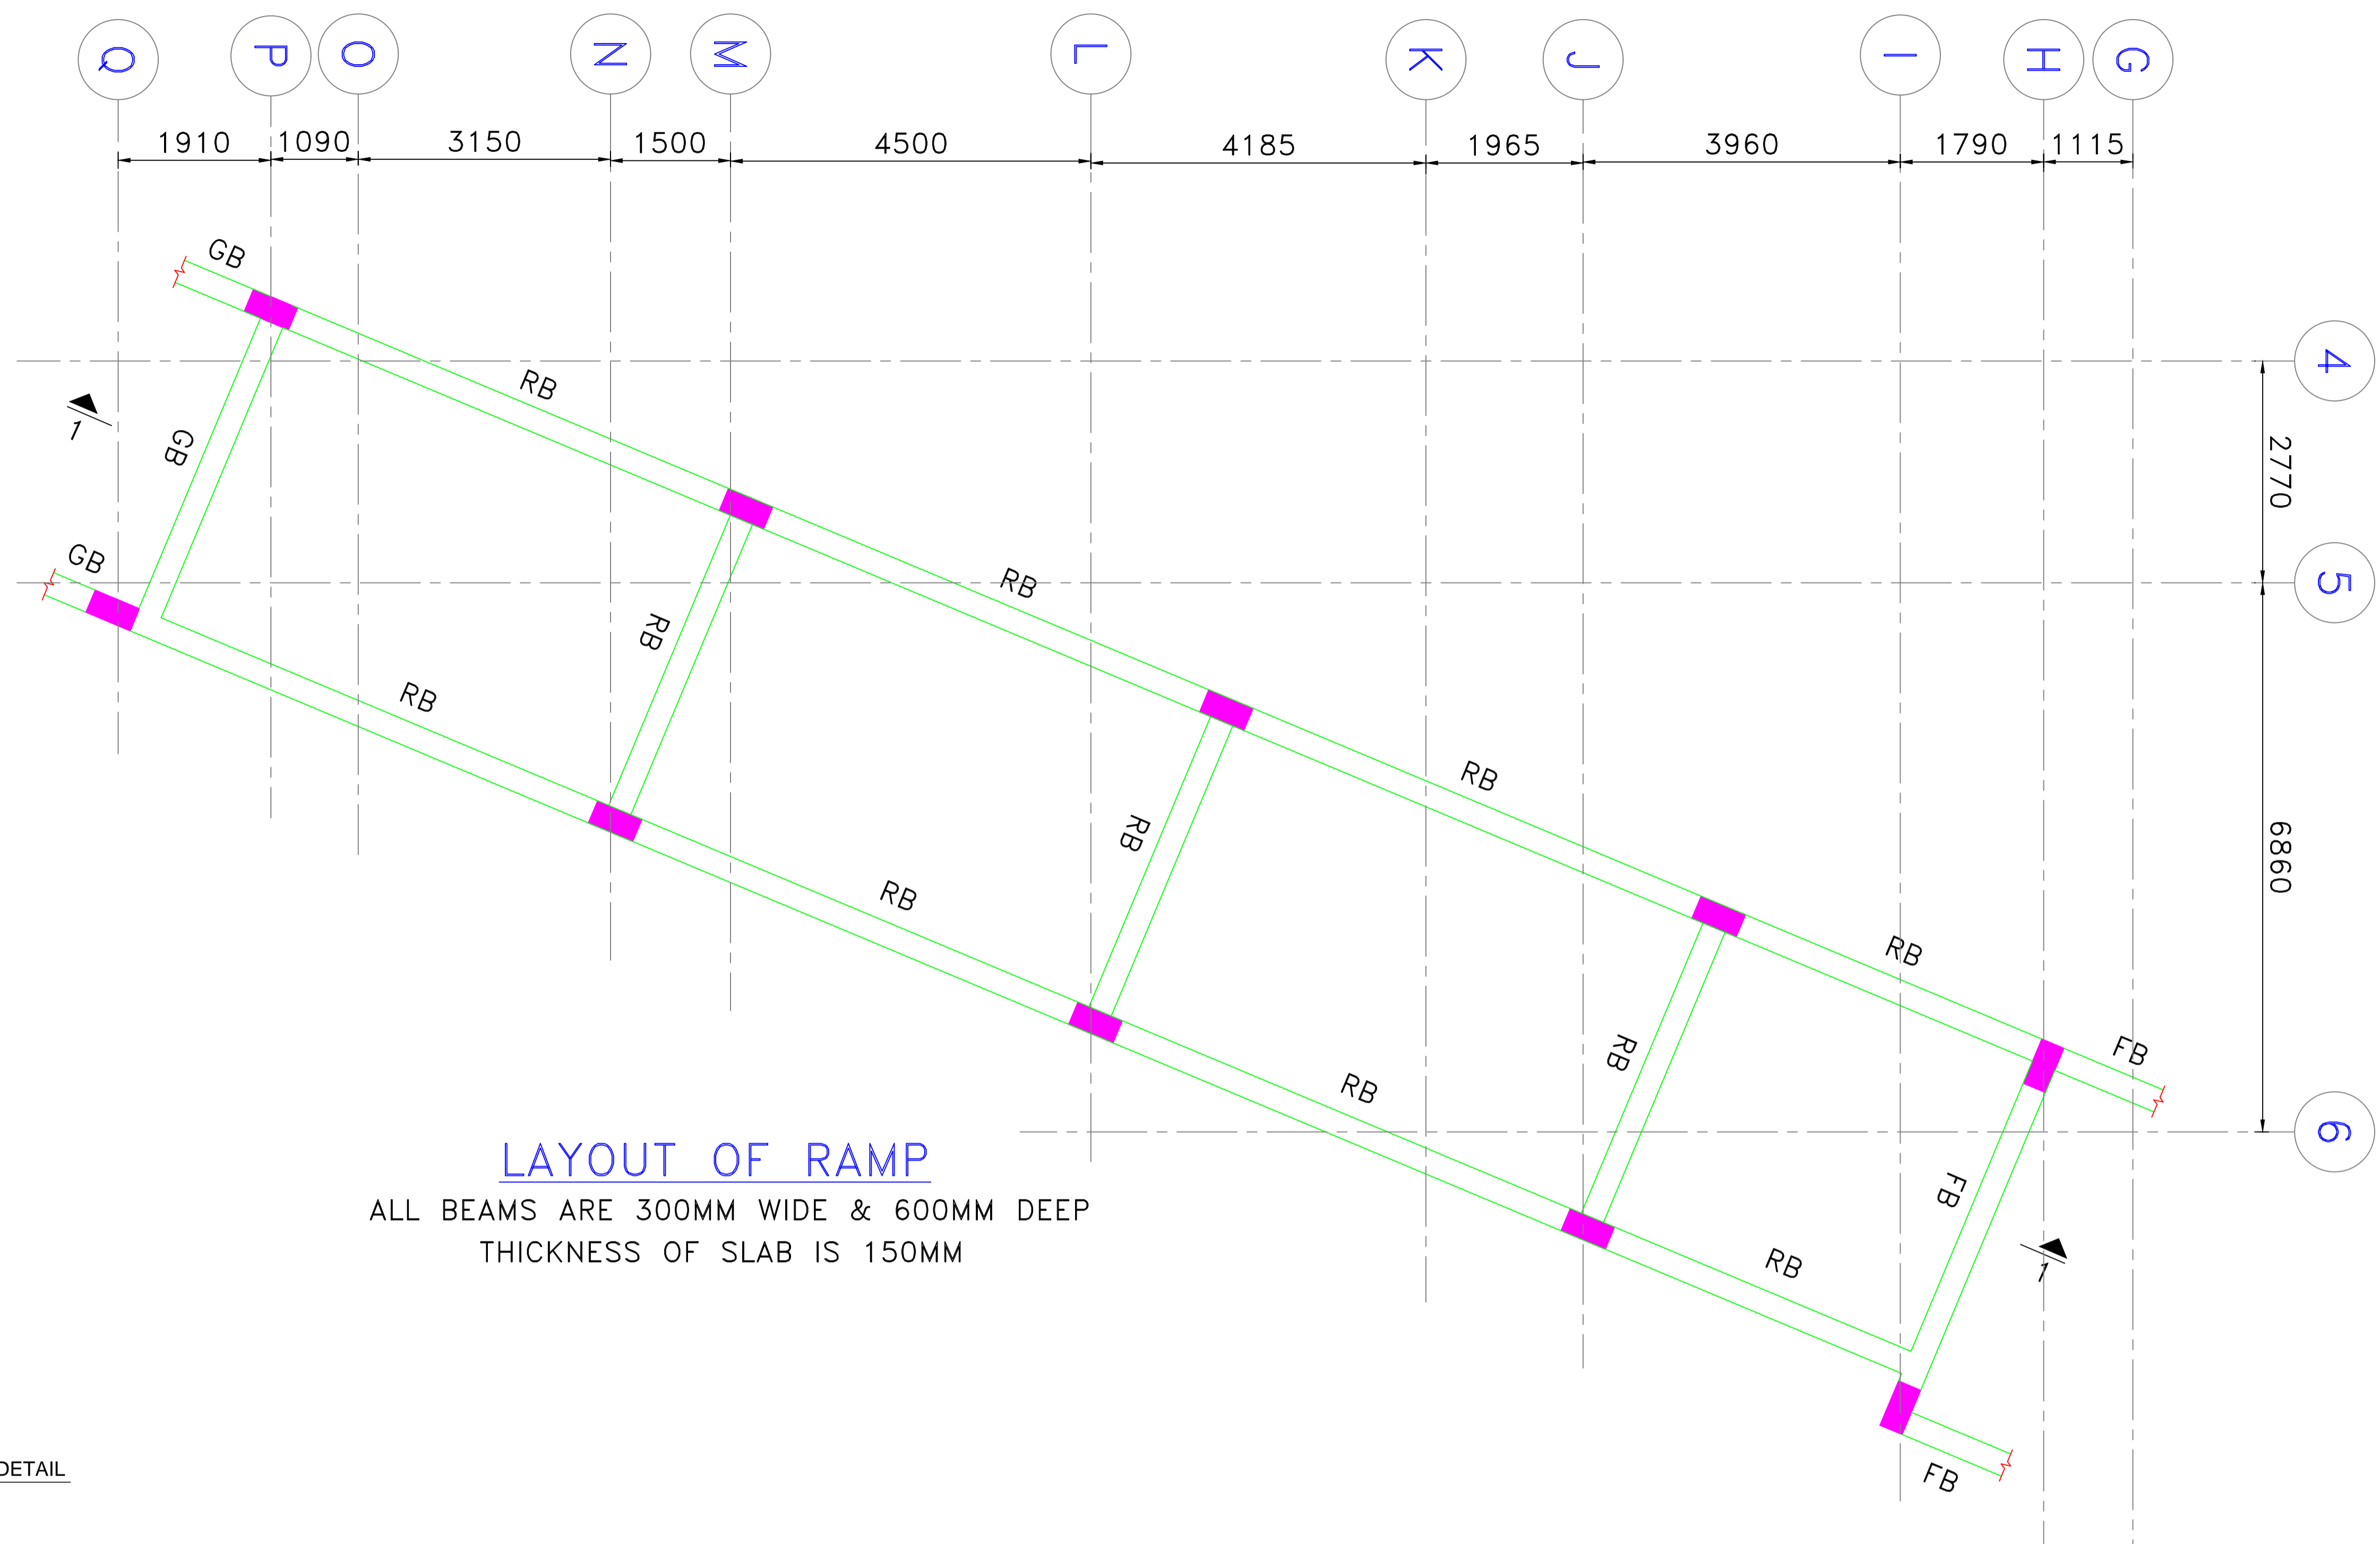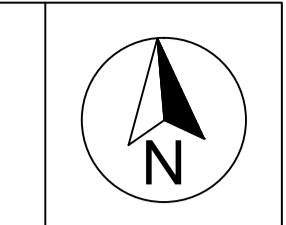


LAYOUT OF RAMP
 ALL BEAMS ARE 300MM WIDE & 600MM DEEP
 THICKNESS OF SLAB IS 150MM

- General Notes:**
1. All dimensions are in millimeters, if otherwise specified.
 2. Dimensions are to be read and not to be scaled.
 3. The contractors must verify all dimensions on site and refer the relevant structural and other MEP drawings before commencing any work, and in case any discrepancy is noticed the same shall be brought to the notice of the Consultant and shall be clarified before execution of work.
 4. All survey carried out through visual study of the building and no destructive analysis has been carried out.
 5. Refer this drawing along with the other relevant architectural, structural and MEP services drawings.

Legends

Client
 Jabalpur Smart City Limited



Submitted by
IFE GLOBAL
 IFE GLOBAL LIMITED
 B-84, Defence Colony, New Delhi - 110024

Project
**COMMUNITY MARRIAGE HALL,
 GARHA, JABALPUR**

Sub-project

Rev.	Date	Description	Approved

Revision Index

Drawing Title


Ramp Plan & Section Detail

<input checked="" type="checkbox"/> For Tender <input type="checkbox"/> For Information <input type="checkbox"/> For Execution	Date	August 13, 2019	Drawn PB
	Scale		Checked SRK
	Sheet Size	A1	Approved SRK

Dwg. No.
IFE/JSCL/CMH/ST/06


Revision

RAMP PLAN DETAIL

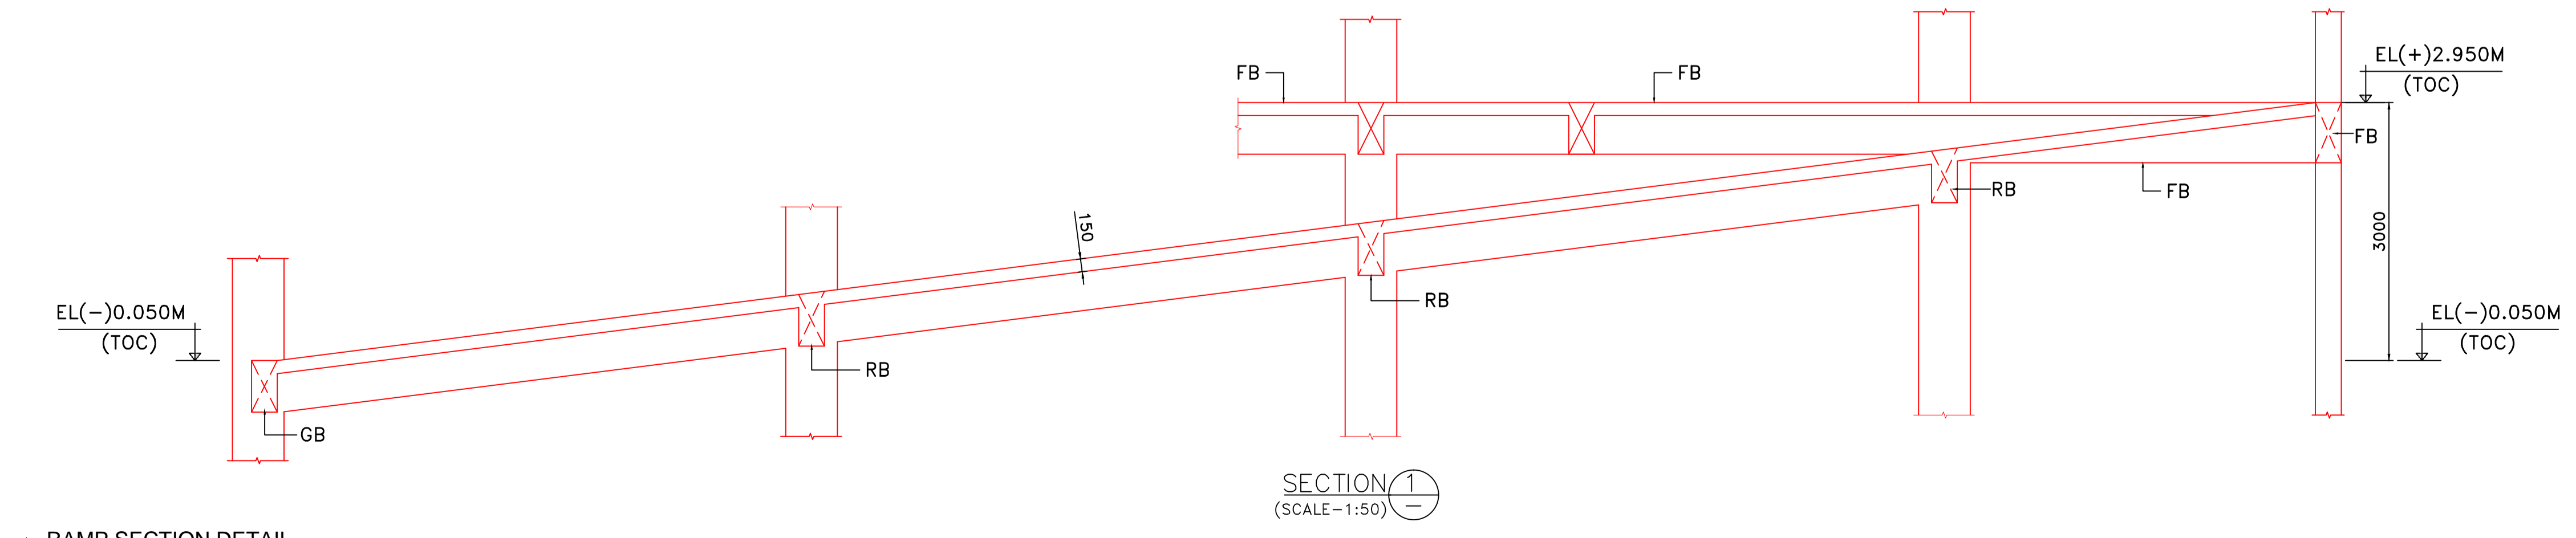


SECTION 1
 (SCALE - 1:50)

RAMP SECTION DETAIL

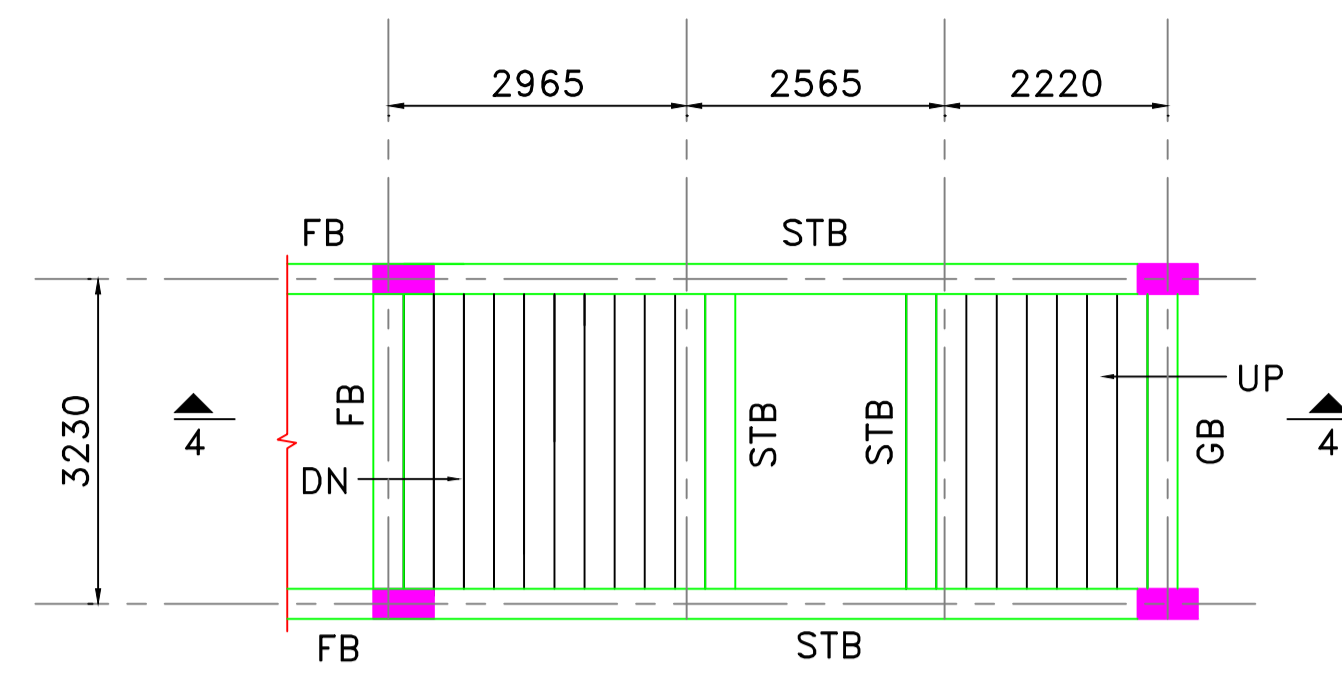


LAYOUT OF STAIRCASE-1&2
 ALL BEAMS ARE 300MM WIDE & 600MM DEEP
 THICKNESS OF FLIGHT SLAB IS 150MM

STAIR-1&2 PLAN DETAIL

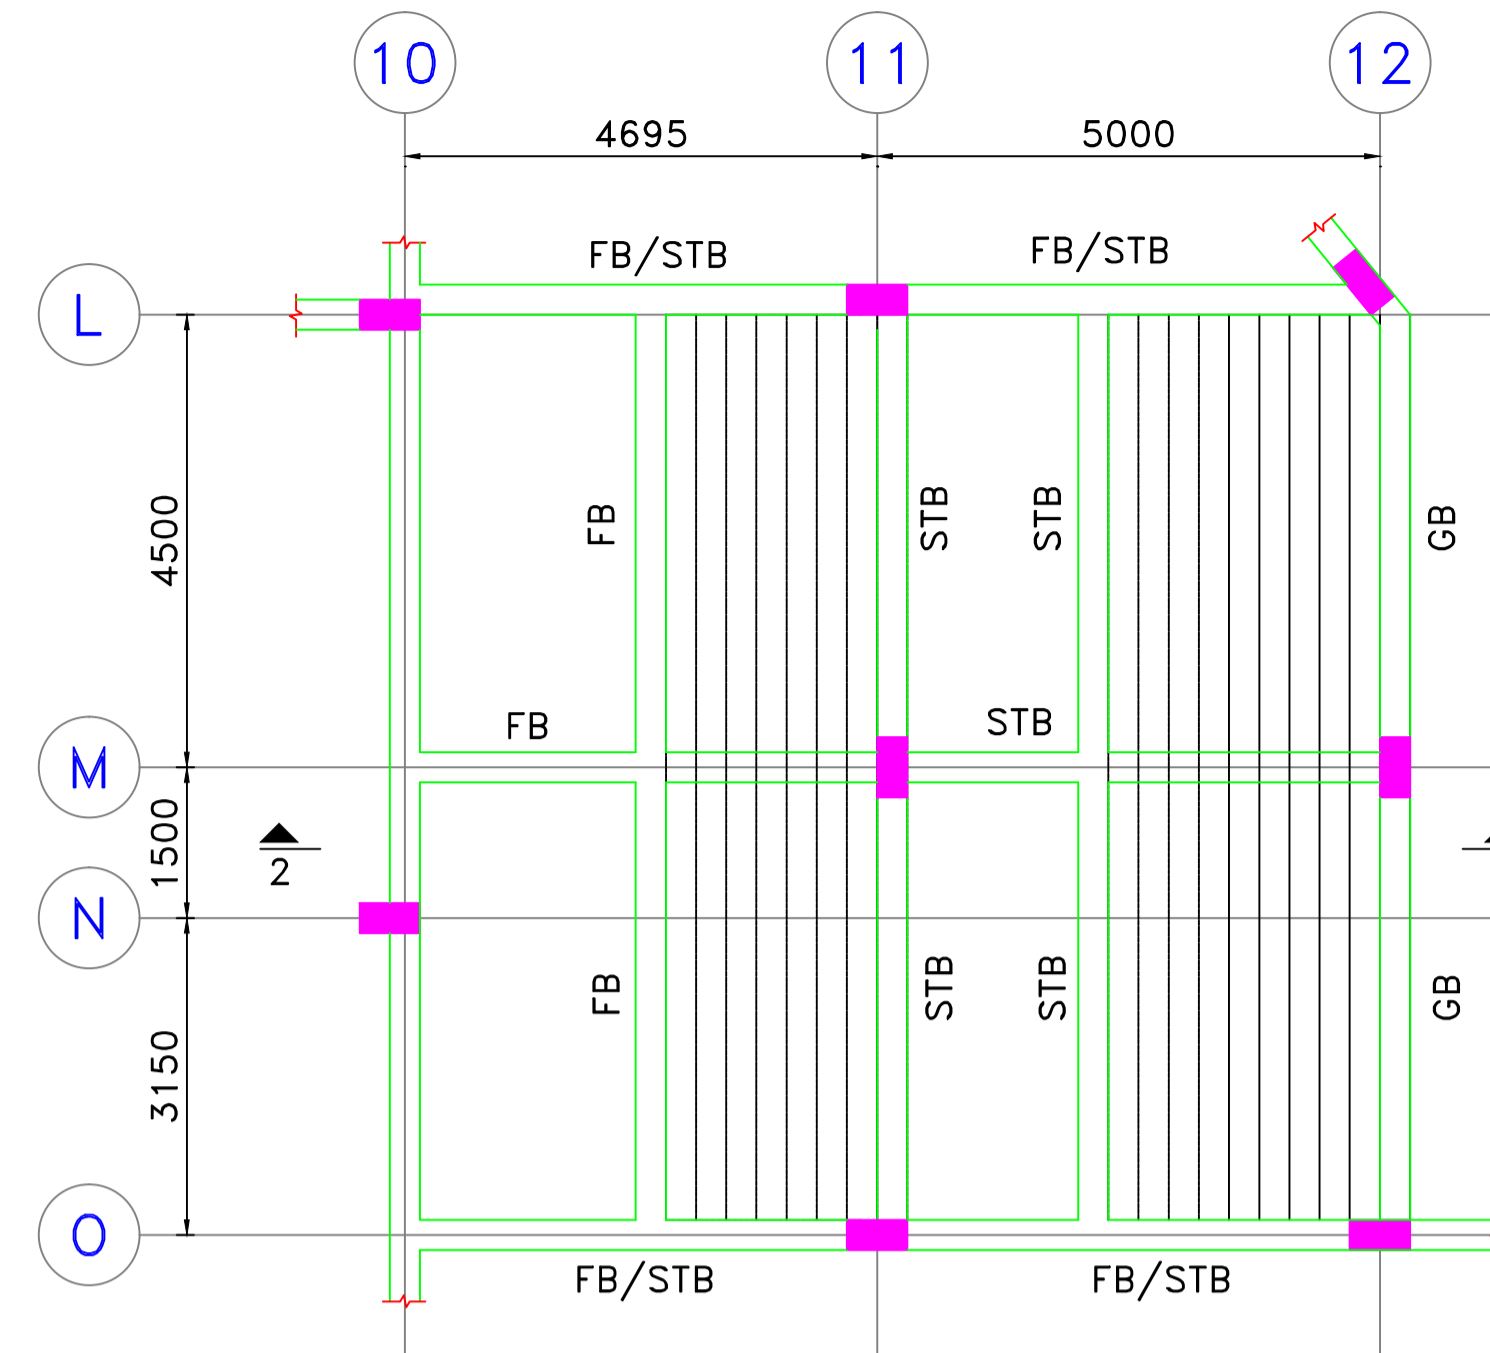

LAYOUT OF STAIRCASE-3
 ALL BEAMS ARE 300MM WIDE & 600MM DEEP
 THICKNESS OF FLIGHT SLAB IS 150MM


STAIR-3 PLAN DETAIL

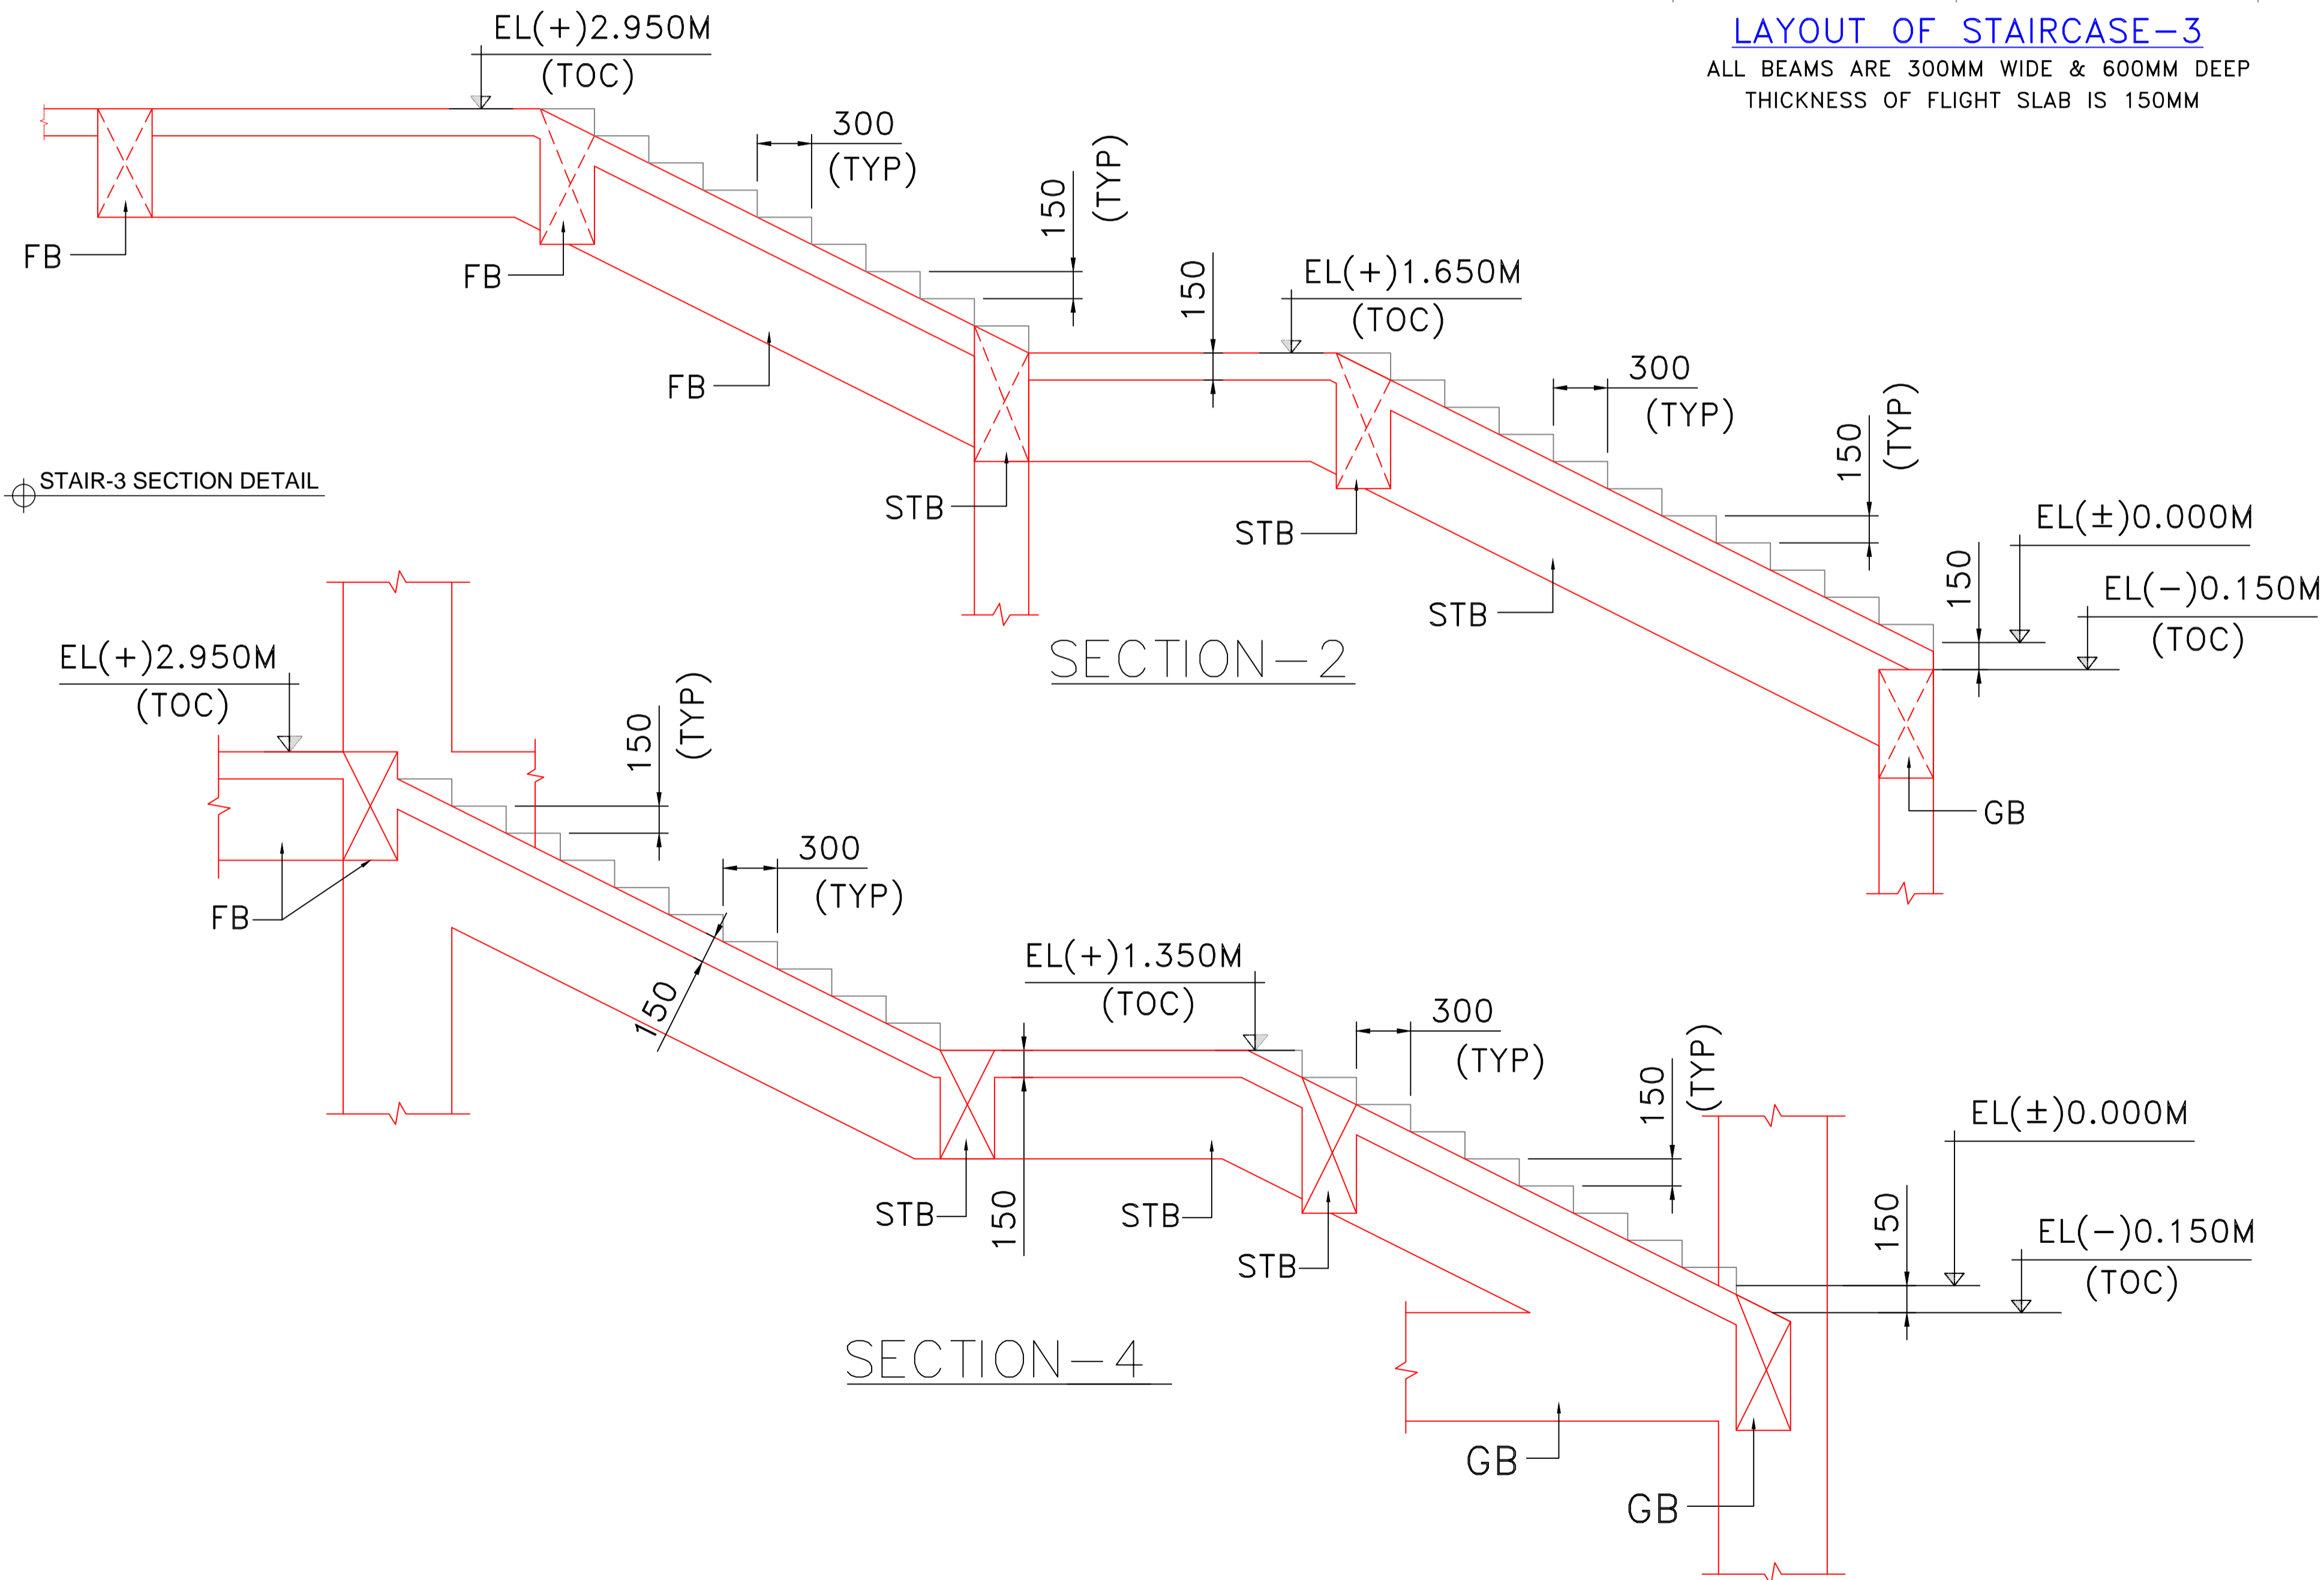

STAIR-3 SECTION DETAIL

STAIR-1&2 SECTION DETAIL

Key Plan

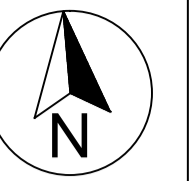

General Notes:

1. All dimensions are in millimeters, if otherwise specified.
2. Dimensions are to be read and not to be scaled.
3. The contractors must verify all dimensions on site and refer the relevant structural and other MEP drawings before commencing any work, and in case any discrepancy is noticed the same shall be brought to the notice of the Consultant and shall be clarified before execution of work.
4. All survey carried out through visual study of the building and no destructive analysis has been carried out.
5. Refer this drawing along with the other relevant architectural, structural and MEP services drawings.

Legends

Client

Jabalpur Smart City Limited



Submitted by



IPE GLOBAL LIMITED
 B-84, Defence Colony, New Delhi - 110024

Project

**COMMUNITY MARRIAGE HALL,
 GARHA, JABALPUR**

Sub-project

Rev.	Date	Description	Approved

Revision Index

Drawing Title

Stairs Plan & Section Detail

<input checked="" type="checkbox"/> For Tender <input type="checkbox"/> For Information <input type="checkbox"/> For Execution	Date	August 13, 2019	Drawn PB
	Scale		Checked SRK
	Sheet Size	A1	Approved SRK

Dwg. No.	Revision
IPE/JSCL/CMH/ST/05	