


DRG NO: AR-PL-01
DATE 10 SEP 2017

PROJECT :
INTIMATE THEATER AND
O.A.T. DESIGN AT
BHAWARTAL LAKE,
JABALPUR

SHEET TITLE :
SITE PLAN
LEVEL ±00

NORTH  SCALE: 1:150

PEDESTRIAN WALKWAY

ROAD

AWNW
A. Wallabh and
Wallabh Associates
Architecture, Interiors, Planning, Landscape
and Project Management
B-5/86, Paschim Vihar,
New Delhi - 110063

AR. HEMANGI WALLABH

DRAWN BY :
AR. SHASHANK
GOYAL


CHECKED BY :
AR. HEMANGI
WALLABH


SIGN AND STAMP :

APPROVAL NOTES

PROJECT:
INTIMATE THEATER AND
O.A.T. DESIGN AT
BHAWARTAL LAKE,
JABALPUR

SHEET TITLE:
FLOOR PLANS
LEVEL -1200mm

NORTH  SCALE: 1:100

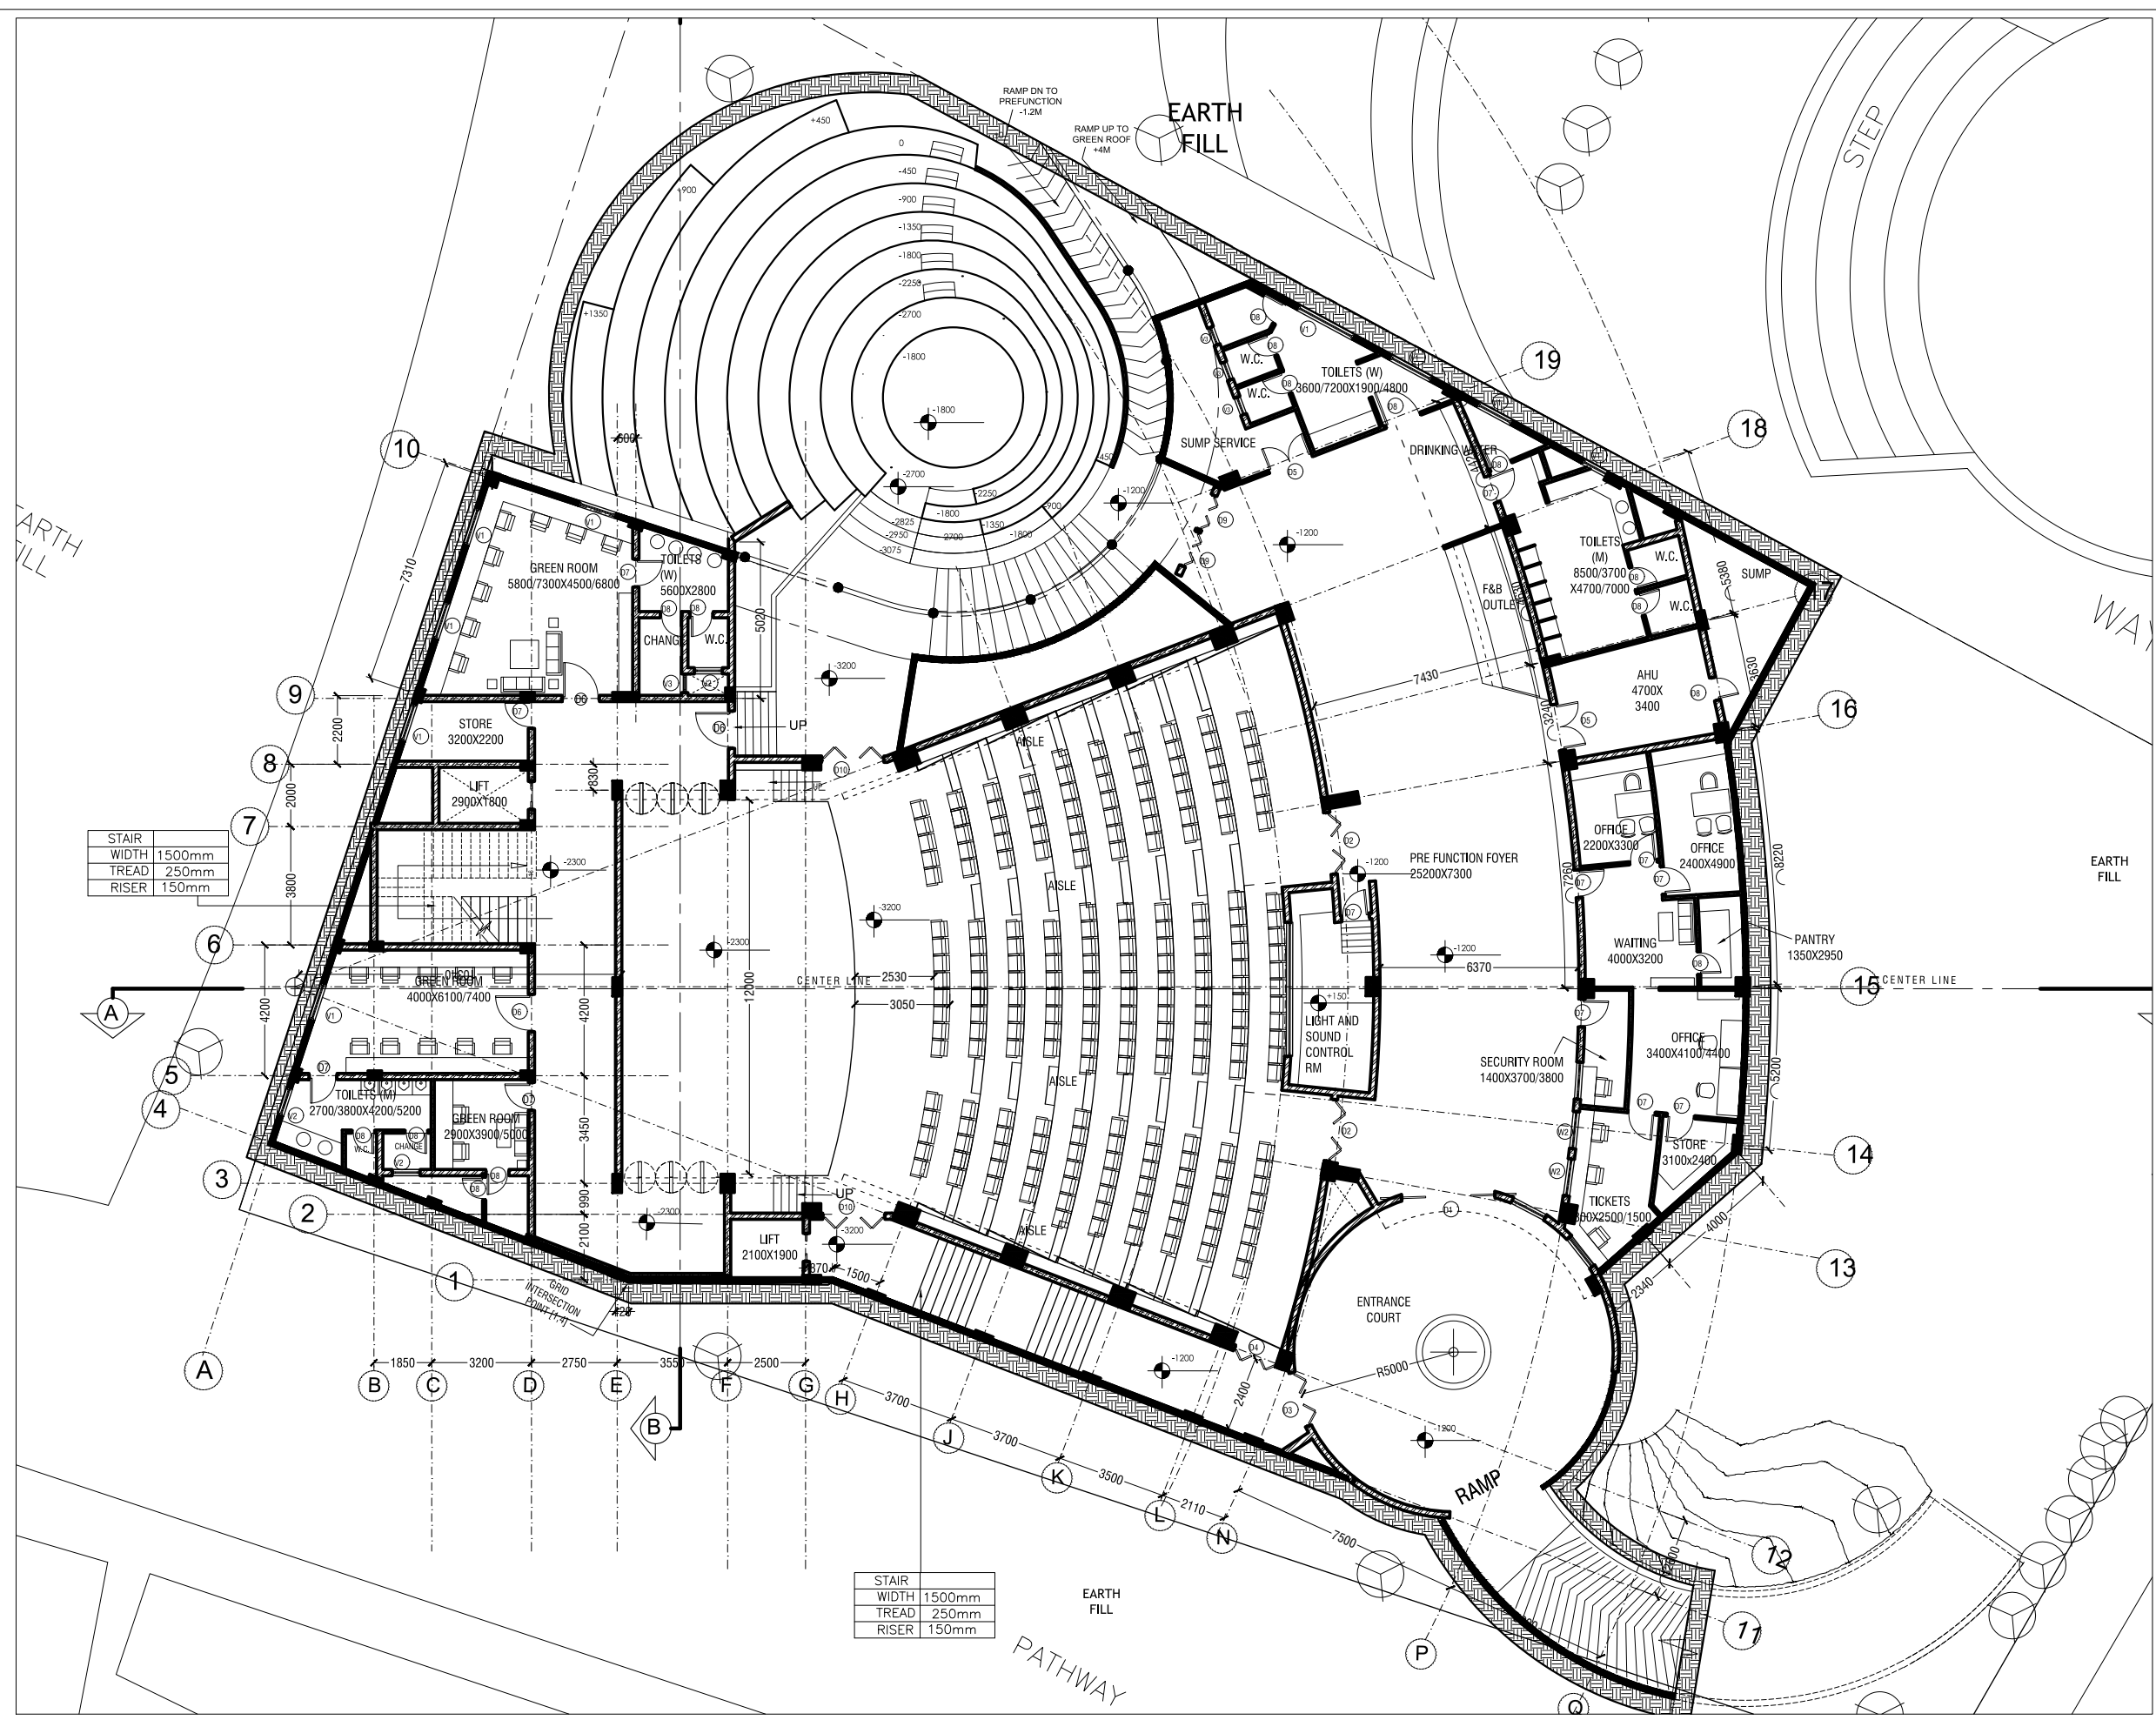

AWN
A. Wallabh and Wallabh Associates
Architecture, Interiors, Planning, Landscape and Project Management
B-5/86, Paschim Vihar, New Delhi - 110063

AR. HEMANGI WALLABH

DRAWN BY: AR. SHASHANK GOYAL
CHECKED BY: AR. HEMANGI WALLABH

SIGN AND STAMP:
APPROVAL NOTES


PROJECT :
INTIMATE THEATER AND
O.A.T. DESIGN AT
BHAWARTAL LAKE,
JABALPUR

SHEET TITLE :
FLOOR PLANS
LEVEL +1300mm

NORTH



SCALE: 1:100

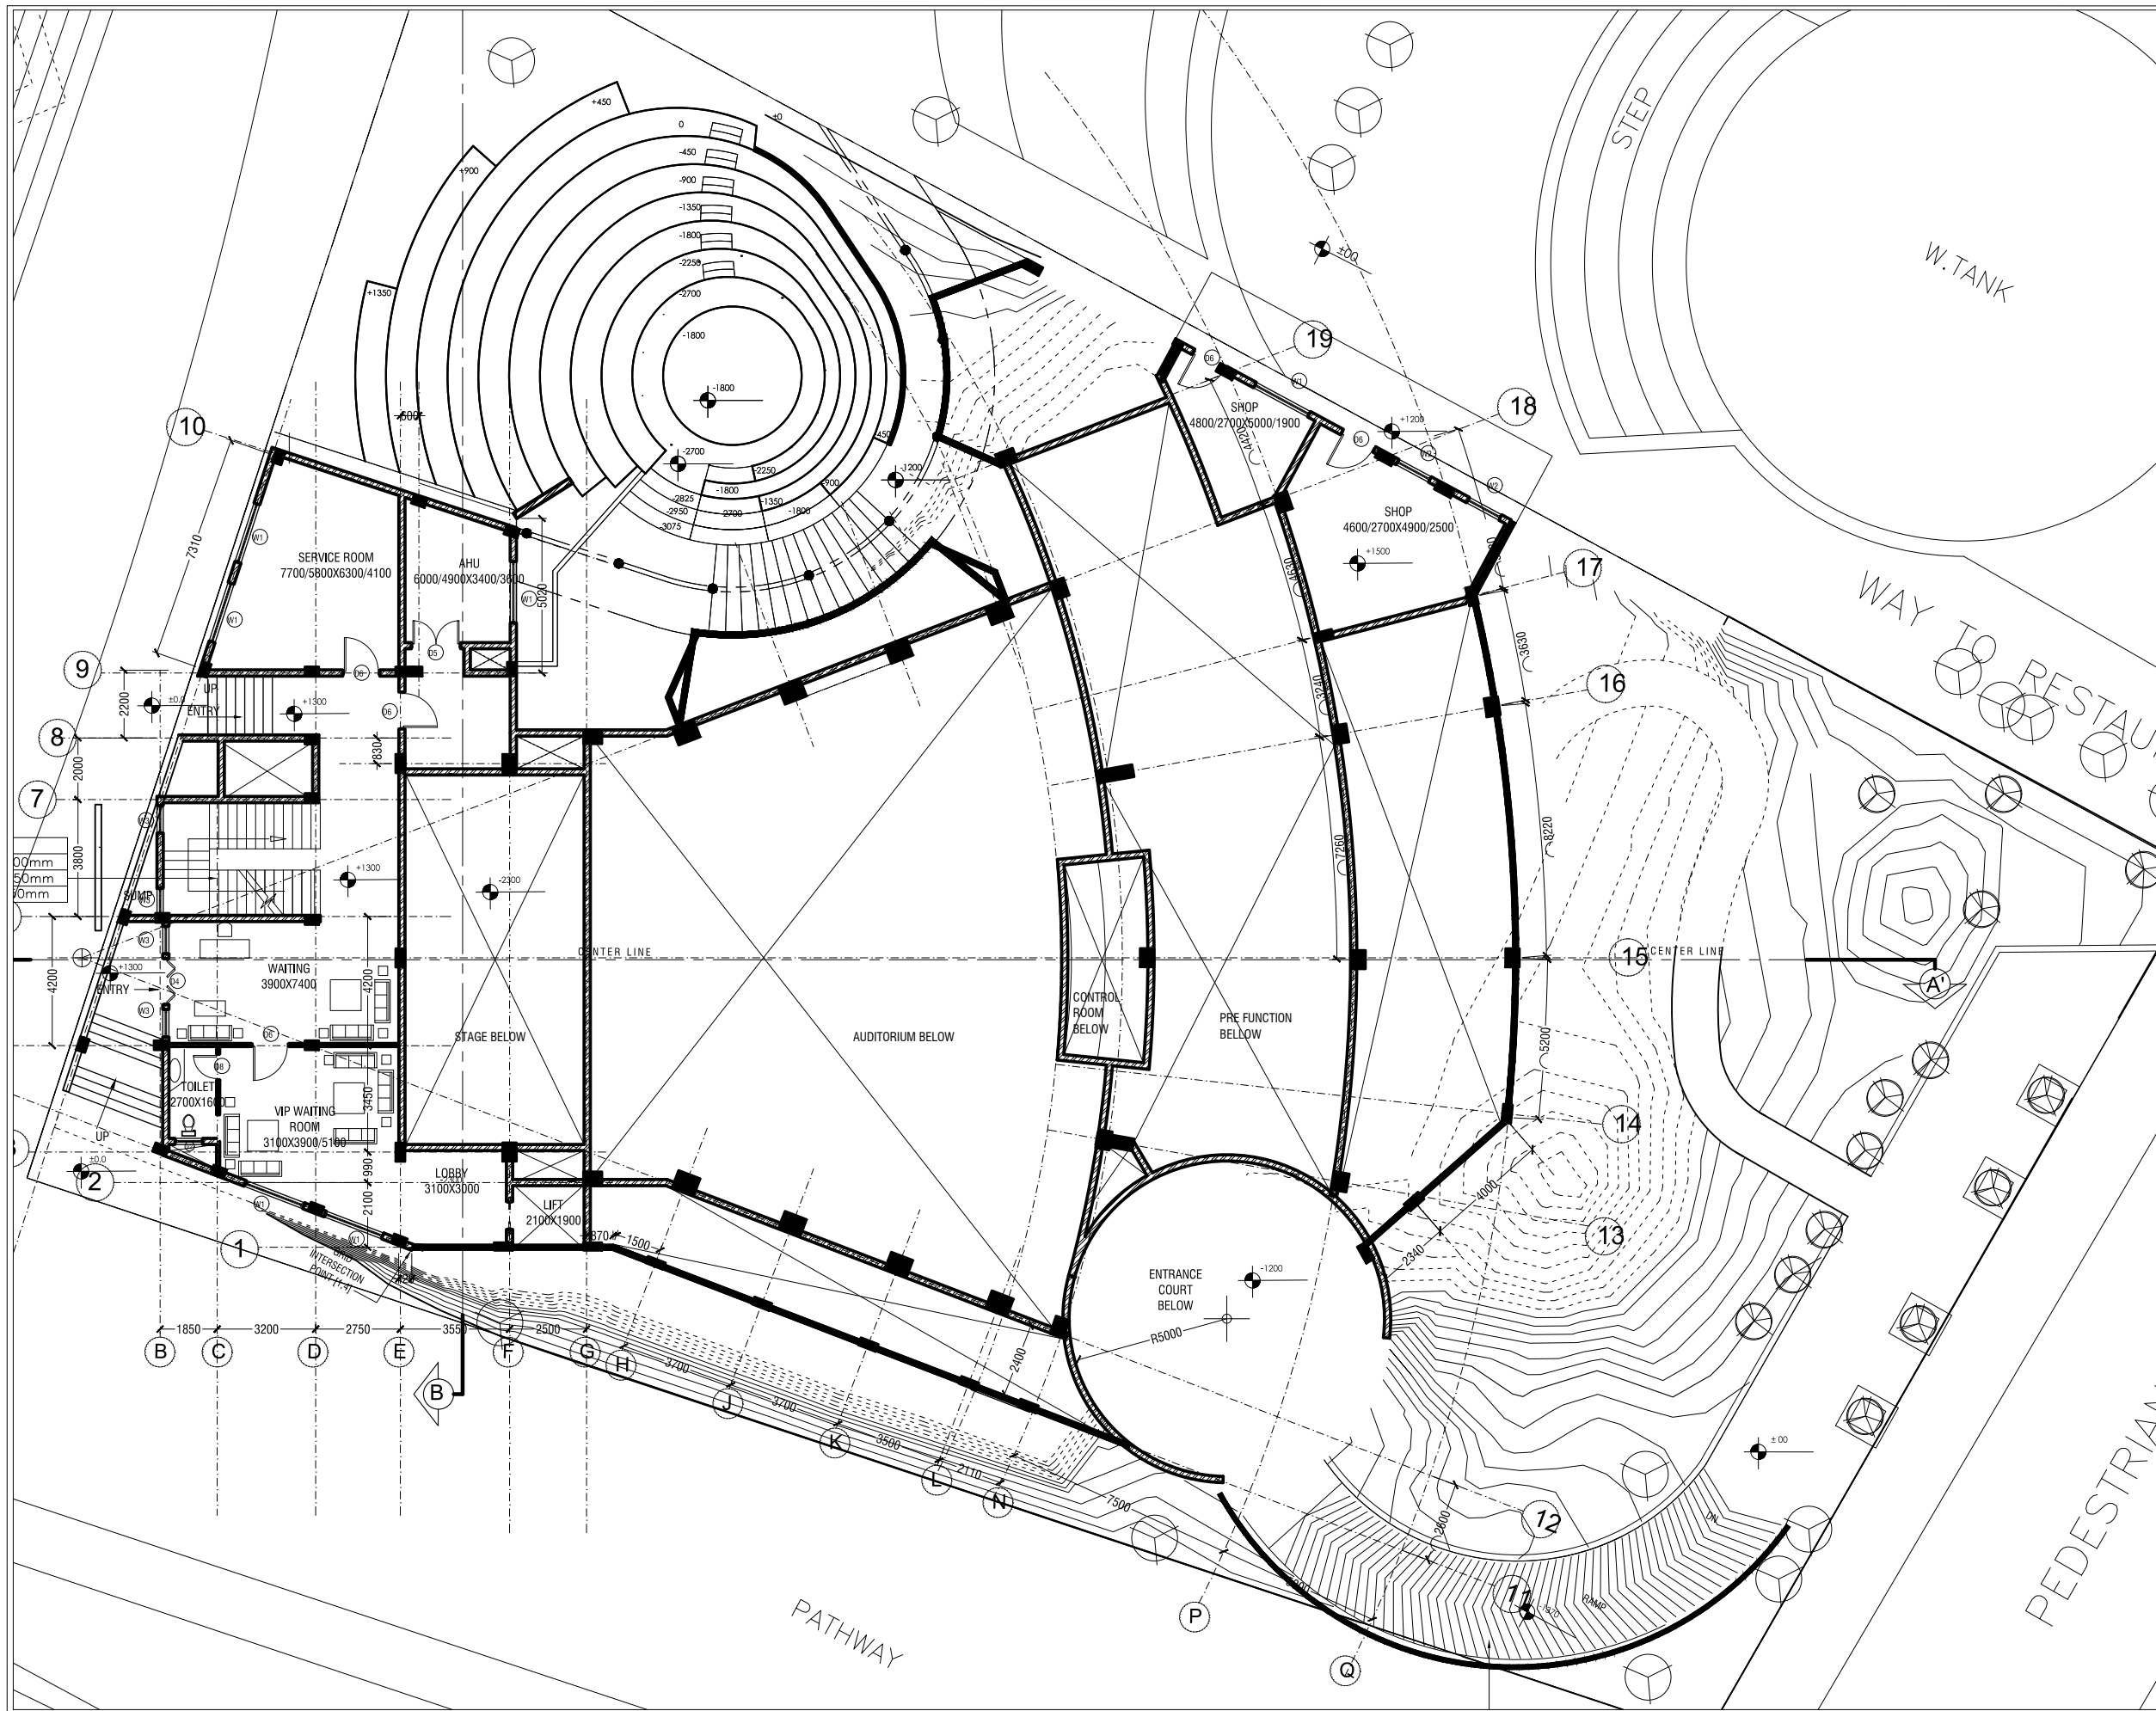

AWN
A. Wallabh and
Wallabh Associates

Architecture, Interiors, Planning, Landscape
and Project Management
B-5/86, Paschim Vihar,
New Delhi - 110063

AR. HEMANGI WALLABH

DRAWN BY :
AR. SHASHANK
GOYAL

CHECKED BY :
AR. HEMANGI
WALLABH

SIGN AND STAMP :

APPROVAL NOTES


DRG NO: AR-EL-01
DATE 12 SEP 2017

PROJECT:
INTIMATE THEATER AND
O.A.T. DESIGN AT
BHAWARTAL LAKE,
JABALPUR


SHEET TITLE:
ELEVATION

NORTH

SCALE: 1:200

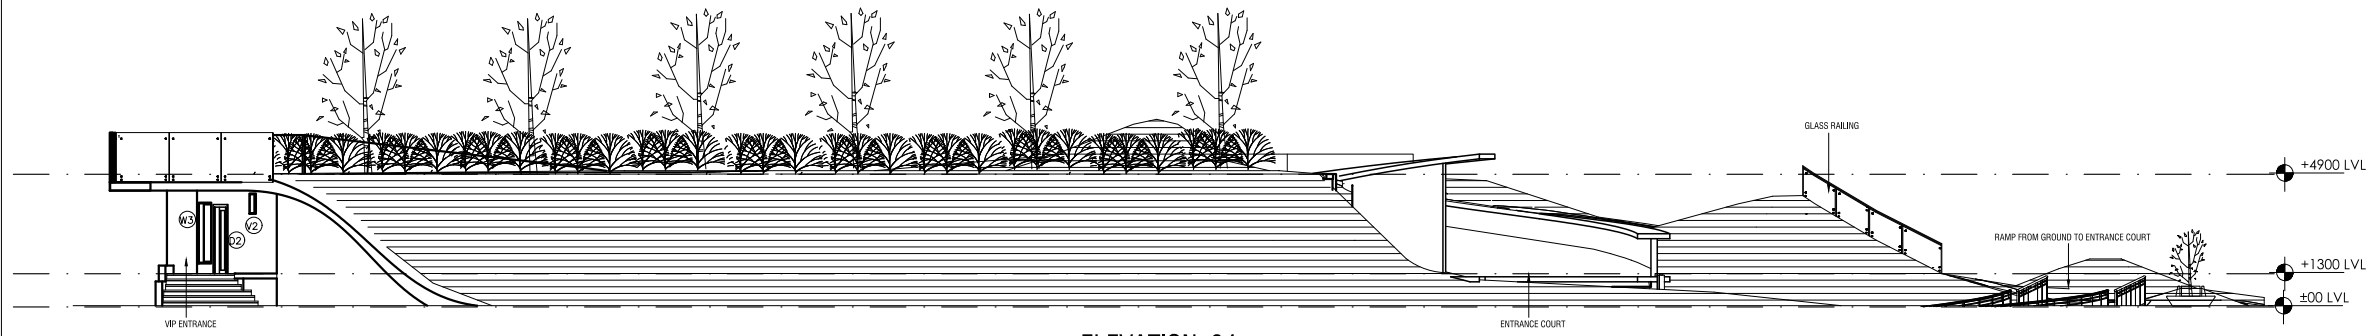

ELEVATION 04

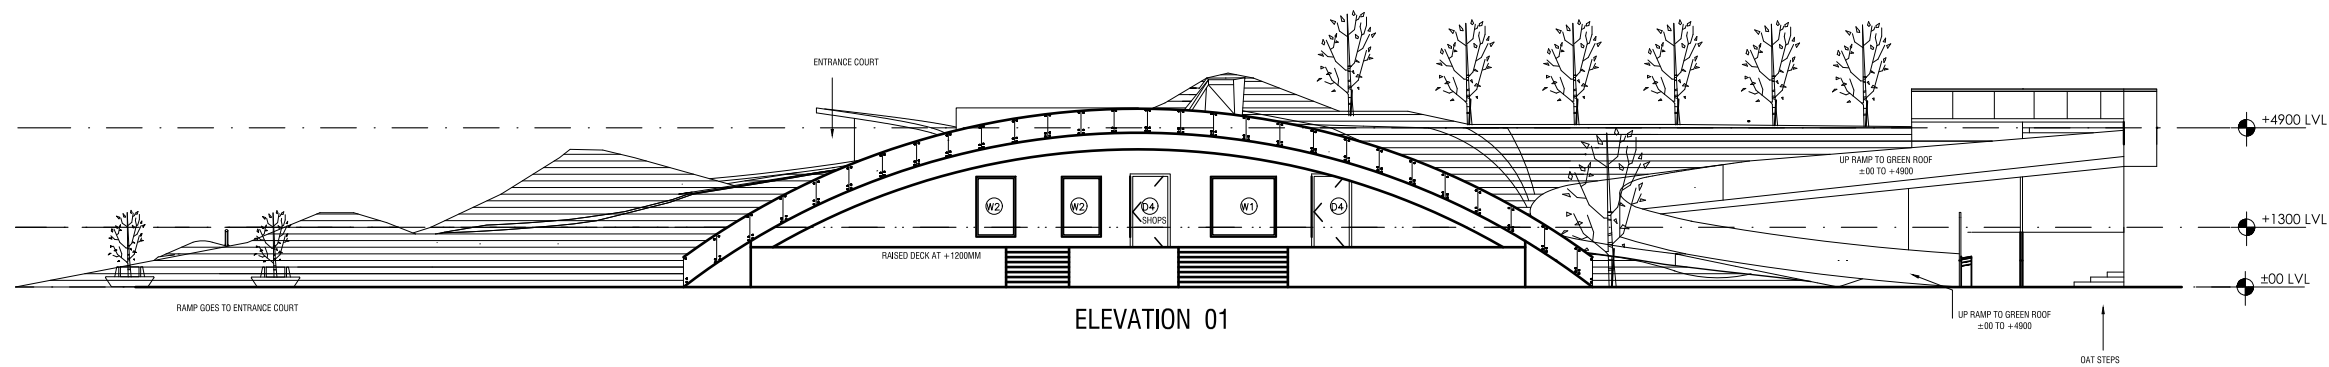

ELEVATION 01

AWN
**A. Wallabh and
Wallabh Associates**

Architecture, Interiors, Planning, Landscape
and Project Management

B-5/86, Paschim Vihar,
New Delhi - 110063

AR. HEMANGI WALLABH
0-9990604334

C.O.A. NO. **AR/2015/0082/MPPWD**

DRAWN BY :
AR. SHASHANK
GOYAL
0-9669137471

CHECKED BY :
AR. HEMANGI WALLABH
0-9990604334

SIGN AND STAMP :

APPROVAL NOTES


DRG NO: AR-EL-02
DATE 26 JULY 2017

PROJECT :
INTIMATE THEATER AND
O.A.T. DESIGN AT
BHAWARTAL LAKE,
JABALPUR


SHEET TITLE :
ELEVATION_2

NORTH

SCALE: 1:200

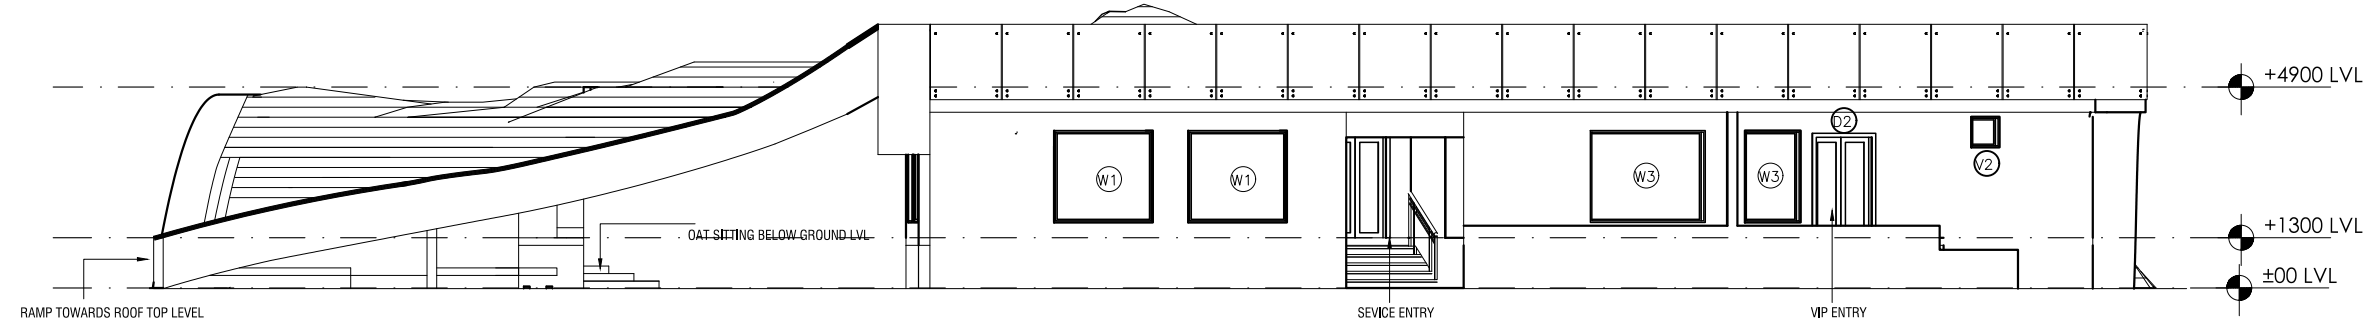

ELEVATION 03

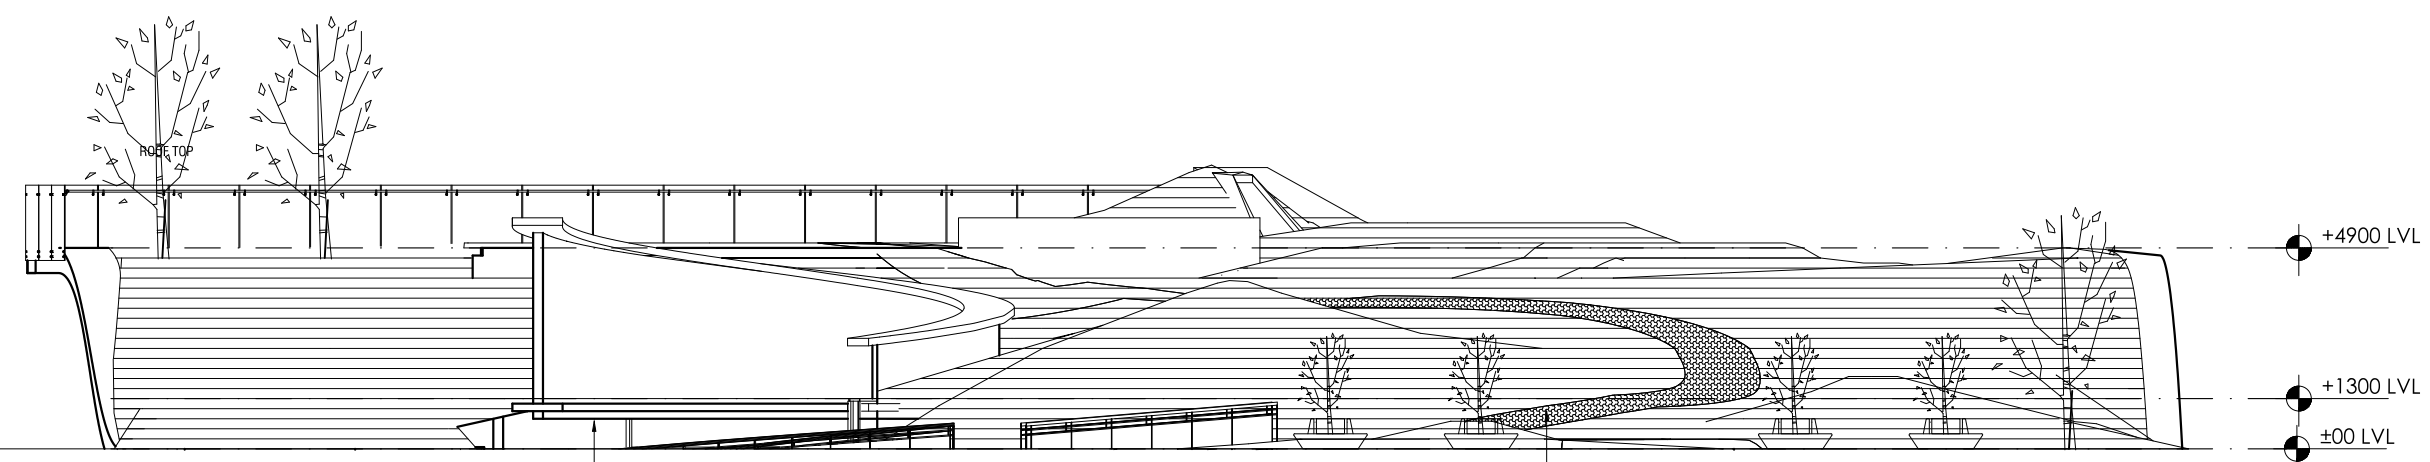

ELEVATION 02

AWN
**A. Wallabh and
Wallabh Associates**
Architecture, Interiors, Planning, Landscape
and Project Management
B-5/86, Paschim Vihar,
New Delhi - 110063

AR. HEMANGI WALLABH
0-9990604334

C.O.A. NO. **AR/2015/0082/MPPWD**

DRAWN BY :
AR. SHASHANK
GOYAL
0-9669137471

CHECKED BY :
AR. HEMANGI WALLABH
0-9990604334

SIGN AND STAMP :



APPROVAL NOTES

DRG NO: AR-SEC-01
DATE: 09 SEP 2017

PROJECT:
INTIMATE THEATER AND
O.A.T. DESIGN AT
BHAWARTAL LAKE,
JABALPUR

SHEET TITLE:
SITE SECTIONS

NORTH SCALE: 1:100

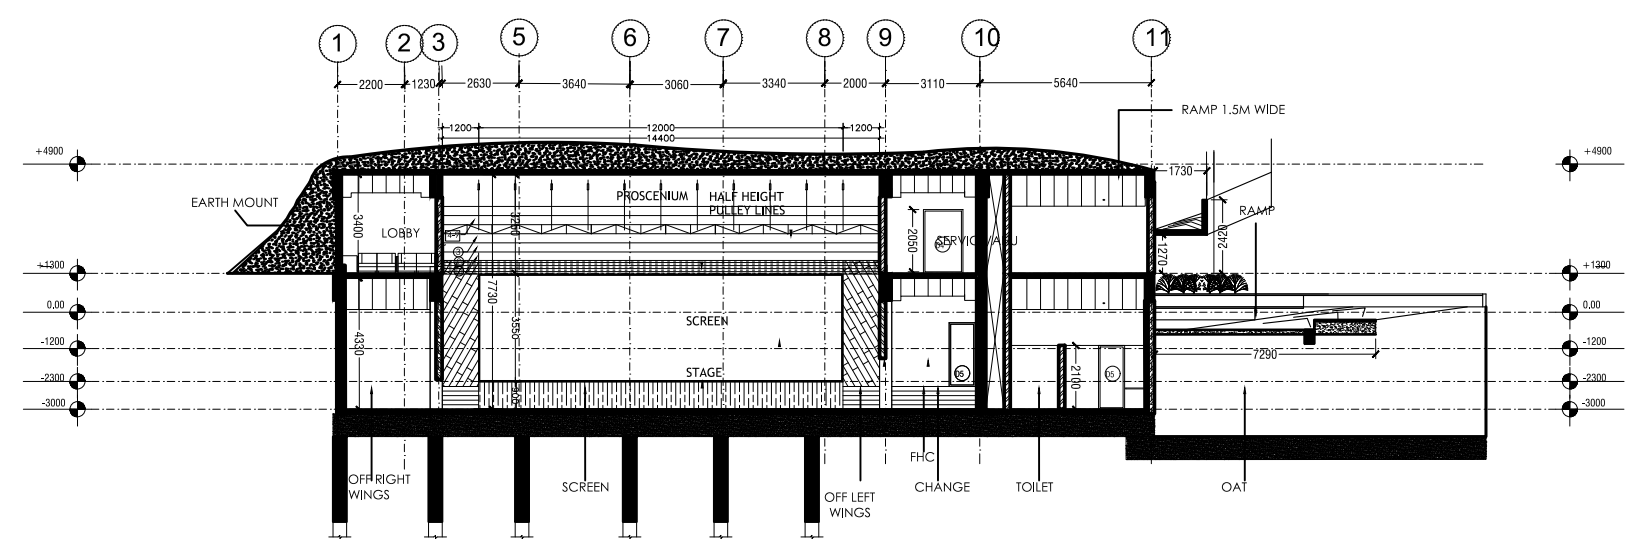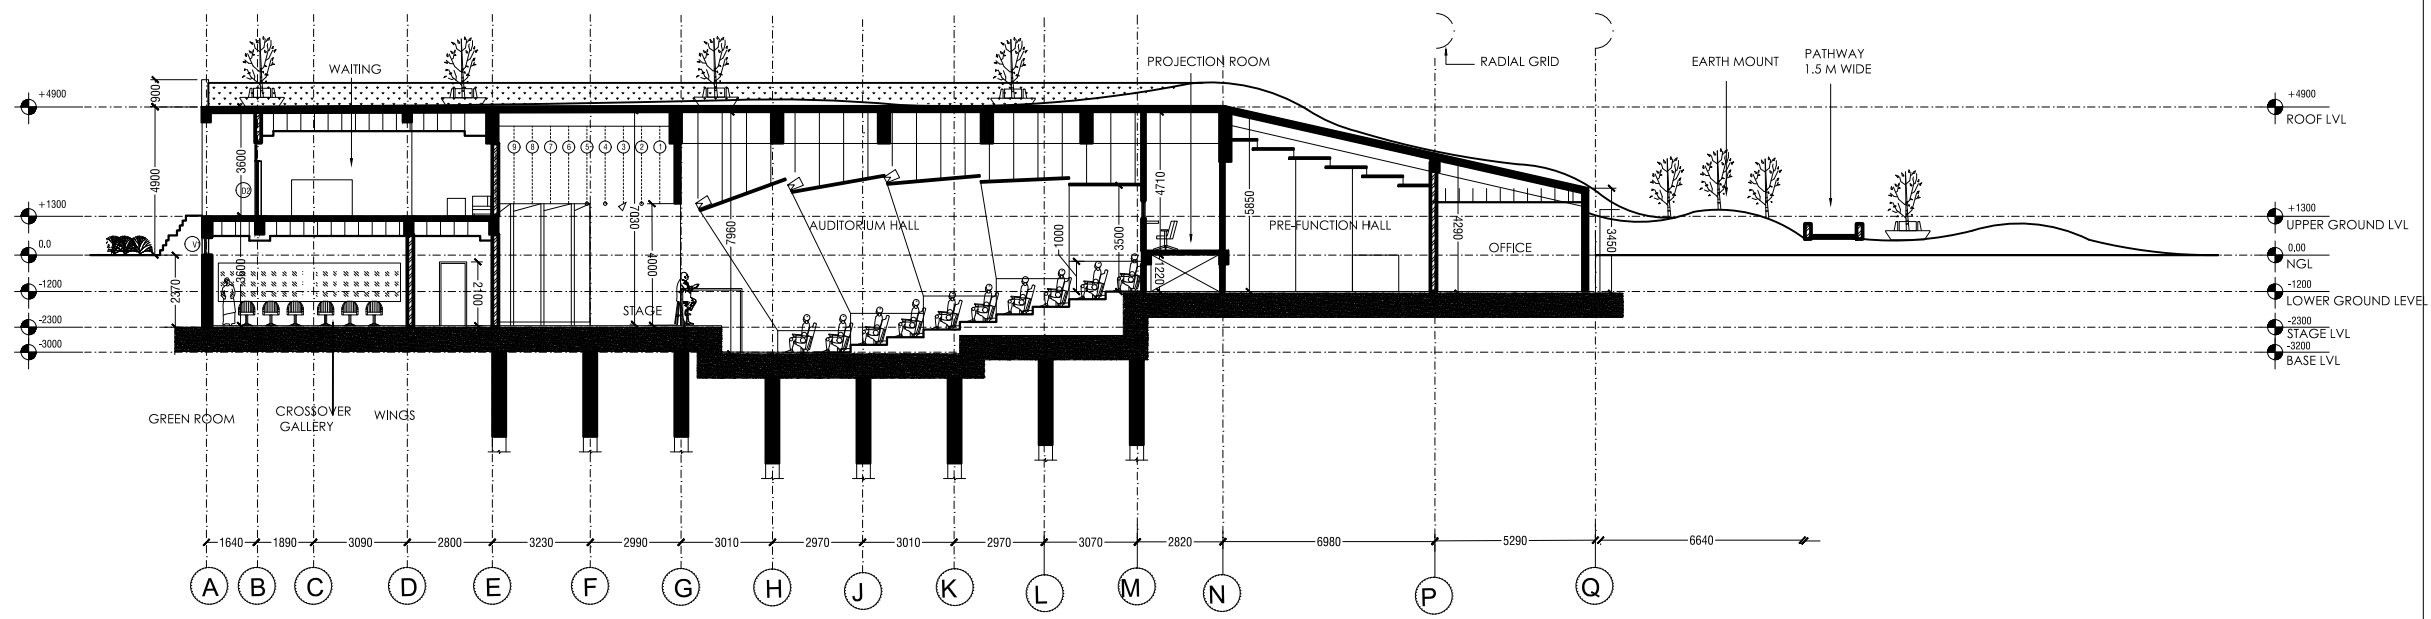

AWN
**A. Wallabh and
Wallabh Associates**
Architecture, Interiors, Planning, Landscape
and Project Management
B-5/86, Paschim Vihar,
New Delhi - 110063

AR. HEMANGI WALLABH

DRAWN BY: AR. SHASHANK GOYAL	CHECKED BY: AR. HEMANGI WALLABH
------------------------------------	---------------------------------------

SIGN AND STAMP:

 
 
 
 
 
 
 
APPROVAL NOTES

PROJECT :
INTIMATE THEATER AND
O.A.T. DESIGN AT
BHAWARTAL LAKE,
JABALPUR

SHEET TITLE :
STRUCTURE :
FOUNDATION PLAN


NORTH  SCALE: 1:200

COLUMN SCHEDULE




TIES	(600x750)	(450x600)	(230x600)	(300x450)	(450x600)	(300x600)	(300x860)
SIZE	(600x750)	(450x600)	(230x600)	(300x450)	(450x600)	(300x600)	(300x860)
DETAIL							
REINF.	20-25 #	16-25 #	8-20 #	10-25 #	16-25 #	12-25 #	12-25 #
FLOORS	M 30	M 30	M 25	M 30	M 30	M 30	M 30
COL.MKD	C1	C2	C3	C4	C5	C6	C7

FOOTING SCHEDULE

FIG.MKD	DIMENSIONS		THICKNESS	REINFORCEMENT	
	LX	LY		R/F AT BOT. B/W	R/F AT TOP B/W
F1	2000	2500	600	12# @ 100c/c	-
F2	3000	3000	600	12# @ 100c/c	-

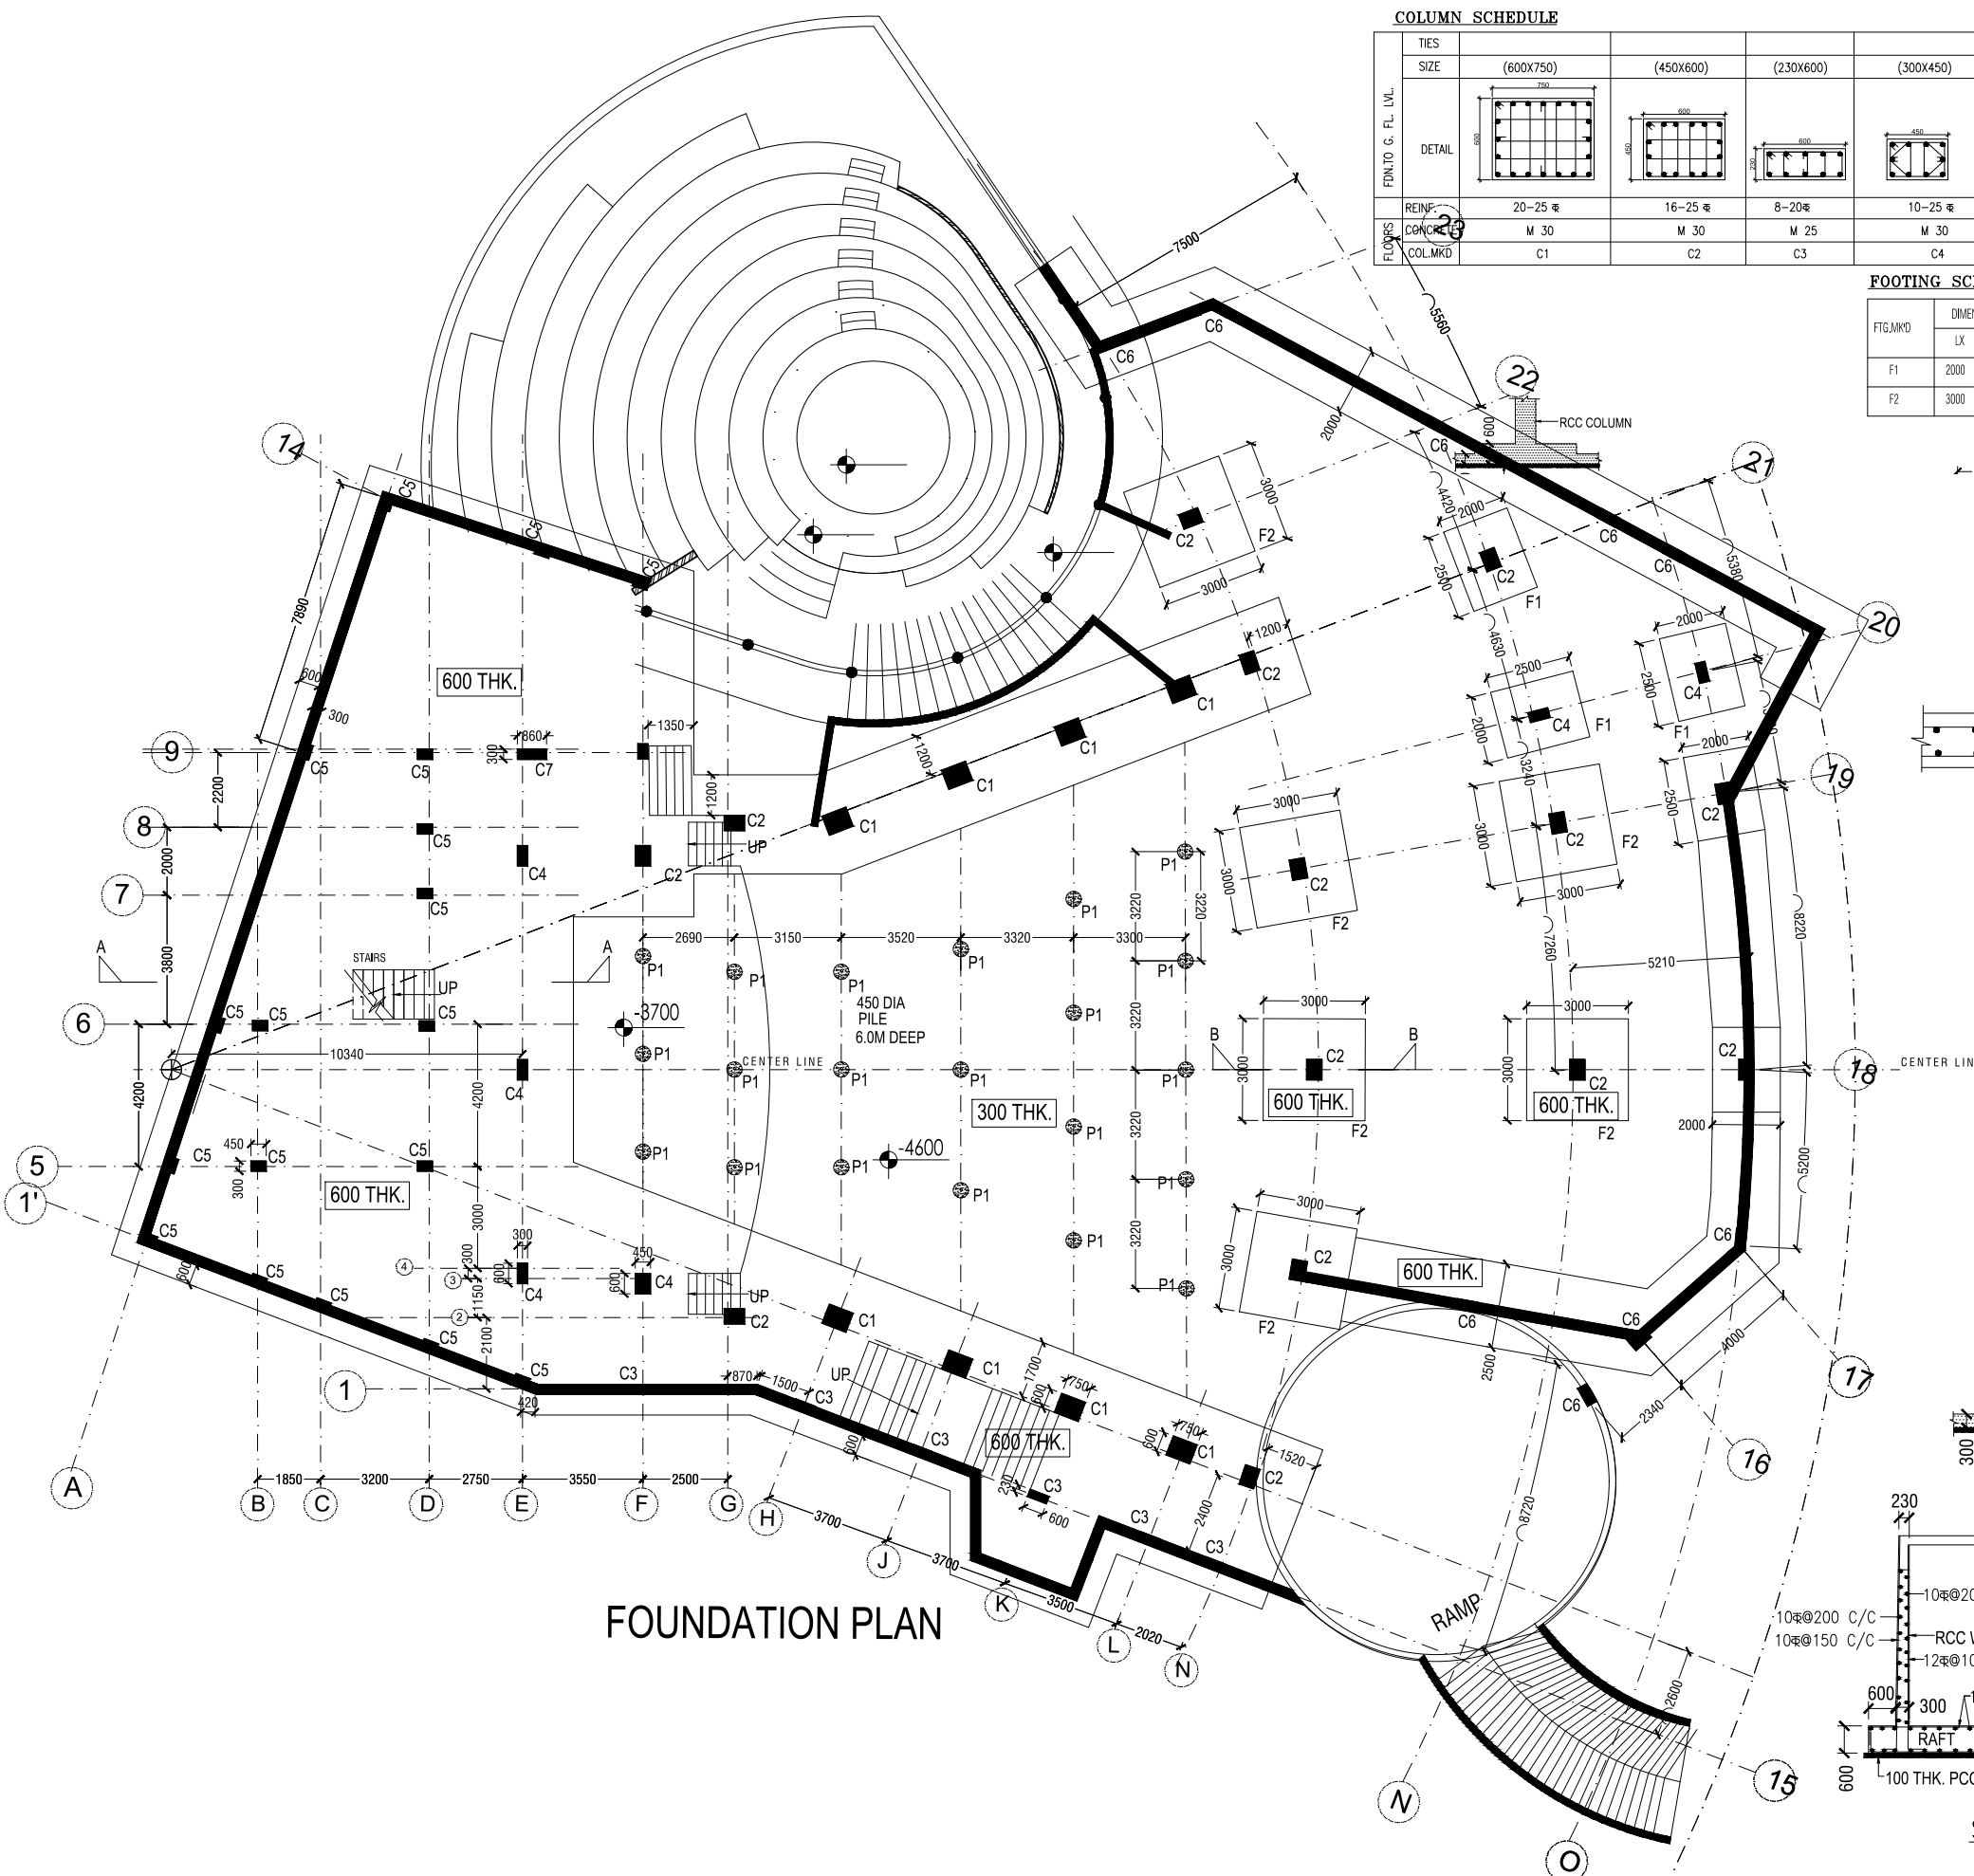

FOUNDATION PLAN

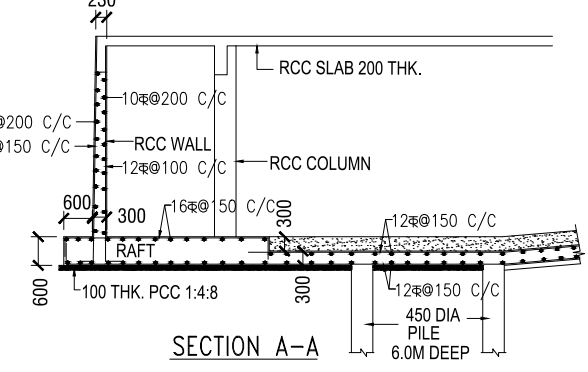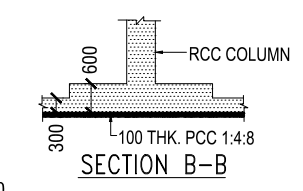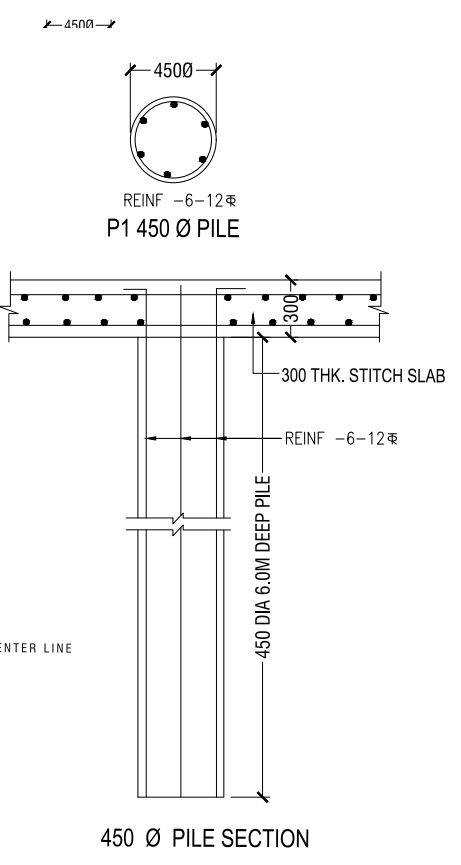

AWNW
A. Wallabh and Wallabh Associates

Architecture, Interiors, Planning, Landscape and Project Management
B-5/86, Paschim Vihar, New Delhi - 110063

AR. HEMANGI WALLABH

DRAWN BY :
AR. SHASHANK GOYAL

CHECKED BY :
AR. HEMANGI WALLABH

SIGN AND STAMP :

APPROVAL NOTES

DRG NO: ST-PL-03
DATE: 09 SEP 2017


PROJECT :
INTIMATE THEATER AND
O.A.T. DESIGN AT
BHAWARTAL LAKE,
JABALPUR

SHEET TITLE :
PLINTH BEAM PLAN

NORTH



SCALE: 1:200

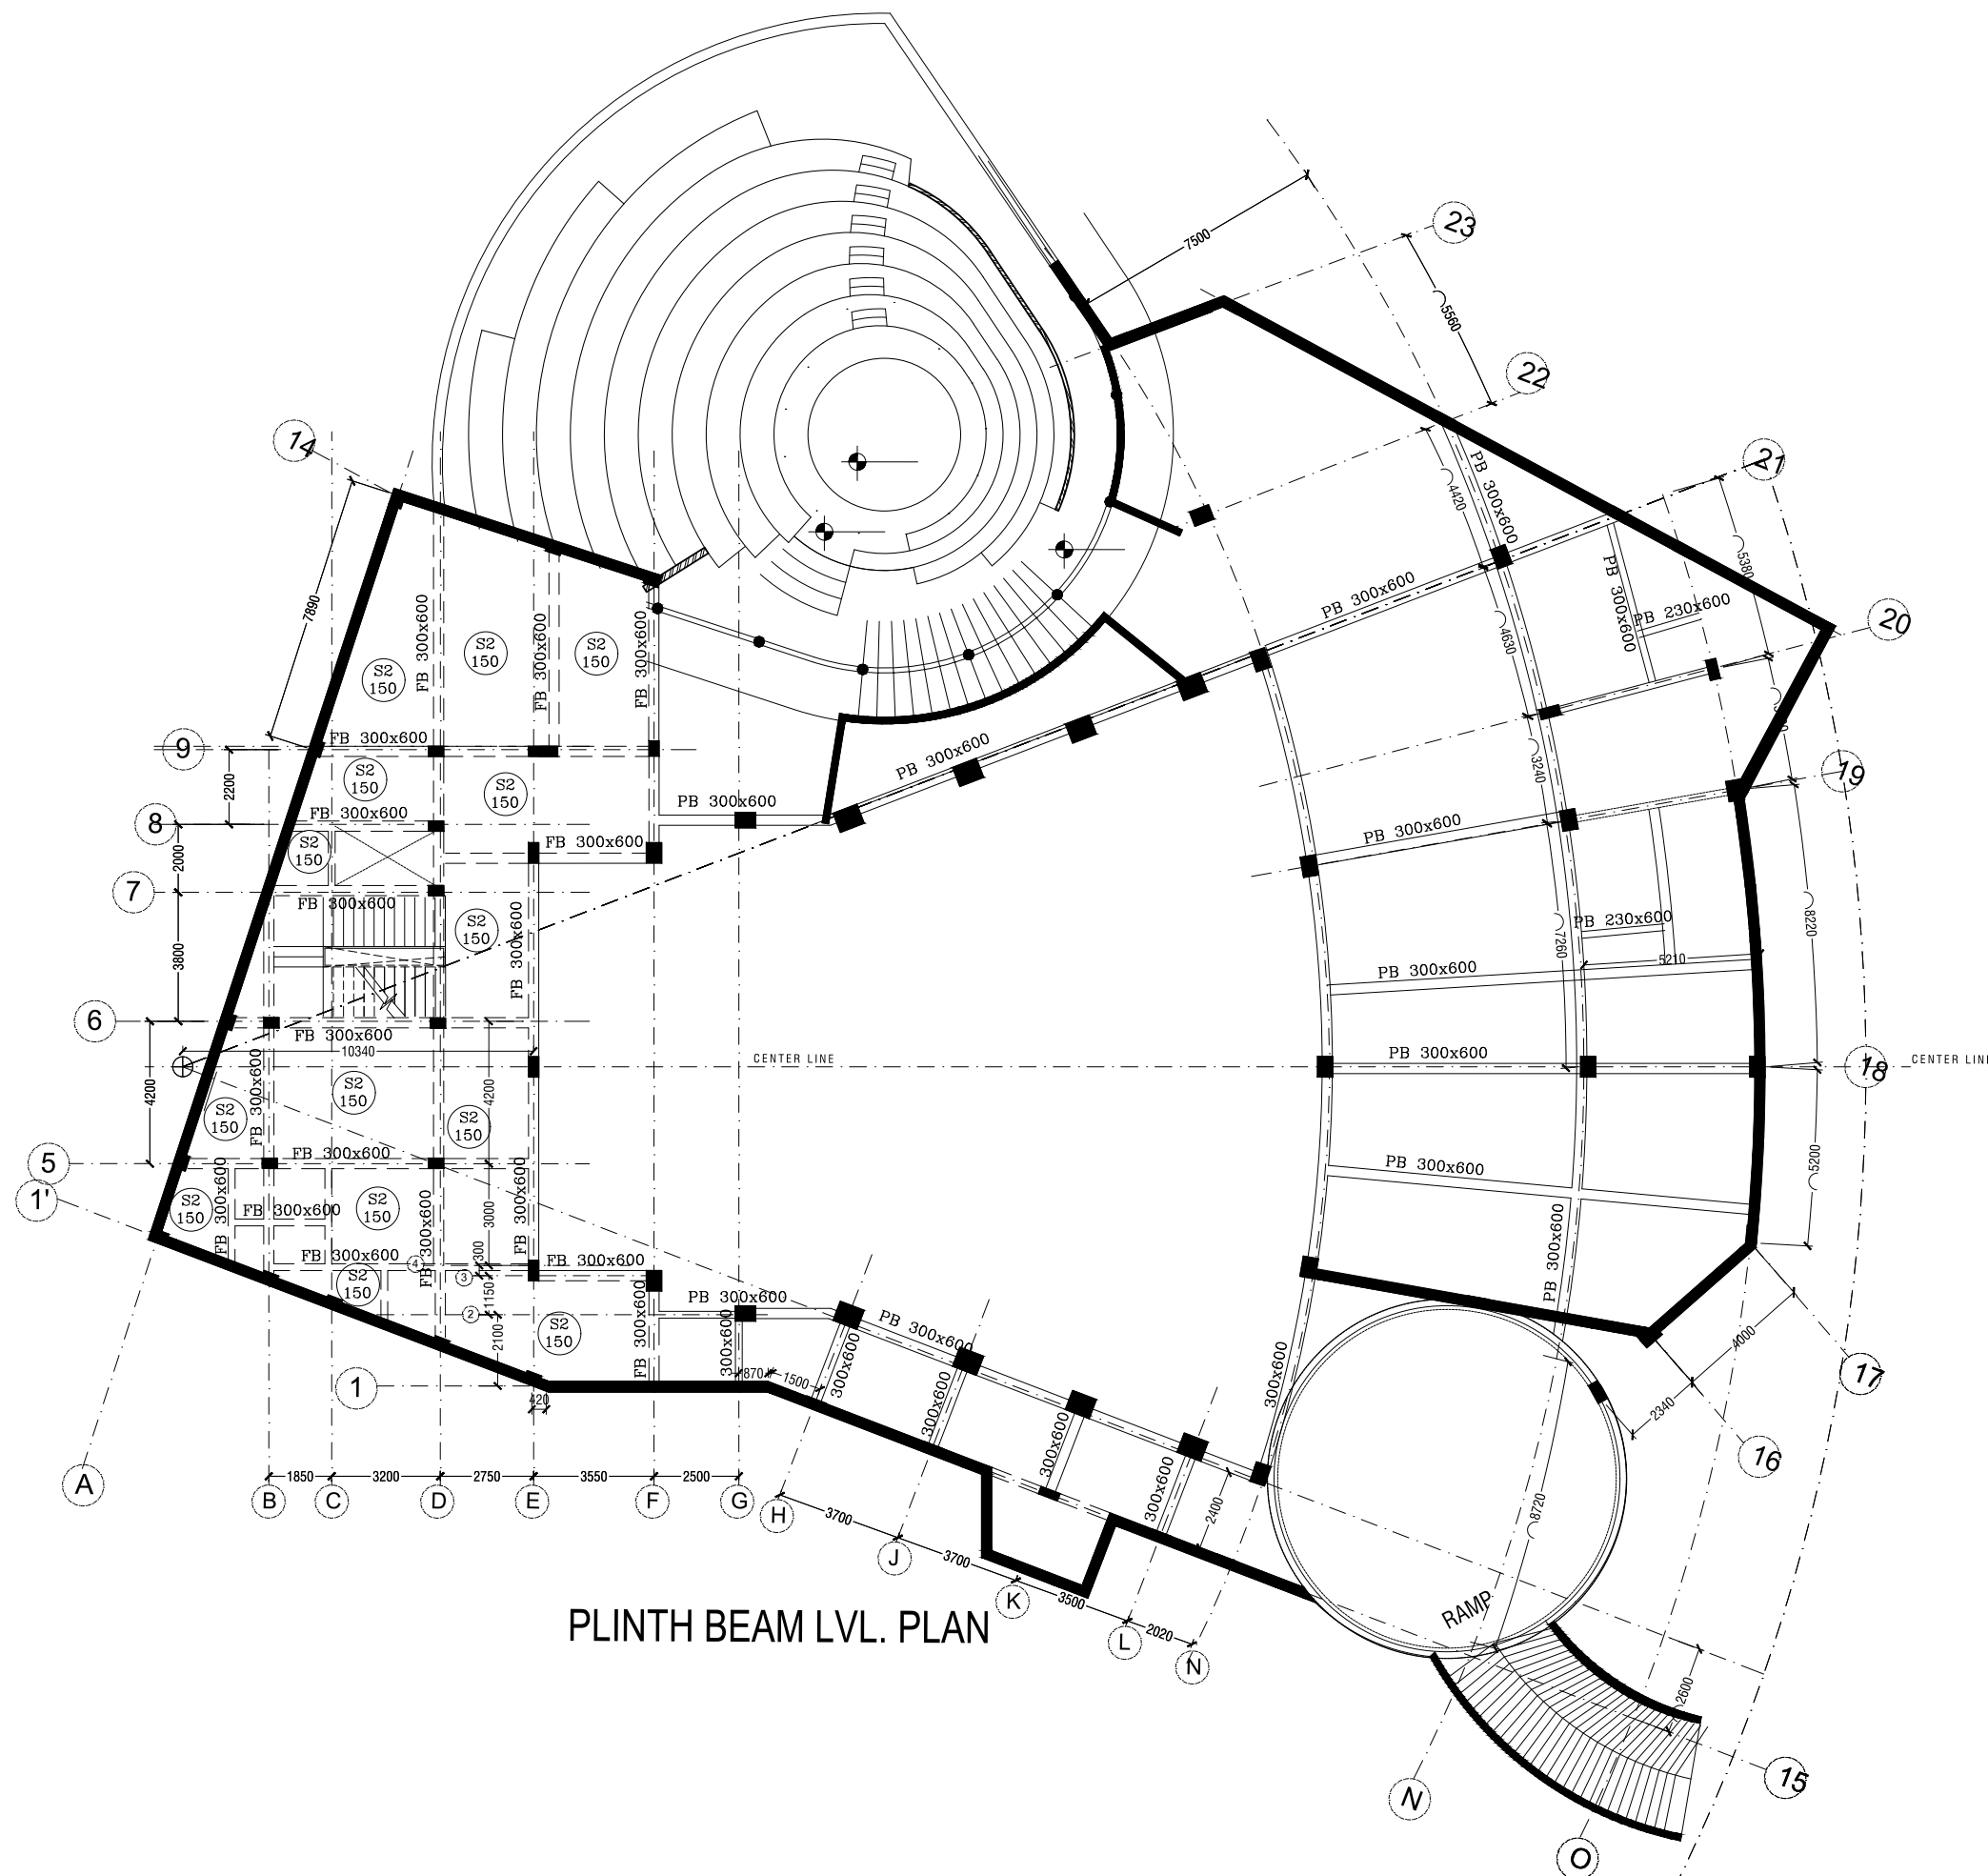

PLINTH BEAM LVL. PLAN

AWN
**A. Wallabh and
Wallabh Associates**

Architecture, Interiors, Planning, Landscape
and Project Management
B-5/86, Paschim Vihar,
New Delhi - 110063

AR. HEMANGI WALLABH

DRAWN BY :
AR. SHASHANK
GOYAL

CHECKED BY :
AR. HEMANGI
WALLABH


SIGN AND STAMP :

APPROVAL NOTES

PROJECT :
INTIMATE THEATER AND
O.A.T. DESIGN AT
BHAWARTAL LAKE,
JABALPUR

SHEET TITLE :
STRUCTURE :
ROOF FRAMING PLAN

NORTH  SCALE: 1:200

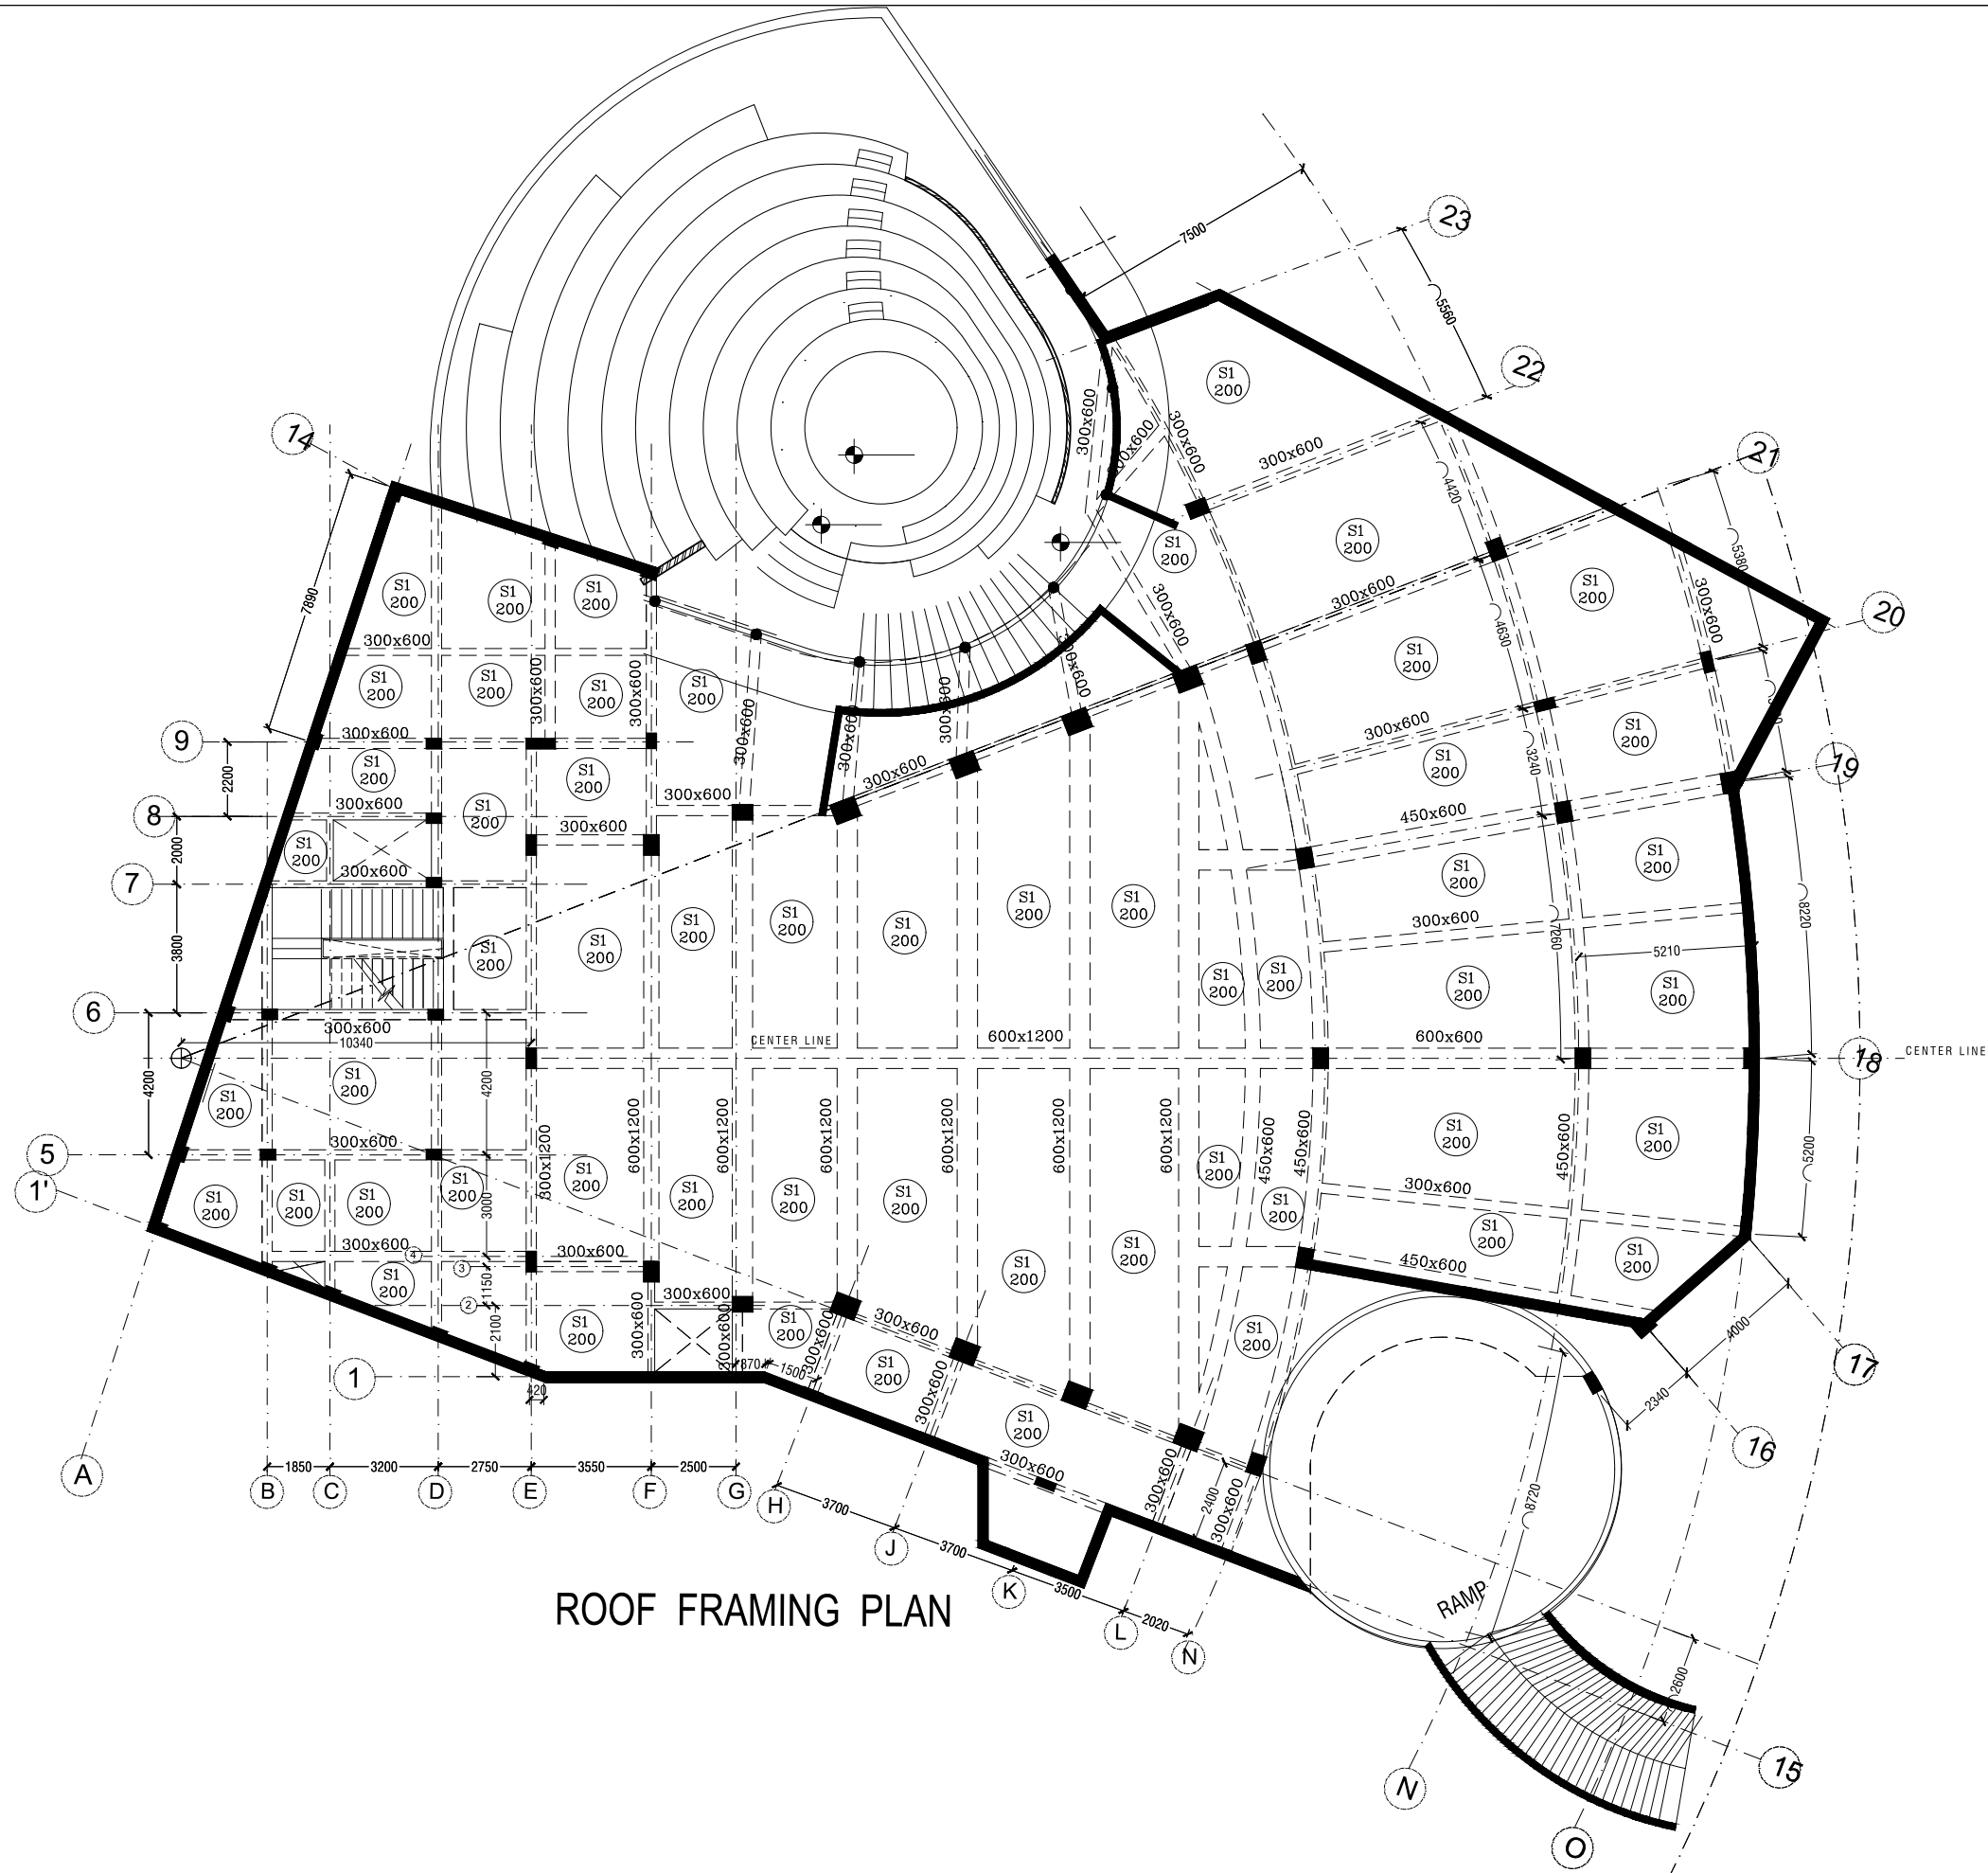

ROOF FRAMING PLAN

AWN
**A. Wallabh and
Wallabh Associates**

Architecture, Interiors, Planning, Landscape
and Project Management
B-5/86, Paschim Vihar,
New Delhi - 110063

AR. HEMANGI WALLABH

DRAWN BY :
AR. SHASHANK
GOYAL

CHECKED BY :
AR. HEMANGI
WALLABH


SIGN AND STAMP :







 


 







 






APPROVAL NOTES

DRG NO: AR-PL-01
DATE 10 SEP 2017

PROJECT :
INTIMATE THEATER AND
O.A.T. DESIGN AT
BHAWARTAL LAKE,
JABALPUR

SHEET TITLE :
ELECTRICAL LAYOUT
LEVEL -1200

NORTH  SCALE: 1:150

SYMBOL	LIGHT TYPE
	EXIT LAMP 3000 HT
	CFL LIGHT FIXTURE AS/SELECTION
	FOCUS LIGHT /MIRROR COVE
	HALOGEN LIGHT IN AUDI HALL
	CASSETTE UNIT
	LED STRIP LIGHT
	TS FLOURESCENT LIGHT
	NIGHT LAMP AT HT. 300MM
	WALL SCONCES
	FANS
	WALL LIGHT
	PENDANT WALL LIGHT
	D.B. 1500 HT
	TUBE LIGHT 2400 HT
	POWER SWITCH 15 A
	POWER SWITCH 5 A
	CEILING CFL
	EXHAUST FAN
	WALL CFL
	LIGHT CONNECTION
	WALL FAN
	SWITCH BOARD
	TELEPHONE
	DB

AWN
**A. Wallabh and
Wallabh Associates**
Architecture, Interiors, Planning, Landscape
and Project Management
B-5/86, Paschim Vihar,
New Delhi - 110063


AR. HEMANGI WALLABH

DRAWN BY :
AR. SHASHANK
GOYAL

CHECKED BY :
AR. HEMANGI
WALLABH

SIGN AND STAMP :


APPROVAL NOTES

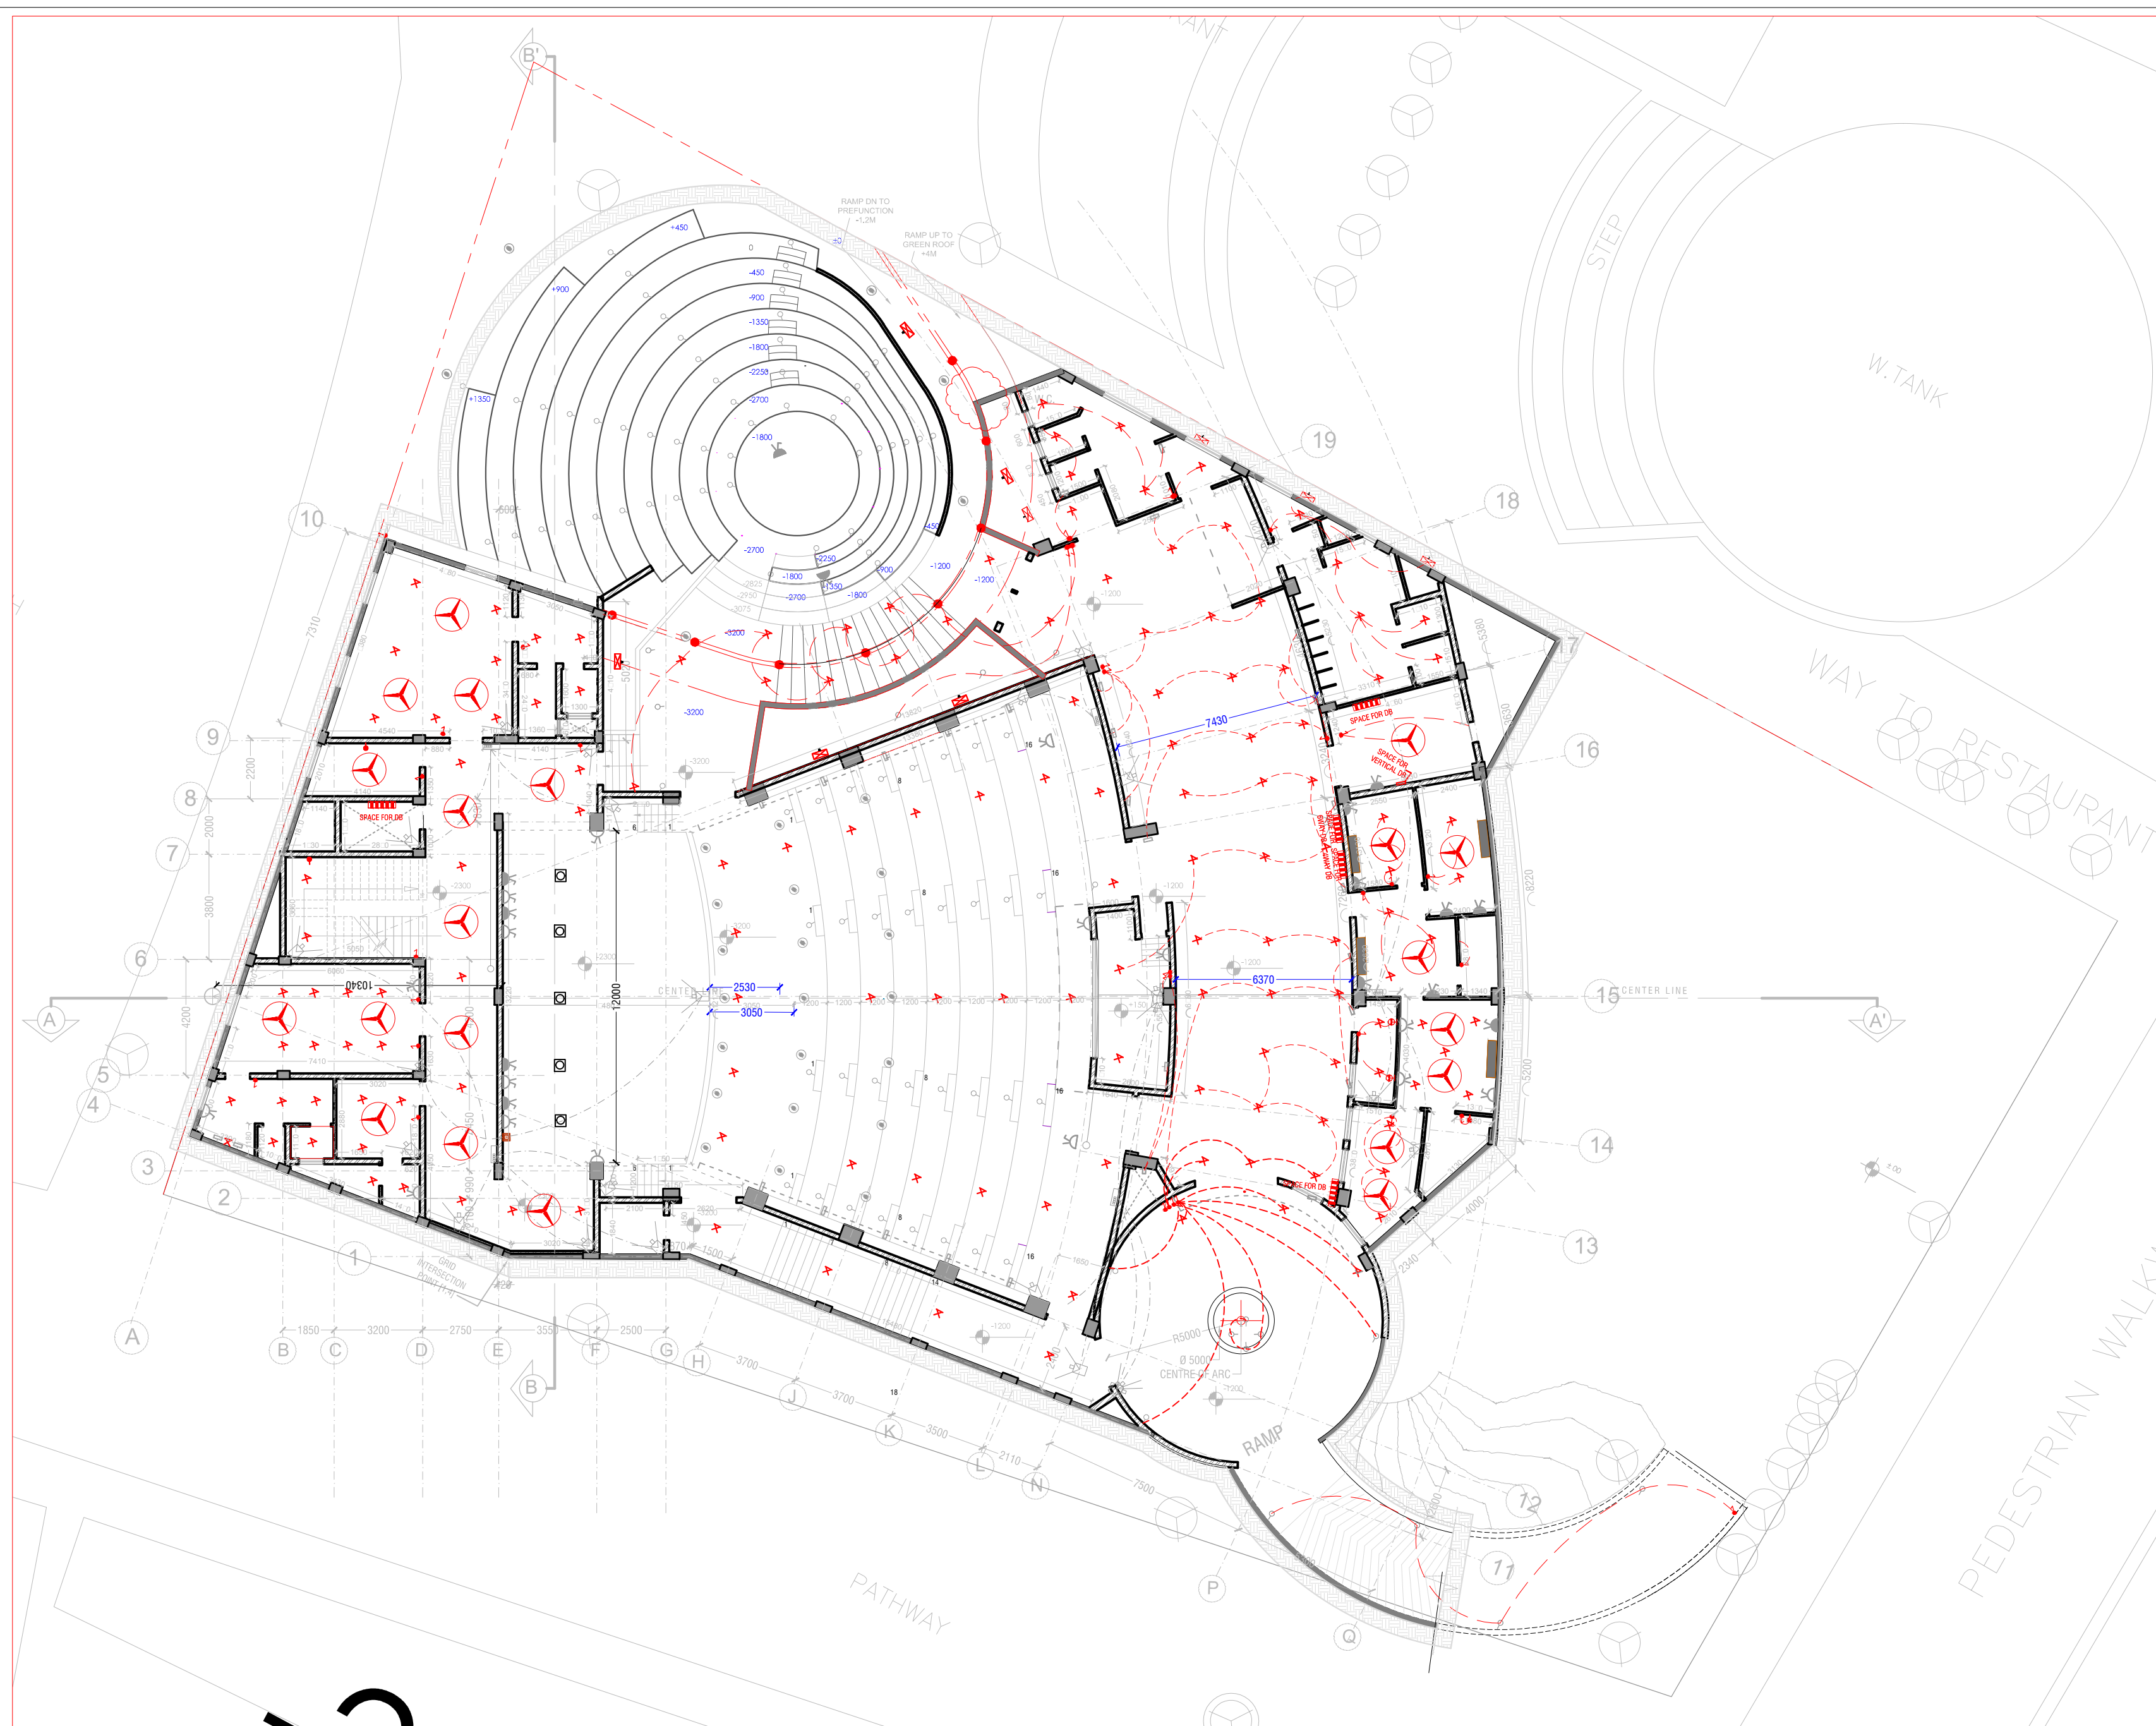








 




 



 



 



DRG NO: AR-PL-01
DATE: 10 SEP 2017

PROJECT:
INTIMATE THEATER AND
O.A.T. DESIGN AT
BHAWARTAL LAKE,
JABALPUR

SHEET TITLE:
ELECTRICAL LAYOUT
LEVEL +1300

NORTH  SCALE: 1:150

SYMBOL	LIGHT TYPE
	EXIT LAMP 3000 HT
	CFL LIGHT FIXTURE AS/SELECTION
	FOCUS LIGHT /MIRROR COVE
	HALOGEN LIGHT IN AUDI HALL
	CASSETTE UNIT
	LED STRIP LIGHT
	T5 FLOURESCENT LIGHT
	NIGHT LAMP AT HT. 300MM
	WALL SCONCES
	FANS
	WALL LIGHT
	PENDANT WALL LIGHT
	D.B. 1500 HT
	TUBE LIGHT 2400 HT
	POWER SWITCH 15 A
	POWER SWITCH 5 A
	CEILING CFL
	EXHAUST FAN
	WALL CFL
	LIGHT CONNECTION
	WALL FAN
	SWITCH BOARD
	TELEPHONE
	DB

AWN
**A. Wallabh and
Wallabh Associates**

Architecture, Interiors, Planning, Landscape
and Project Management
B-5/86, Paschim Vihar,
New Delhi - 110063


AR. HEMANGI WALLABH

DRAWN BY:
AR. SHASHANK
GOYAL

CHECKED BY:
AR. HEMANGI
WALLABH


SIGN AND STAMP:


APPROVAL NOTES

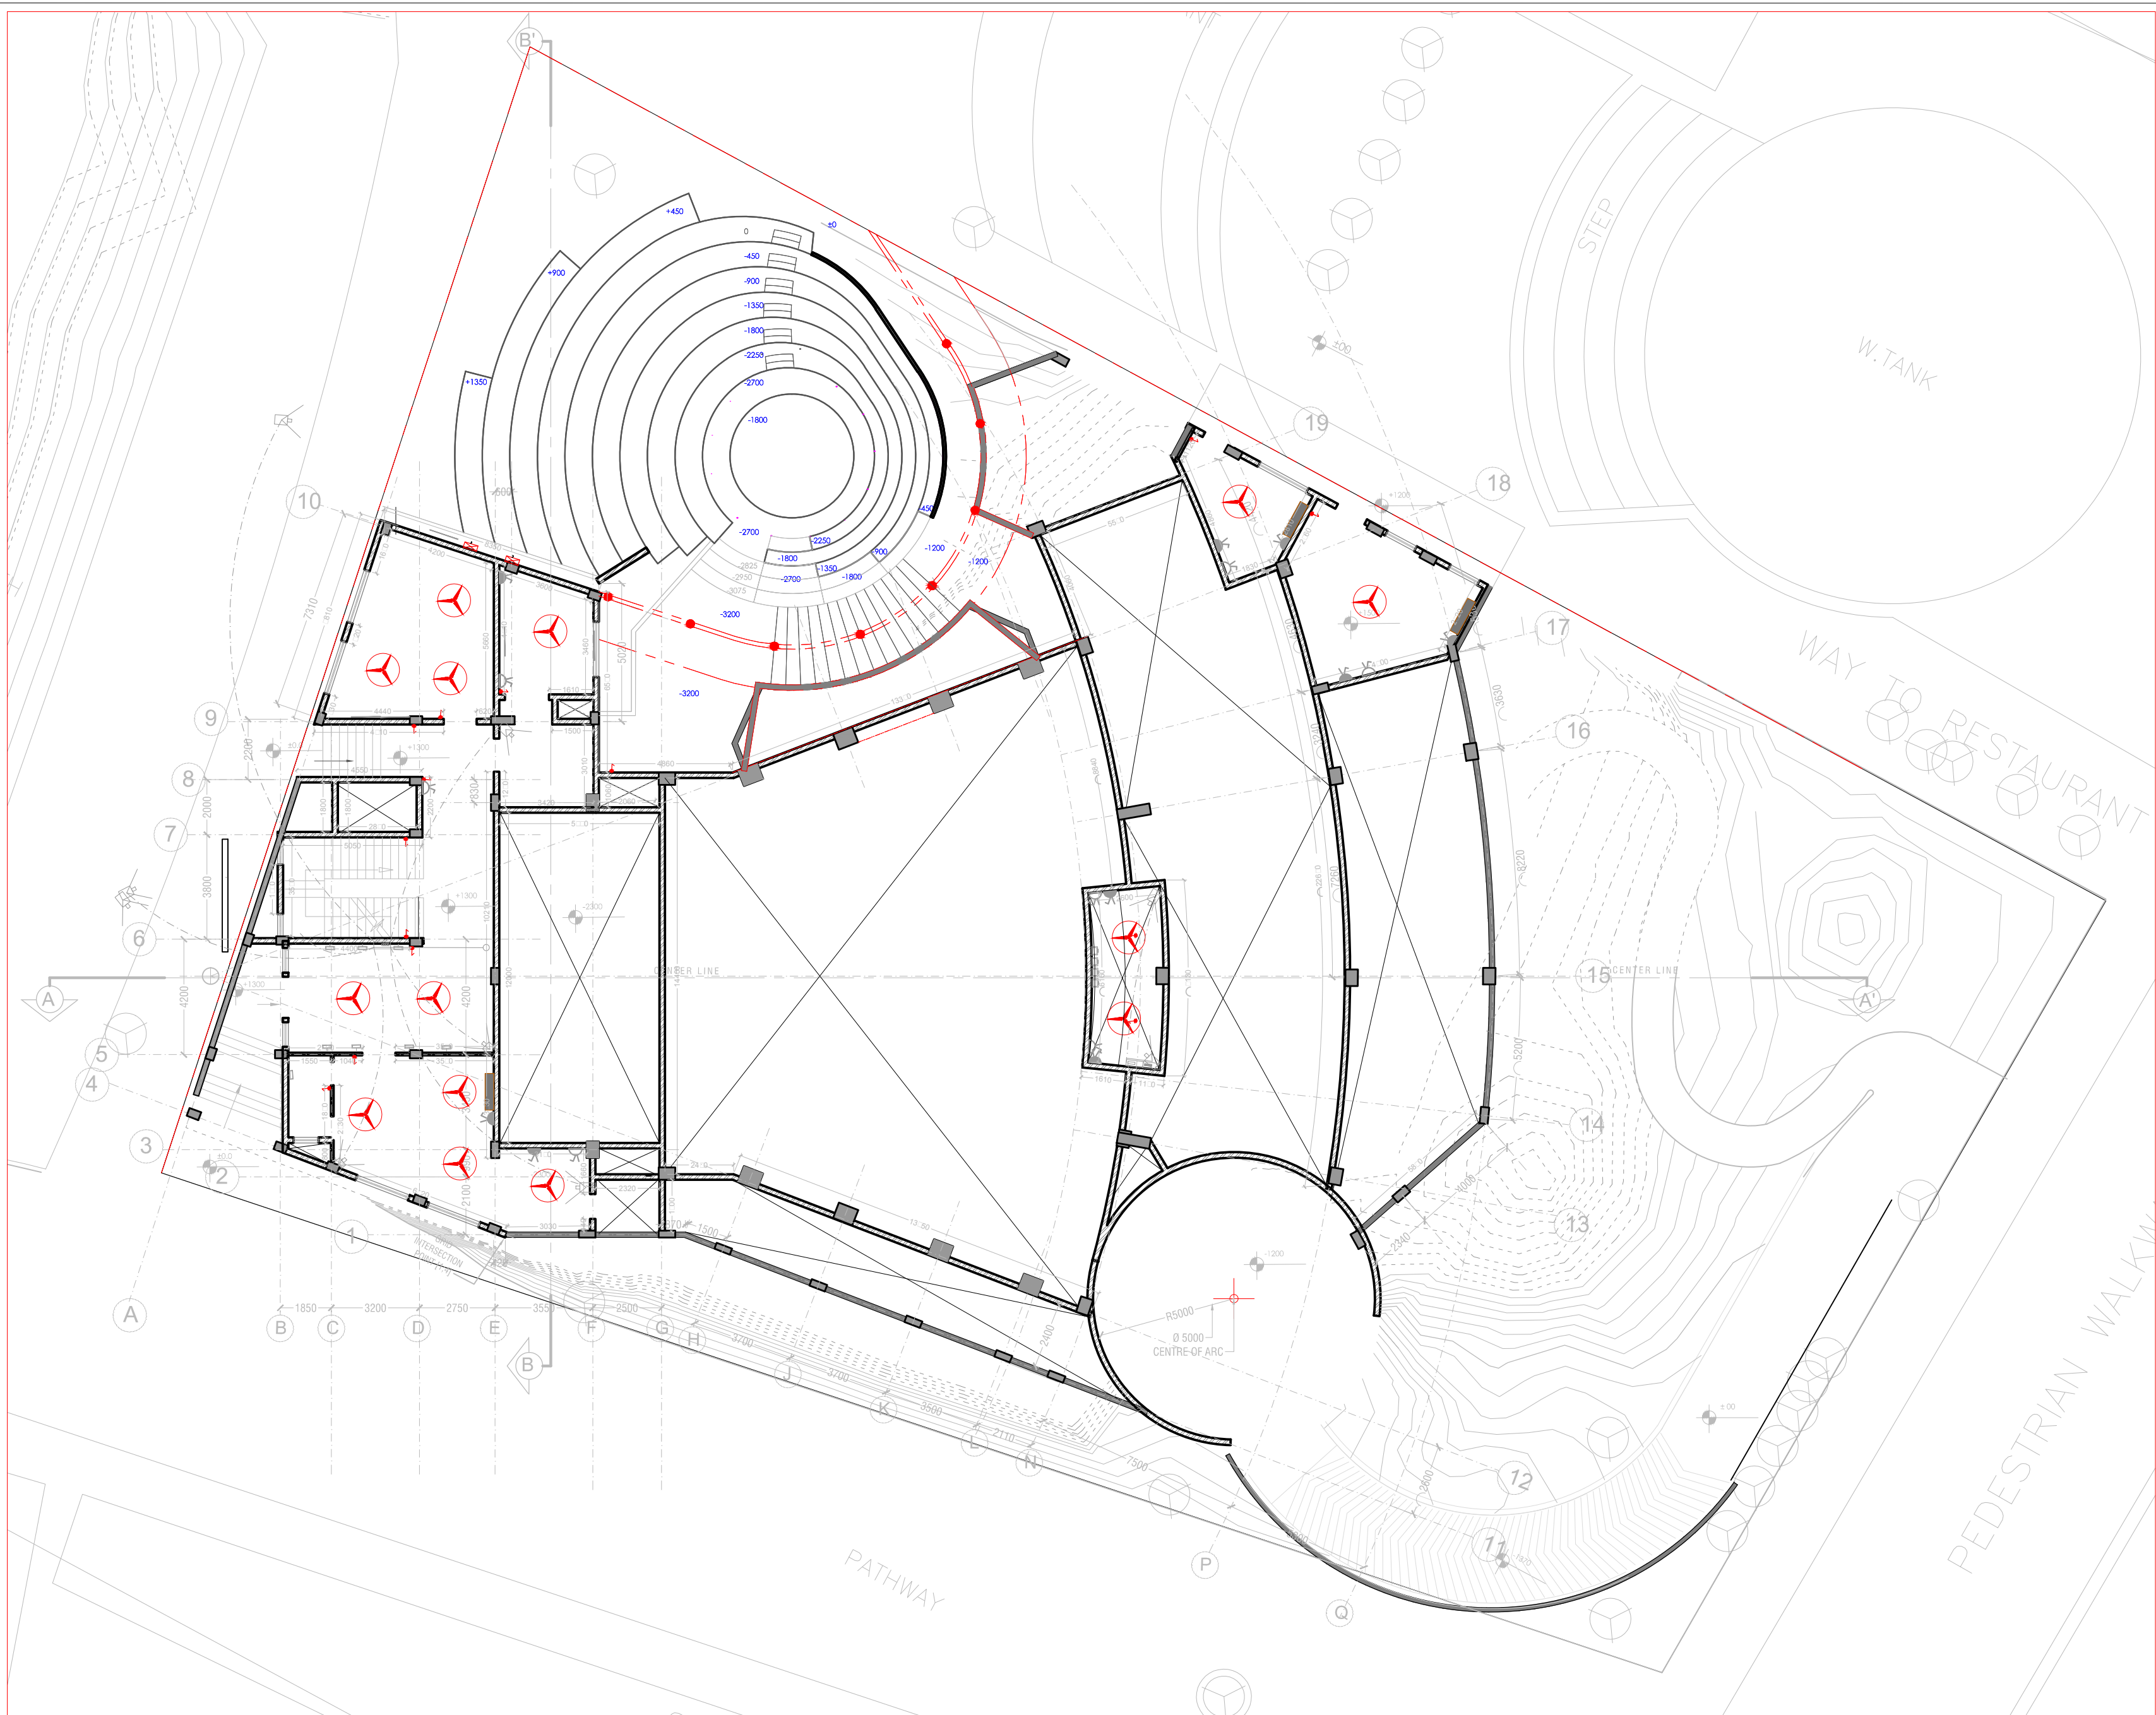




PROJECT :
 INTIMATE THEATER AND
 O.A.T. DESIGN AT
 BHAWARTAL LAKE,
 JABALPUR

SHEET TITLE :
 SERVICE PLANS
 PLUMBING - SITE

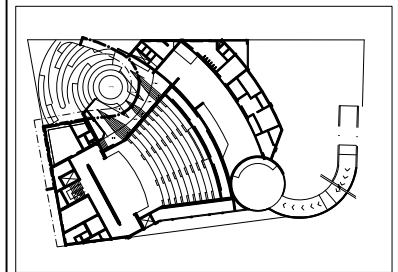NORTH  SCALE: 1:200



SYMBOL	LEGEND
	SOIL PIPE
	WASTE WATER PIPE
	WATER SUPPLY PIPE

AWN
**A. Wallabh and
 Wallabh Associates**
 Architecture, Interiors, Planning, Landscape
 and Project Management
 B-5/86, Paschim Vihar,
 New Delhi - 110063


AR. HEMANGI WALLABH

DRAWN BY :
 AR. SHASHANK
 GOYAL

CHECKED BY :
 AR. HEMANGI
 WALLABH



SIGN AND STAMP :

APPROVAL NOTES

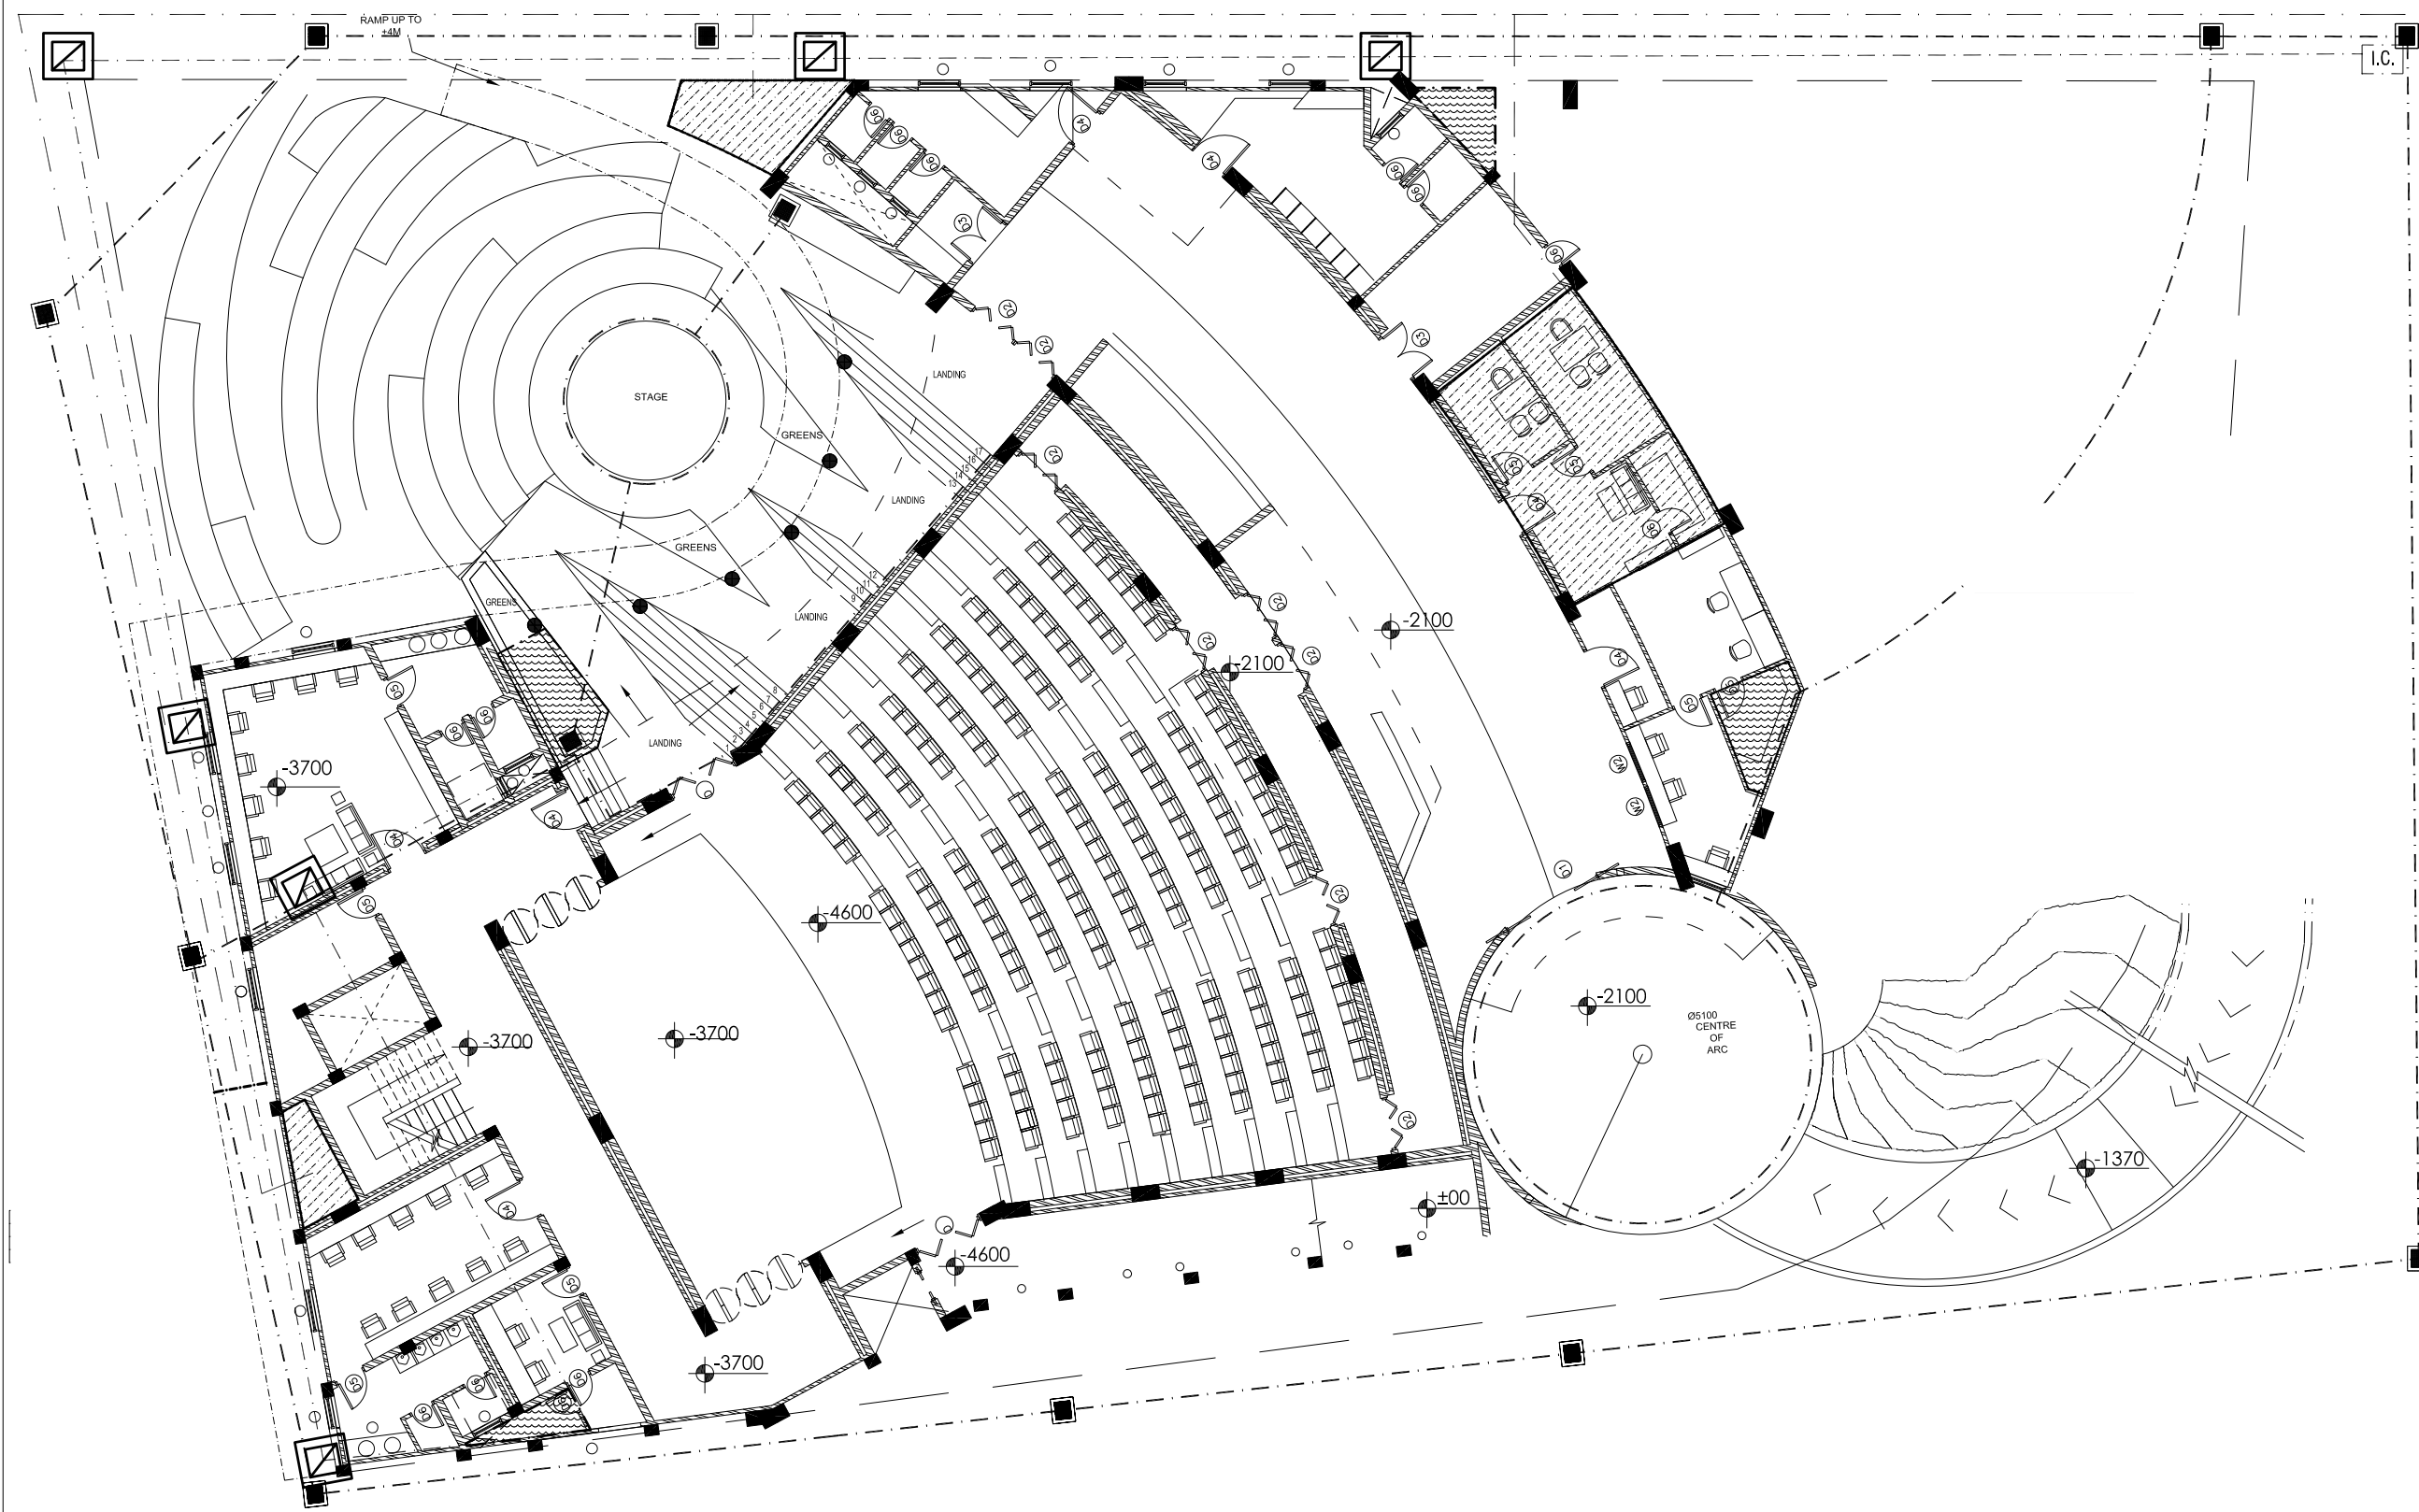


DRG NO: IT-LA-GR-02
 DATE 01 AUG 2017
 PROJECT :
 INTIMATE THEATER AND
 O.A.T. DESIGN AT
 BHAWARTAL LAKE,
 JABALPUR


SHEET TITLE :
 GREEN ROOF
 DETAIL
 NORTH SCALE: 1:25

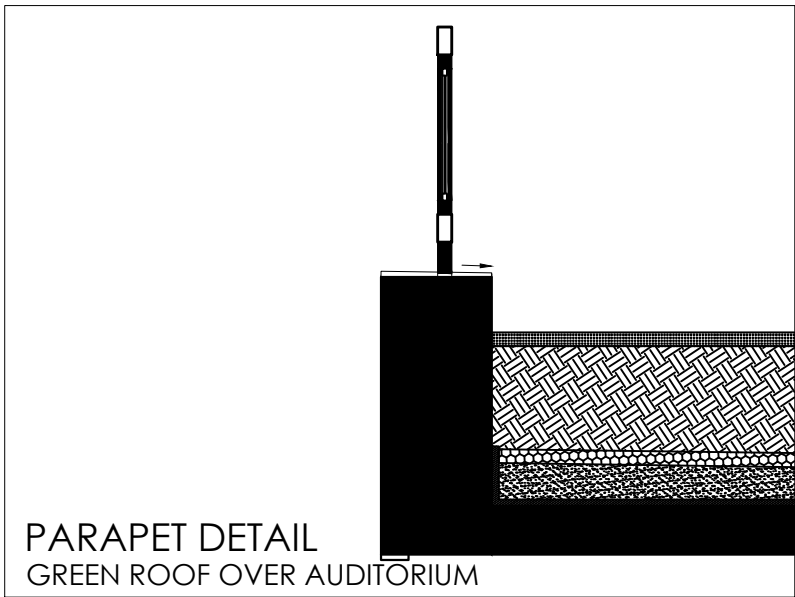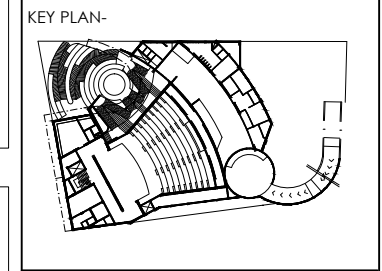


PARAPET DETAIL
 GREEN ROOF OVER AUDITORIUM

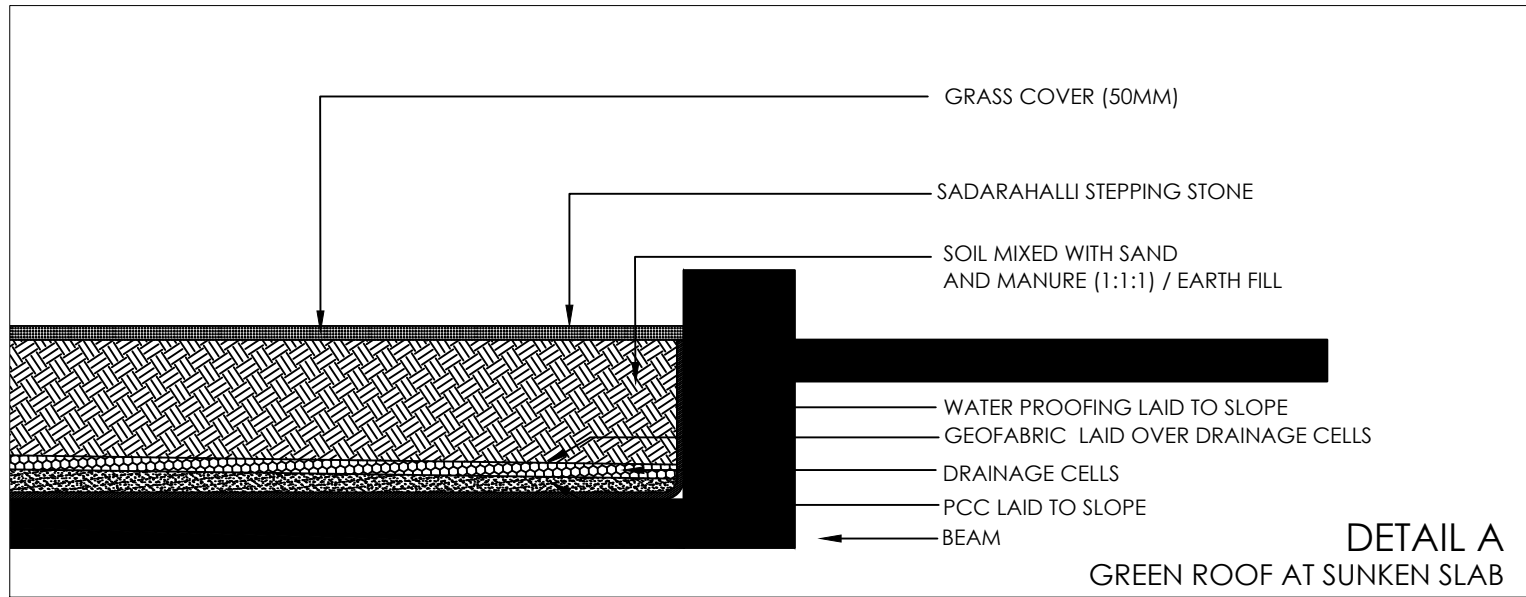


DETAIL A
 GREEN ROOF AT SUNKEN SLAB

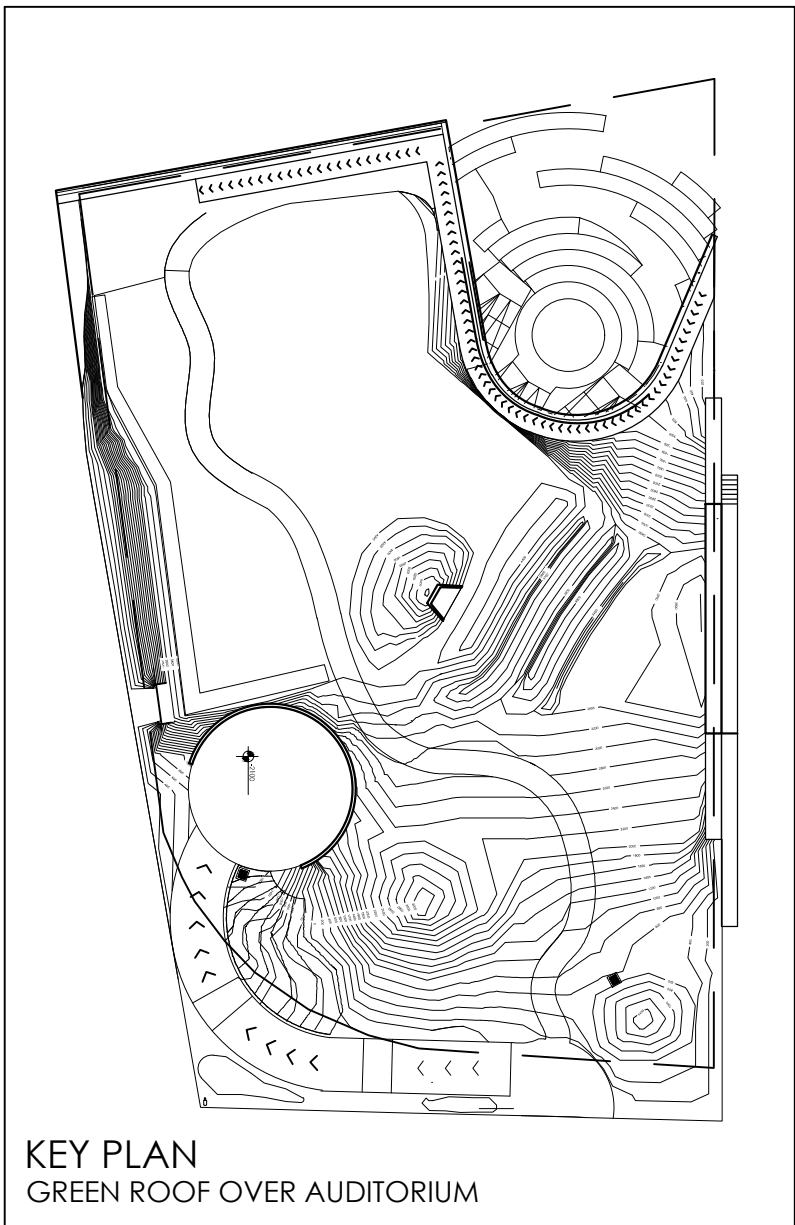

KEY PLAN
 GREEN ROOF OVER AUDITORIUM

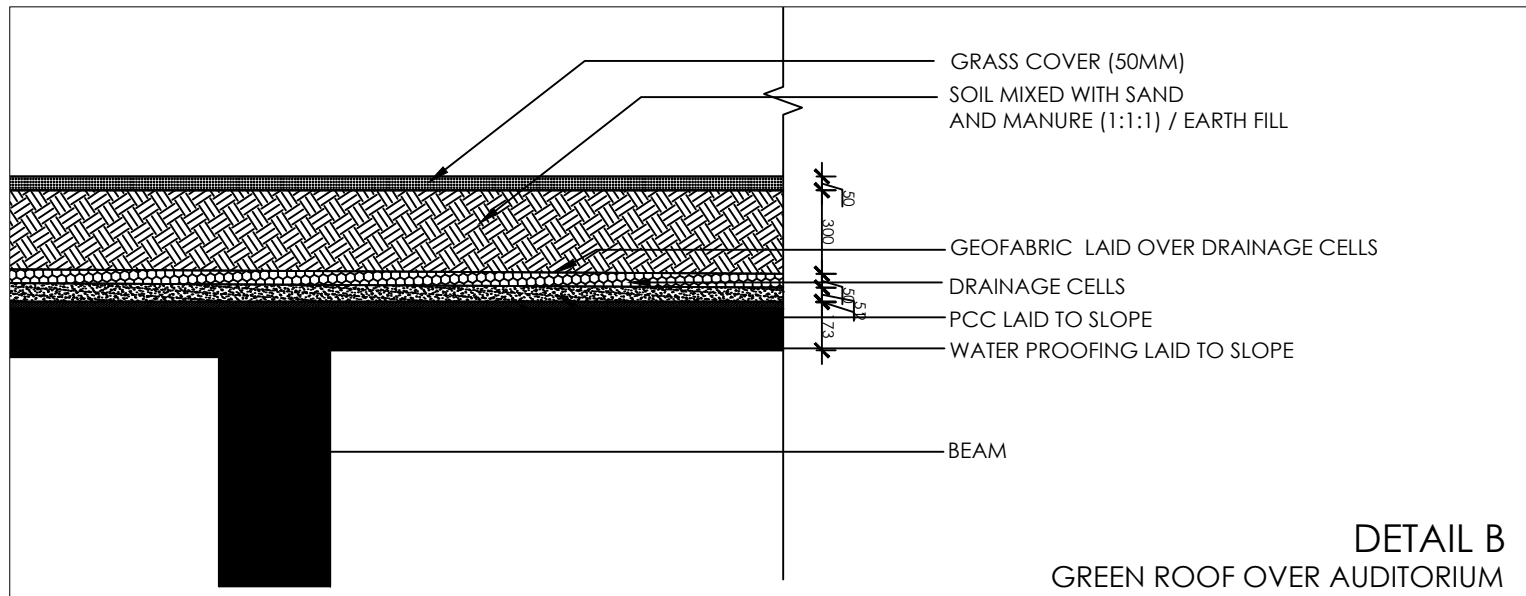

DETAIL B
 GREEN ROOF OVER AUDITORIUM

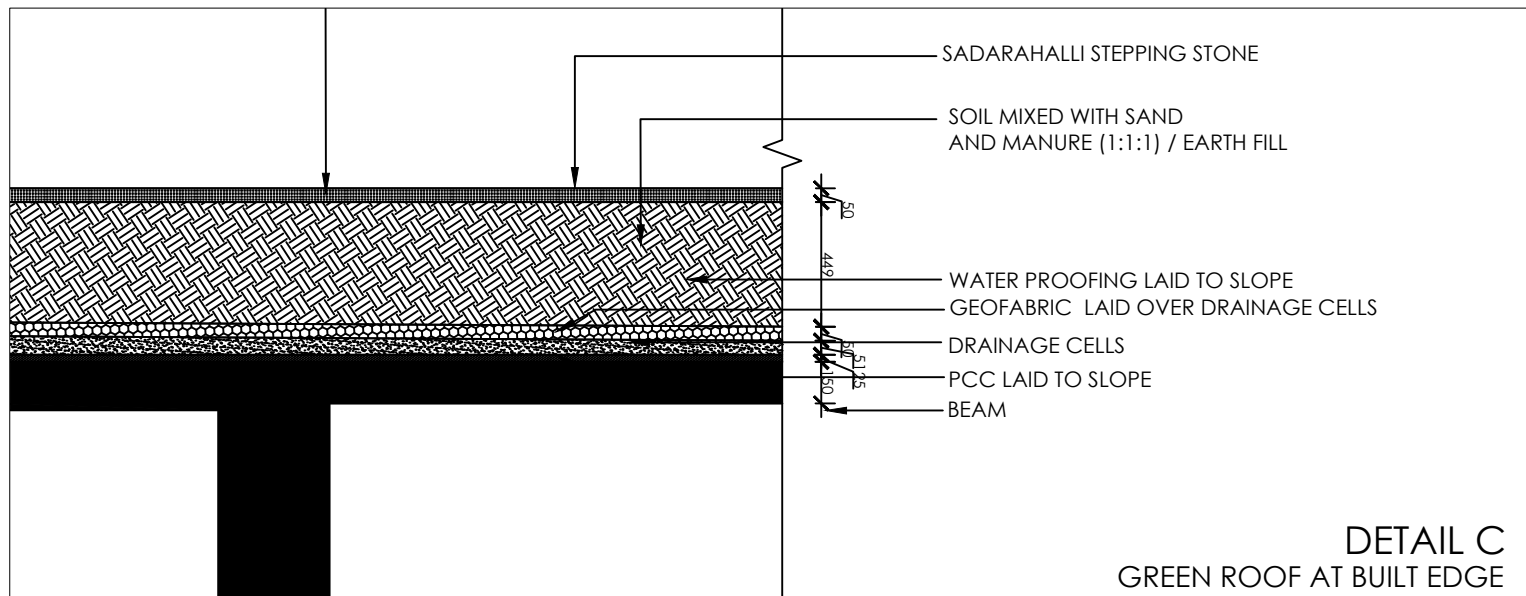

DETAIL C
 GREEN ROOF AT BUILT EDGE

AWN
A. Wallabh and
Wallabh Associates
 Architecture, Interiors, Planning, Landscape
 and Project Management
 B-5/86, Paschim Vihar,
 New Delhi - 110063
AR. HEMANGI WALLABH
 0-9990604334

DRAWN BY :
 AR. SHASHANK
 GOYAL
 CHECKED BY :
 AR. HEMANGI WALLABH

SIGN AND STAMP :
 APPROVAL NOTES